

**THE SAENGER  
THEATRE RENEWAL  
PROJECT**

142 North Rampart Street  
New Orleans, LA

Client  
Saenger Theatre Redevelopment Company  
200 West Loop South, Suite  
1040 Houston TX 77027

Architect  
**MARTINEZ+JOHNSON  
ARCHITECTURE**

1412 Eye St., NW  
Washington, DC 20005  
202.333.4480

Structural Engineer  
Shawn J. Franke, P.E.  
549 Heimer Road San  
Antonio TX 78232  
210.979.7900

Theatre Consultant  
Schuler Shook  
123 Third Street North #210  
Minneapolis, MN 55401  
612.333.5559

Acoustical Engineer  
Akustiks  
93 North Main Street South  
Norwalk, CT 06884  
202.299.1904

MEP Engineer  
JBA Consulting Engineers, Inc.  
3525 N. Causeway Blvd. Suite  
500 Metairie, LA 70002  
504.830.0139

Civil Engineer  
Linfield, Hunter, & Junius, Inc.  
3608 18th Street Suite 200  
Metairie, LA 70002  
504.833.5300

Architectural Historian  
EHT Traceries, Inc.  
1121 Fifth Street NW  
Washington, DC 20001  
202.393.1199

**NOTES**

- ① INDEX STRIP LIGHT, PROVIDED AND INSTALLED BY STAGE RIGGING CONTRACTOR. PROVIDE AND INSTALL 1000W WALL BOX DIMMER MOUNTED AT 4'-0" A.F.F. CONNECTED TO A JUNCTION BOX AT +10'-0" A.F.F. THE INDEX STRIP LIGHT WILL INCLUDE A FLEXIBLE WHIP FOR CONNECTION TO THE JUNCTION BOX.
- ② PROVIDE RECEPTACLE FOR LIGHTING EQUIPMENT. LOCATE IN CRP-15.
- ③ 24 CONDUCTORS WIRE PER TABLE.
- ④ 12 CONDUCTORS WIRE PER TABLE.
- ⑤ SEE SINGLE LINE DIAGRAM FOR FEEDER REQUIREMENTS.

**CIRCUIT  
WIRING TABLE**

| DISTANCE    | 20A | 50A |
|-------------|-----|-----|
| 0' - 145'   | #10 | #6  |
| 146' - 225' | #8  | #4  |
| 226' - 350' | #6  | #2  |

**NOTICE**

(APPLIES TO DIMMER & RELAY CONTROLLER CIRCUITS)

1. EACH 120V CIRCUIT SHALL BE 2 CONDUCTORS, SEPARATE NEUTRALS REQUIRED FOR ALL 120V CIRCUITS.
2. RACEWAY FILL SHALL BE PER NEC CHAPTER 9. PROVIDE RACEWAY SIZE AND QUANTITY REQUIRED.
3. SEE DIMMER SCHEDULE SHEET E8.01 FOR RECEPTACLE TYPES.
4. PROVIDE DERATING OF CONDUCTORS PER NEC TABLE 310.15(B)(2)(a).
5. REFER TO SCHULER SHOOK DRAWINGS FOR LIGHTING SYSTEM CONTROL REQUIREMENTS. PROVIDE ALL RACEWAYS, BOXES, OUTLETS, CONNECTORS, EQUIPMENT, ETC. PER THEATRICAL LIGHTING CONSULTANT DRAWINGS.

THESE DRAWINGS, SPECIFICATIONS, AND OTHER DOCUMENTS, COLLECTIVELY THE "DOCUMENTS", INCLUDING WITHOUT LIMITATION ELECTRONIC VERSIONS THEREOF AND THE IDEAS, DESIGNS, AND ARRANGEMENTS REPRESENTED THEREBY, ARE AND SHALL REMAIN THE PROPERTY OF MARTINEZ+JOHNSON ARCHITECTURE PC. AS DEFINED BY APPLICABLE CONTRACTUAL AGREEMENTS (THE "AGREEMENTS") AND AS PROTECTED BY THE COPYRIGHT STATUTES OF THE UNITED STATES. USE OF THE DOCUMENTS SHALL BE STRICTLY LIMITED TO THE PROJECT FOR WHICH THEY WERE PREPARED AND DEVELOPED (THE "PROJECT") FOR THE TERM OF THE AGREEMENTS. NO PART OF THE DOCUMENTS SHALL BE COPIED, DISCLOSED TO OTHERS, OR USED IN CONNECTION WITH ANY OTHER WORK OR PROJECT, OR BY ANY OTHER PERSONS FOR ANY PURPOSES, OTHER THAN THE COMPLETION OF THE PROJECT, WITHOUT THE SPECIFIC WRITTEN AUTHORIZATION OF MARTINEZ+JOHNSON ARCHITECTURE PC. THE BORROWING, OPENING, OR VIEWING OF ELECTRONIC VERSIONS OF THE DOCUMENTS OR VISUAL CONTACT WITH ANY PRINTED FORM THEREOF SHALL CONSTITUTE CONCLUSIVE EVIDENCE OF ACCEPTANCE OF THESE RESTRICTIONS.


7502

| DATE:    | No.: | ISSUE:           |
|----------|------|------------------|
| 02.19.10 | 1    | PERMIT SET       |
| 04.02.10 | 2    | GMP CONTRACT SET |

| DATE:    | No.: | REVISION:    |
|----------|------|--------------|
| 11.11.10 |      | CONTRACT SET |

SHEET TITLE:  
THEATRE -  
ORCHESTRA LEVEL -  
THEATRICAL LIGHTING  
PLAN

**ETL-1.02**

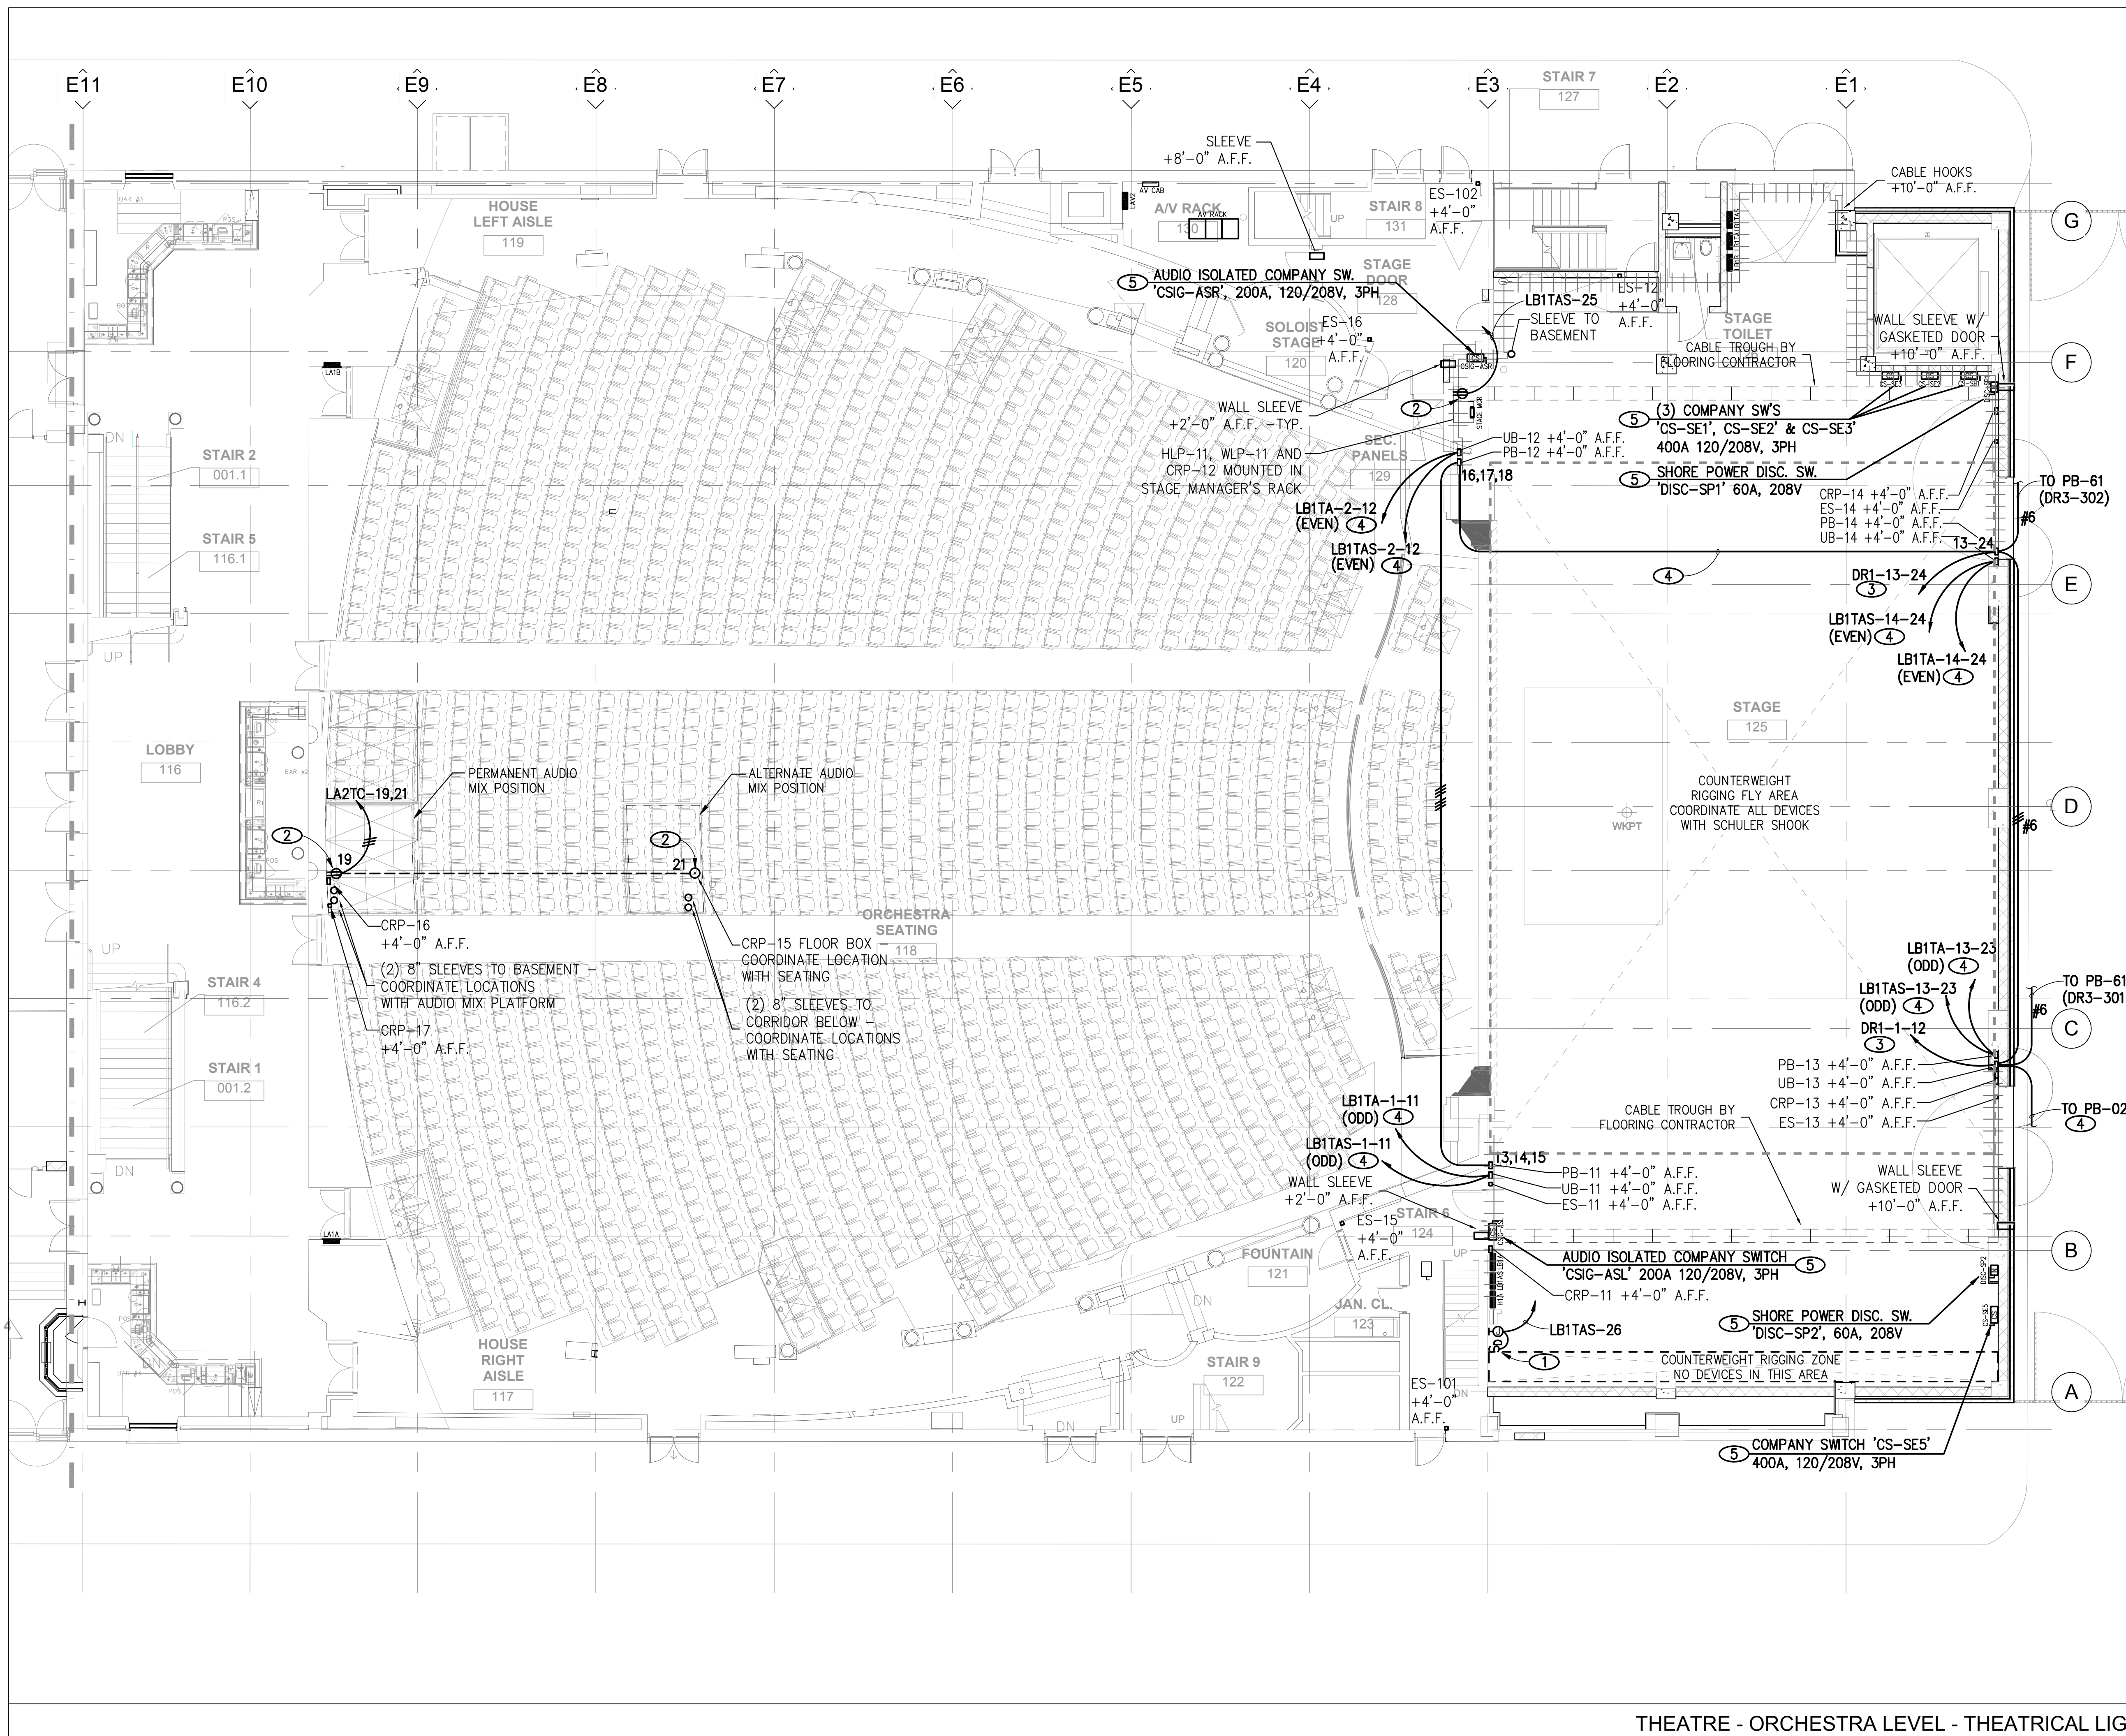

THEATRE - ORCHESTRA LEVEL - THEATRICAL LIGHTING PLAN

1/8" = 1'-0"

1

ISSUED FOR PERMIT

© 2010 M+J