


(DRAFTER - T.D.M.) DOES NOT ASSUME LIABILITY FOR ANY ERRORS OR OMISSIONS ON THESE PLANS. ALL INFORMATION MUST BE CONFIRMED PRIOR TO COMMENCEMENT OF CONSTRUCTION.

THESE DRAWINGS HAVE BEEN CHECKED TO INSURE A REASONABLE AND NORMALLY ACCEPTABLE DEGREE OF ACCURACY. HOWEVER, THE CONTRACTOR IS RESPONSIBLE FOR VERIFYING ALL DIMENSIONS, DETAILS, AND REQUIREMENTS OF THESE PLANS AND SPECIFICATIONS PRIOR TO THE START OF WORK.


REVISION:	
DATE:	9-5-97
FILE NO.:	RBA-97
DRAWN BY:	T. D. M.
CHECKED BY:	R. B. A.
JOB NO.:	BYTDM
SCALE:	AS SHOWN

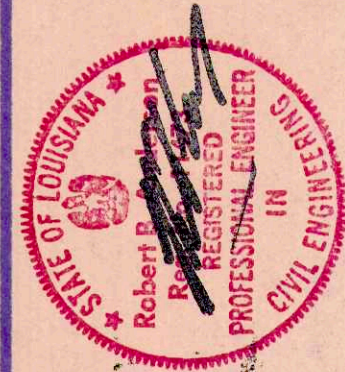

ROBERT B. ANDERSON
CONSULTING ENGINEERS, INC.
 1-800-476-0963
 432 N. ANTHONY STREET
 NEW ORLEANS, LA. 70119
 (504)-488-7797

PROJECT:
ELECTRICAL FLOOR PLAN
KASTNER RESIDENCE
ST. TAMMANY PARISH, LOUISIANA
FOR : MR. & MRS. RALPH KASTNER

SHEET No. **A-6**
 OF
 KASTNER5.DWG

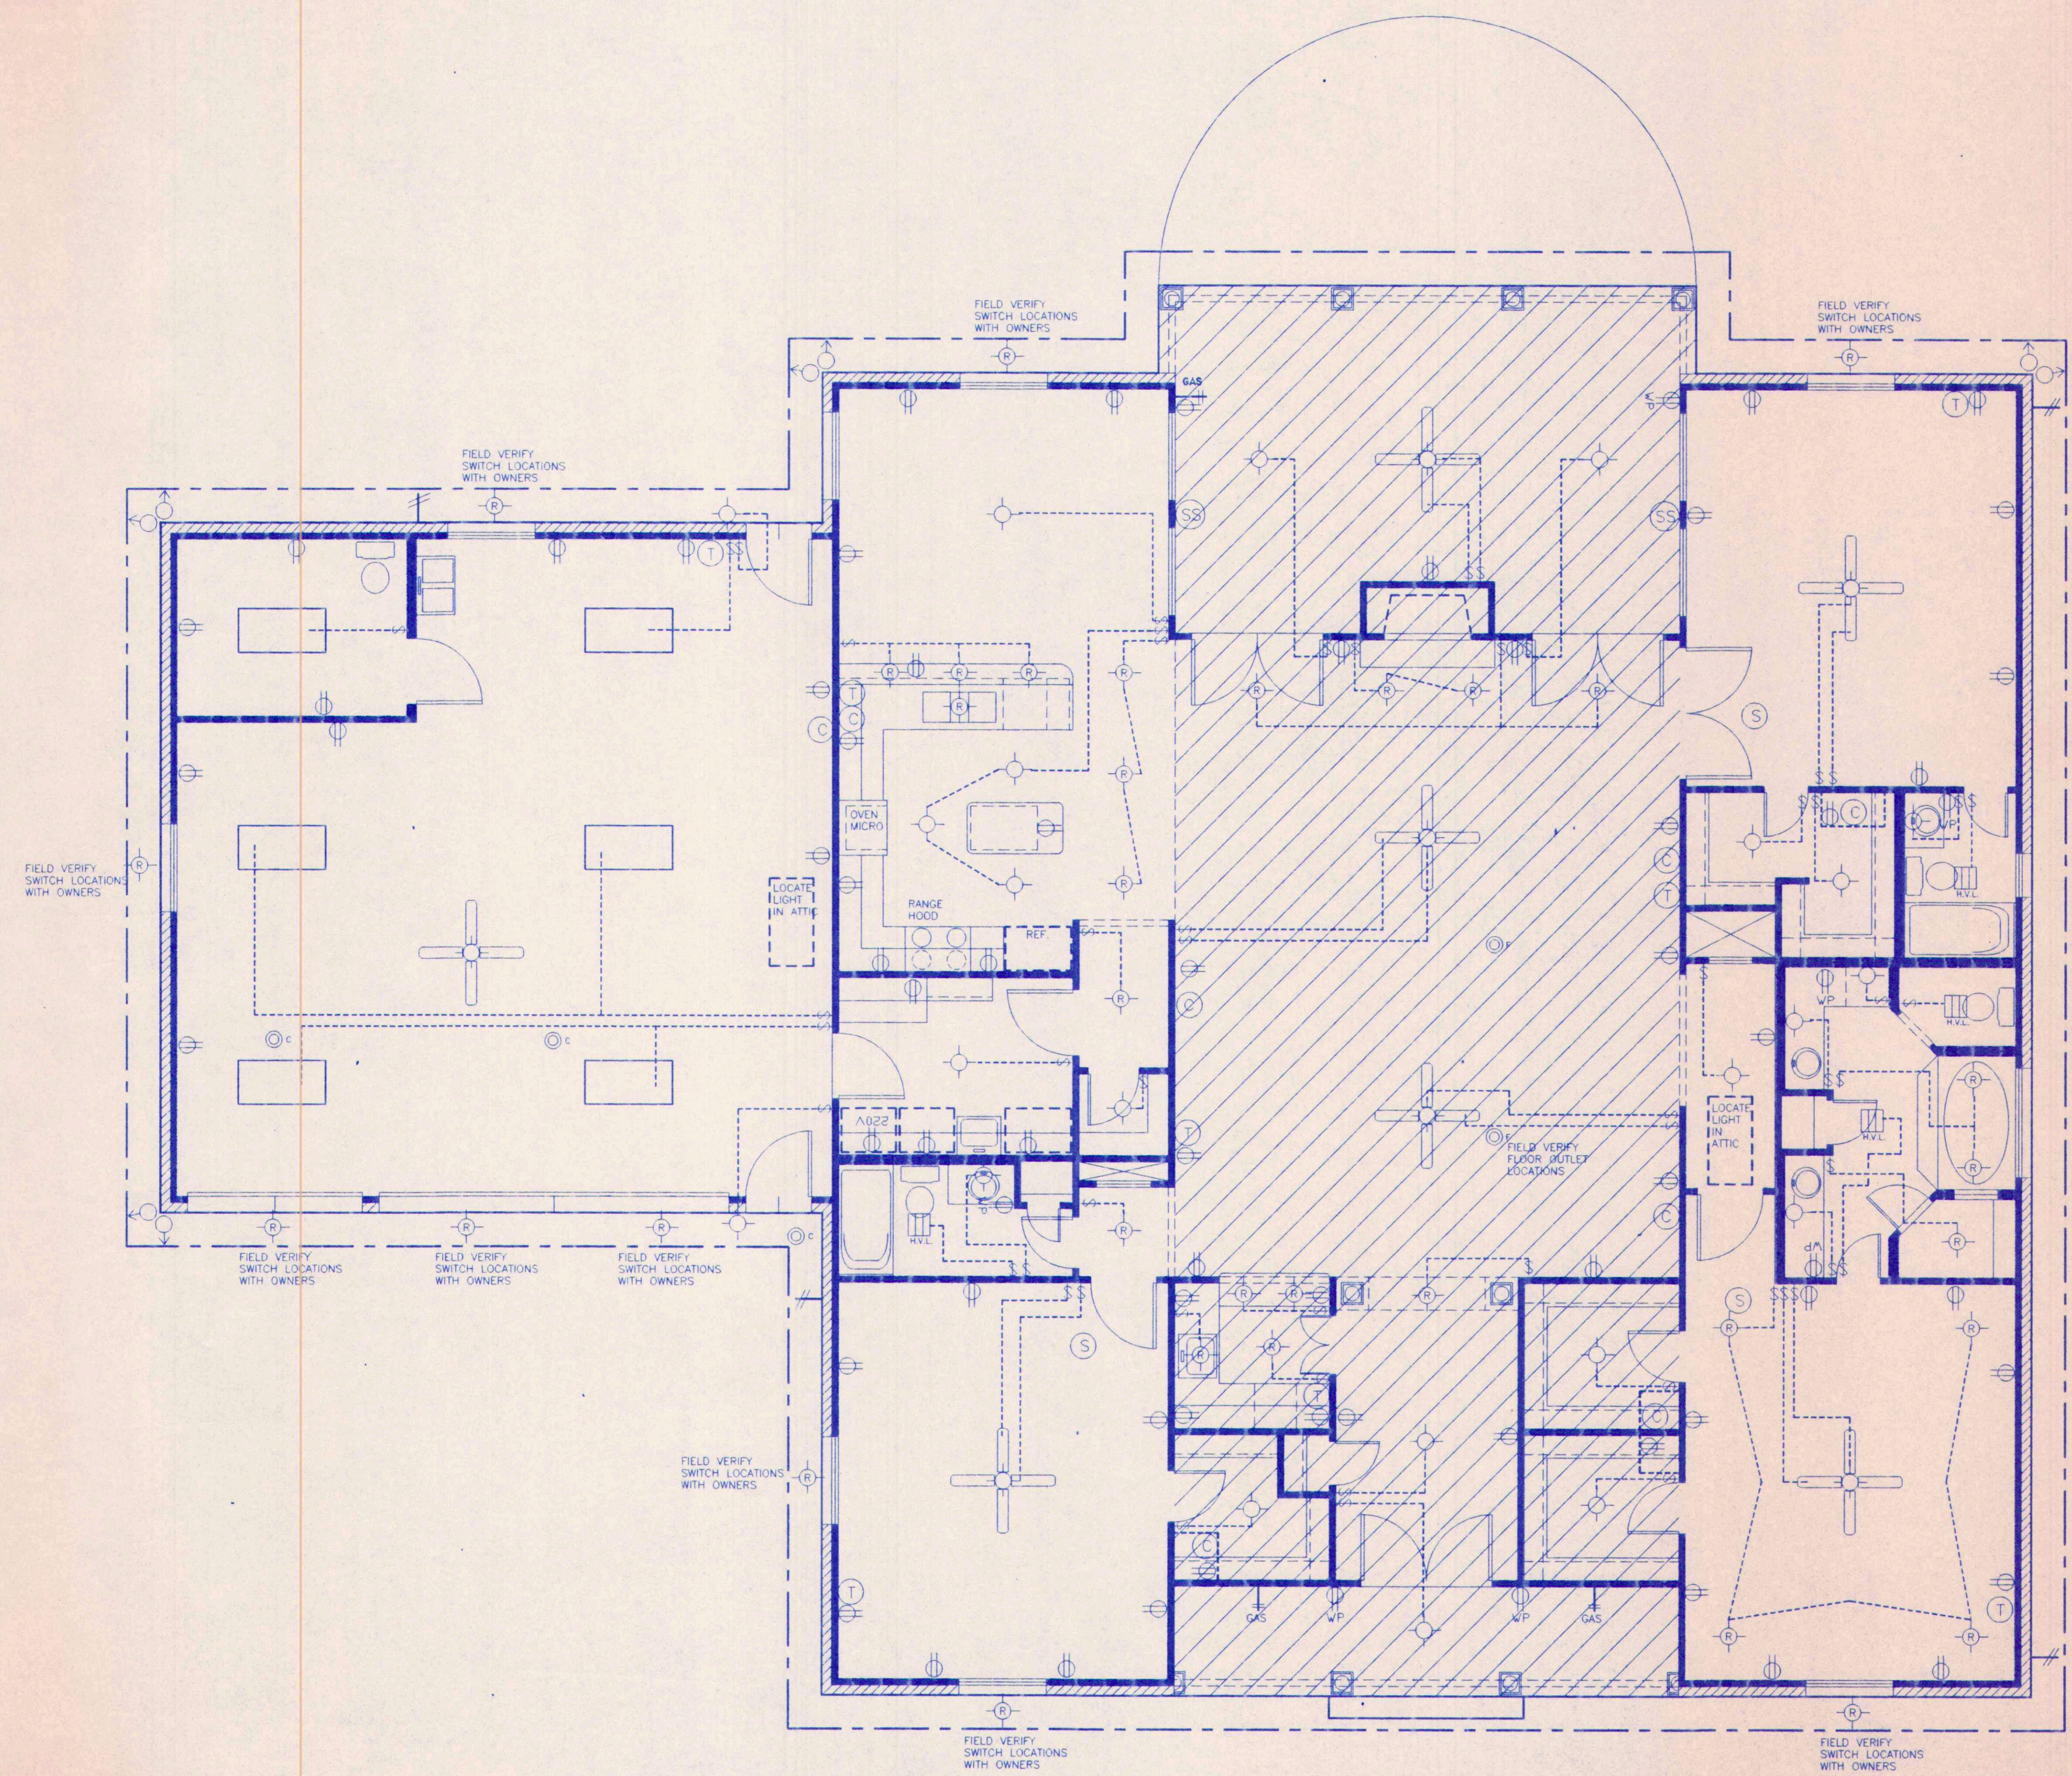

FLOODLIGHTS
 FIELD VERIFY
 SWITCH LOCATIONS
 WITH OWNERS.
 (TYPICAL)

ELECTRICAL SYMBOL LEGEND:

- (C) RECEPTACLE FOR CABLE T.V. HOOKUP.
- (SS) STEREO SPEAKER.
- (S) SMOKE DETECTOR.
- (H) HEAT DETECTOR.
- (T) TELEPHONE JACK
- (HVL) HEATER/VENT/LIGHT.
- (INT) INTERCOM
- (DRO) DUPLEX RECEPTACLE OUTLET.
- (WPDRO) WATERPROOF DUPLEX RECEPTACLE OUTLET.
- (220V) 220 VOLT RECEPTACLE OUTLET.
- (FO) FLOOR RECEPTACLE OUTLET.
- (CO) CEILING RECEPTACLE OUTLET.
- (S) SWITCH.
- (S3) THREE-WAY SWITCH.
- (SR) SWITCH WITH RHEOSTAT.
- (L) LIGHTING FIXTURE.
- (RL) RECESSED LIGHTING FIXTURE.
- (FL) FLUORESCENT LIGHT FIXTURE.
- (DF) DOUBLE FLOODLIGHTS.
- (DFP) DOUBLE FLOODLIGHTS WITH PHOTOCELL.
- (CF) CEILING FAN WITH LIGHTING FIXTURE.

ELECTRICAL FLOOR PLAN
 SCALE : 1/4" = 1'-0"