



FLOOR PLAN
SCALE: 1/4" = 1'-0"


10' Ceiling Height

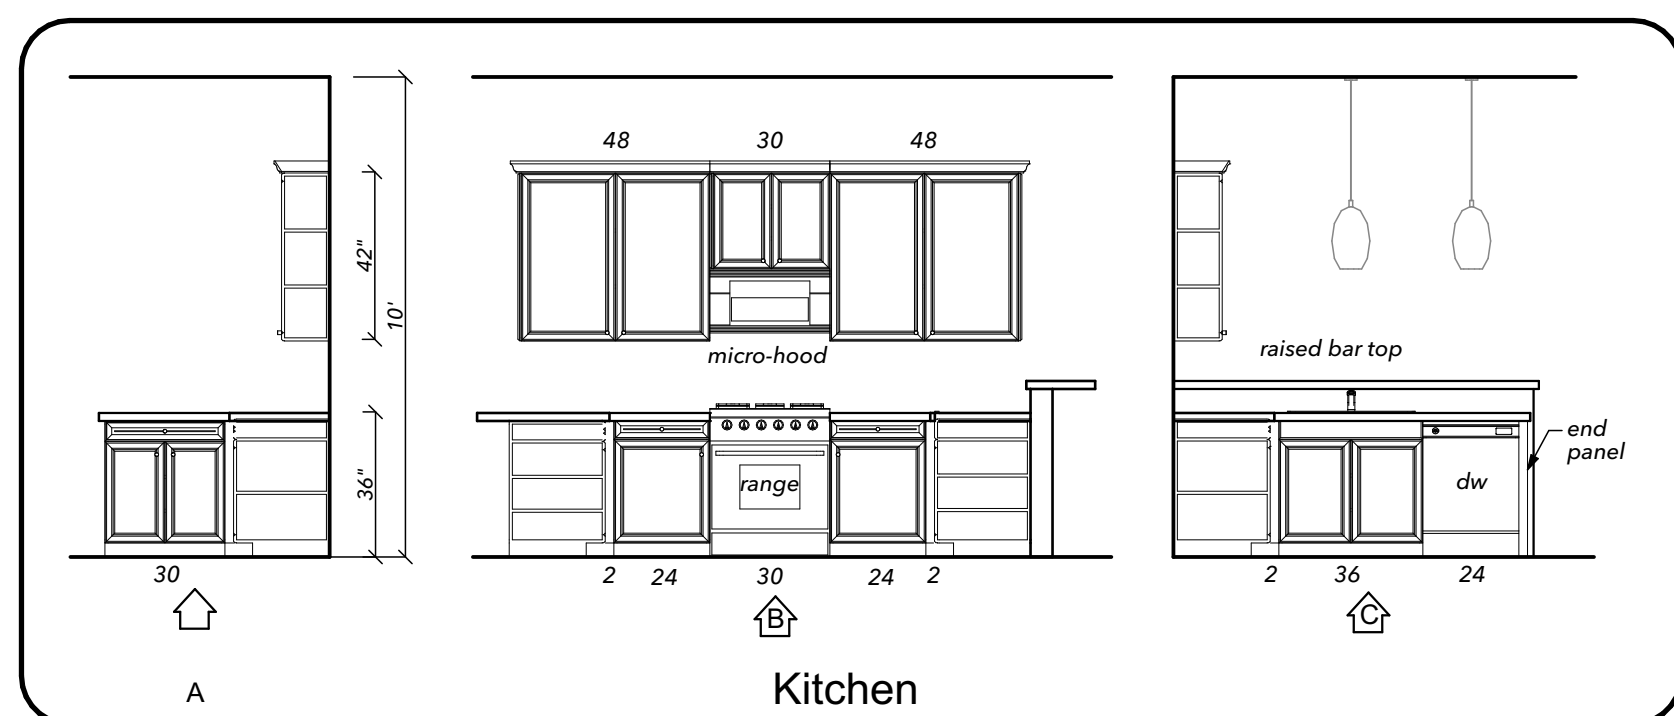

Cabinet Details
Scale: 1/4" = 1'-0"


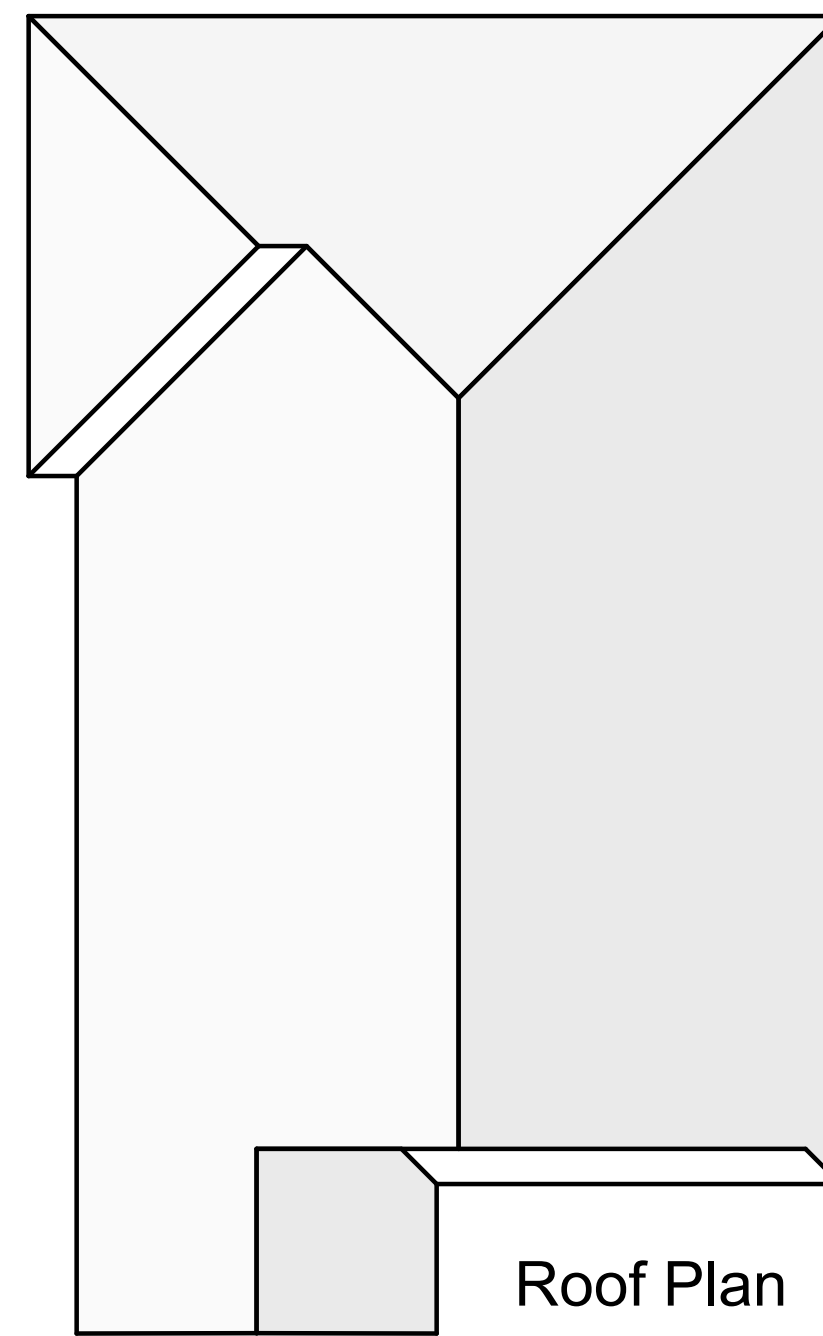


Roof Plan
SCALE: 1/8" = 1'-0"

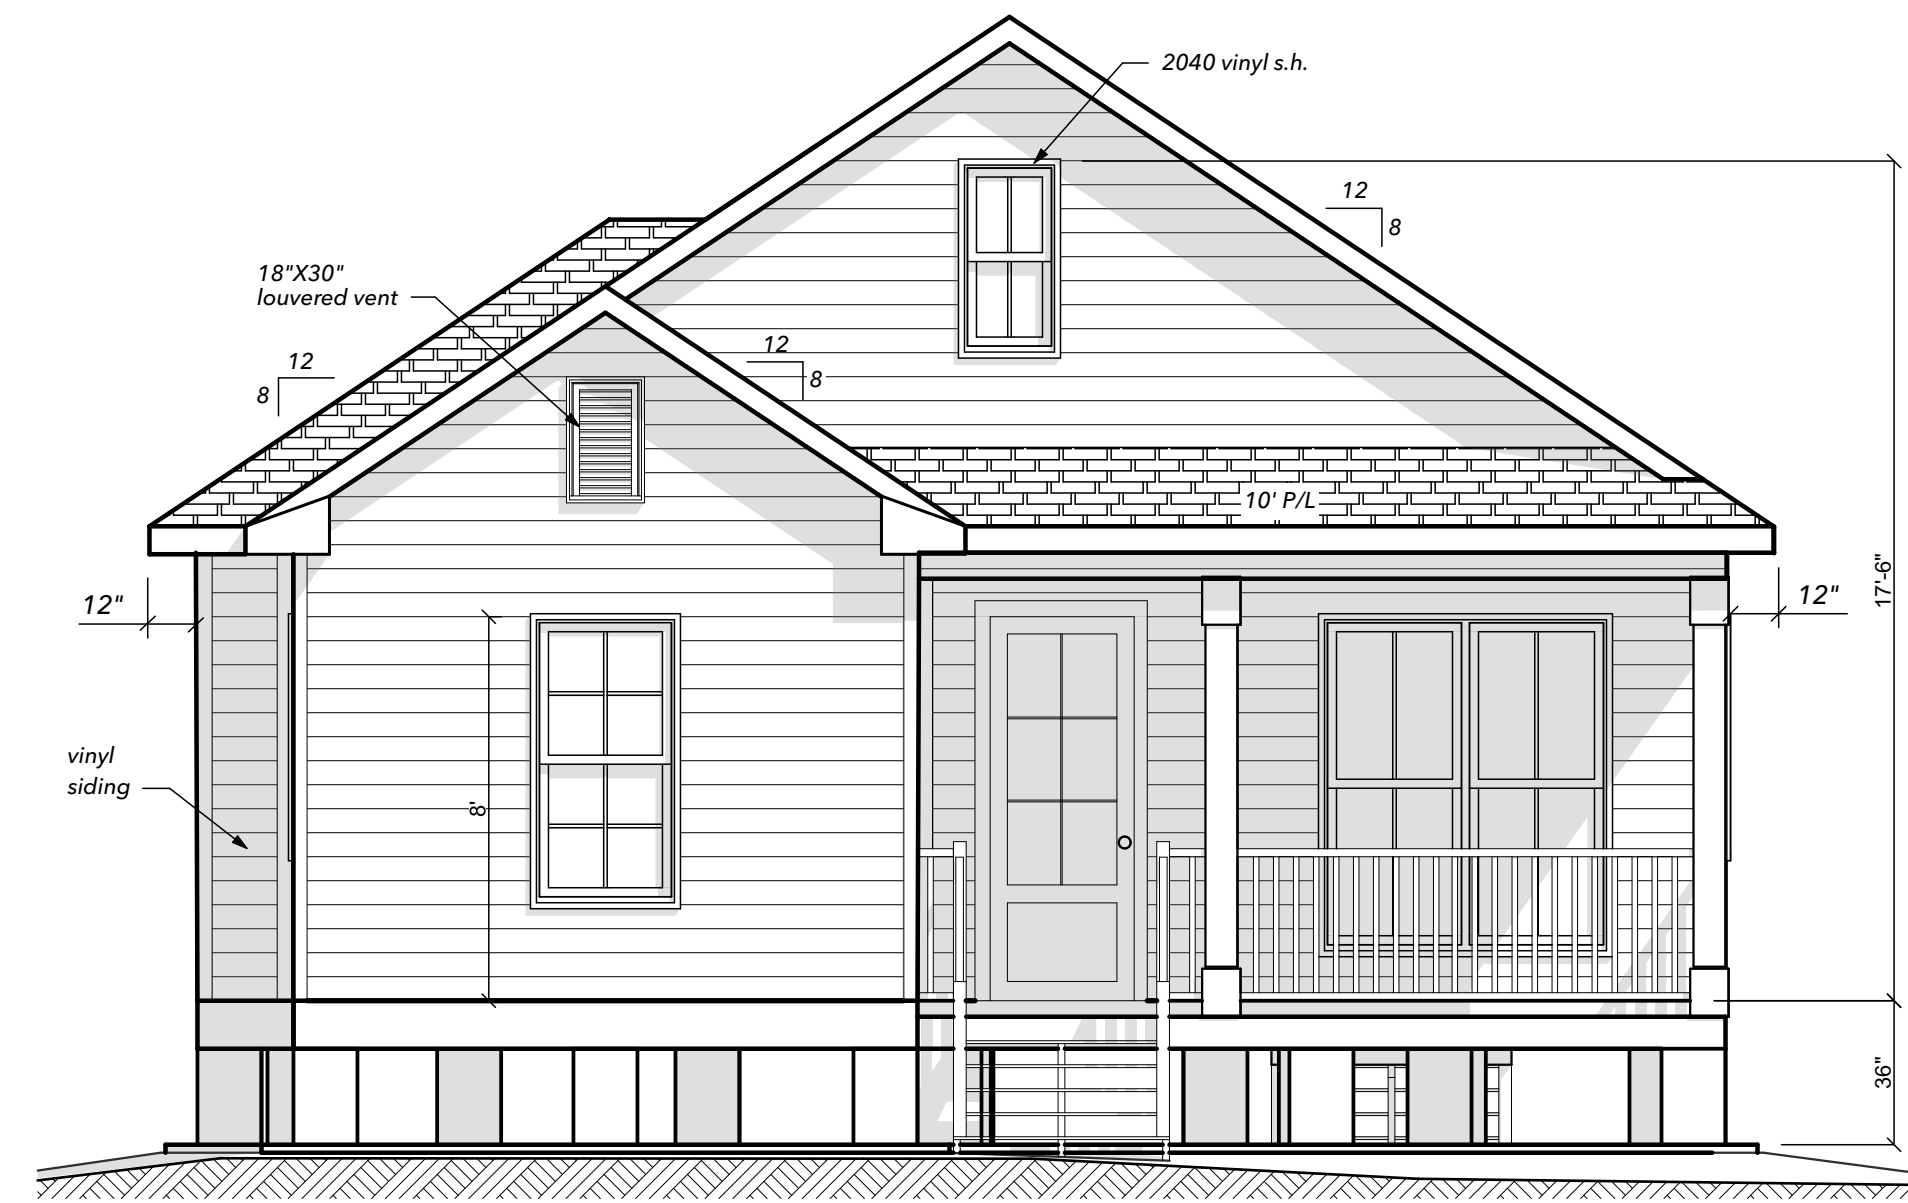

Front Elevation
SCALE: 1/4" = 1'-0"


Note:
Plans are shown for illustration purposes only.
See foundation plan by others for pier/piling size, spacing, and specifications.

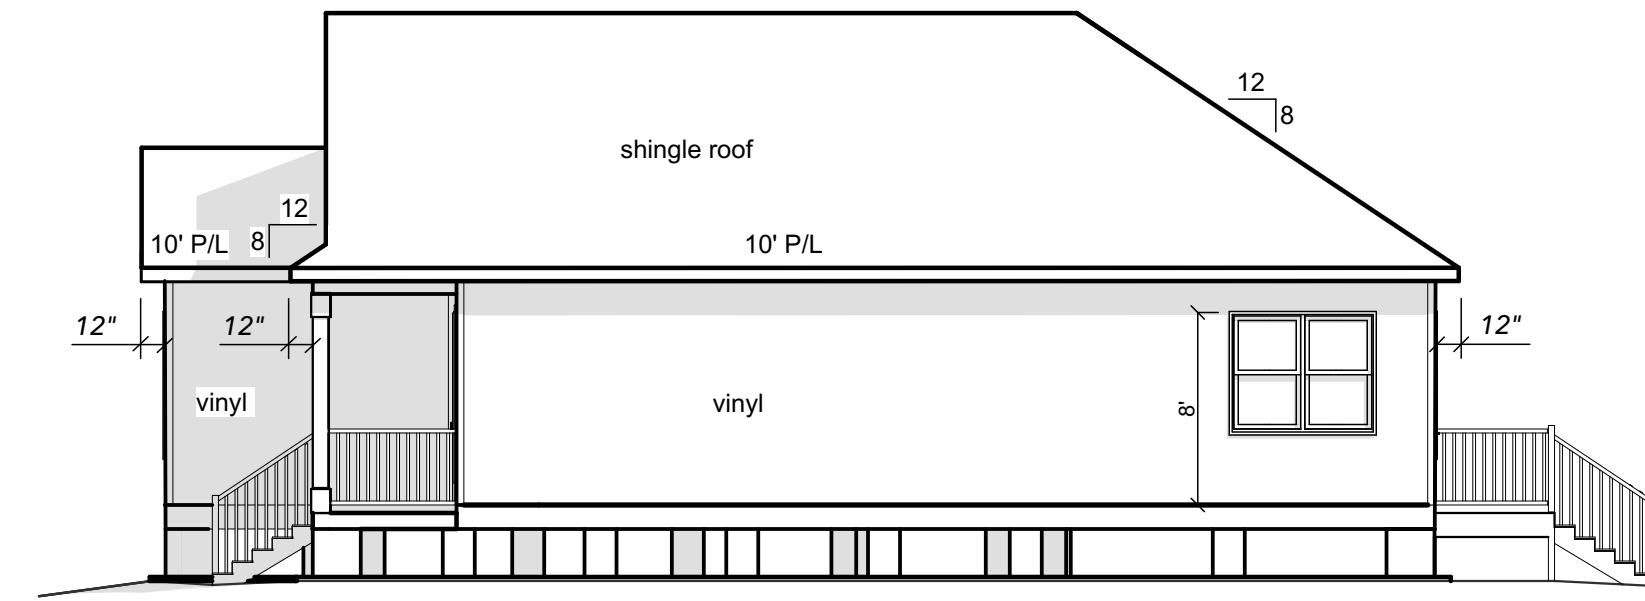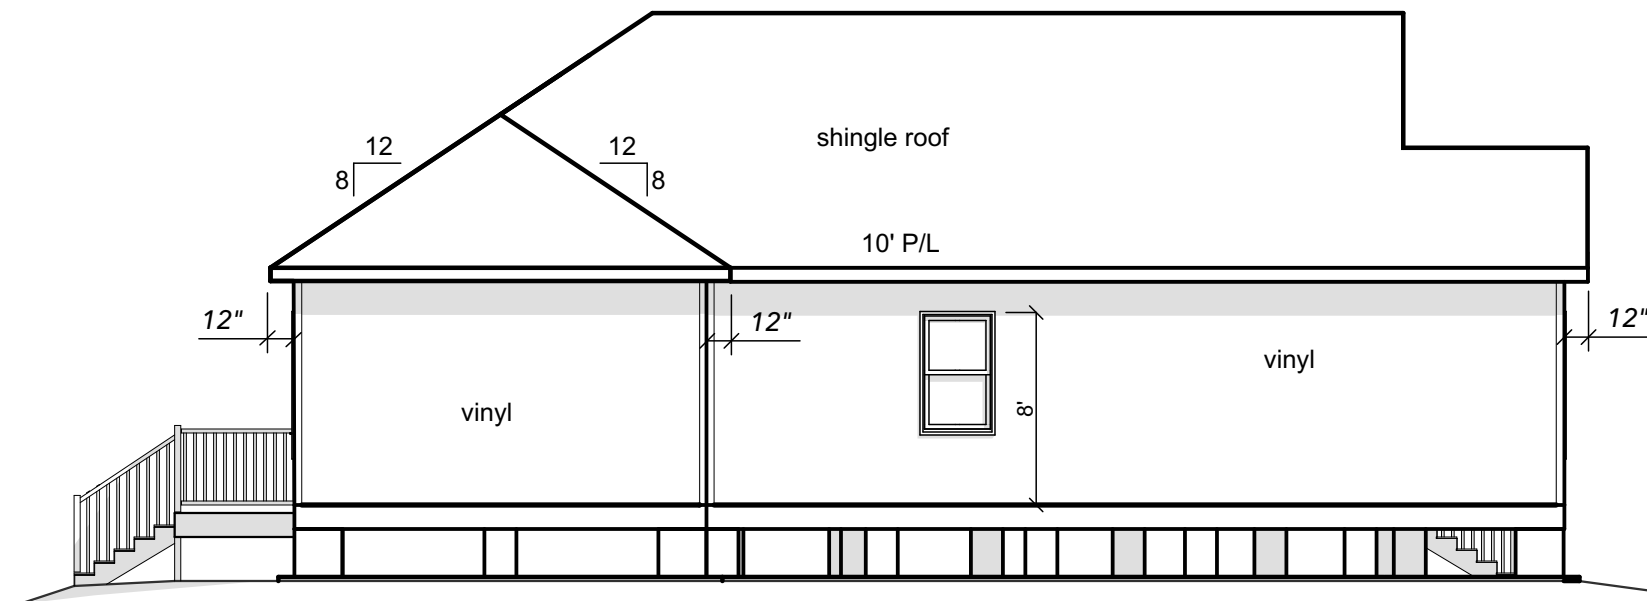

3D Elevation A
NOT TO SCALE



3D Elevation B
NOT TO SCALE

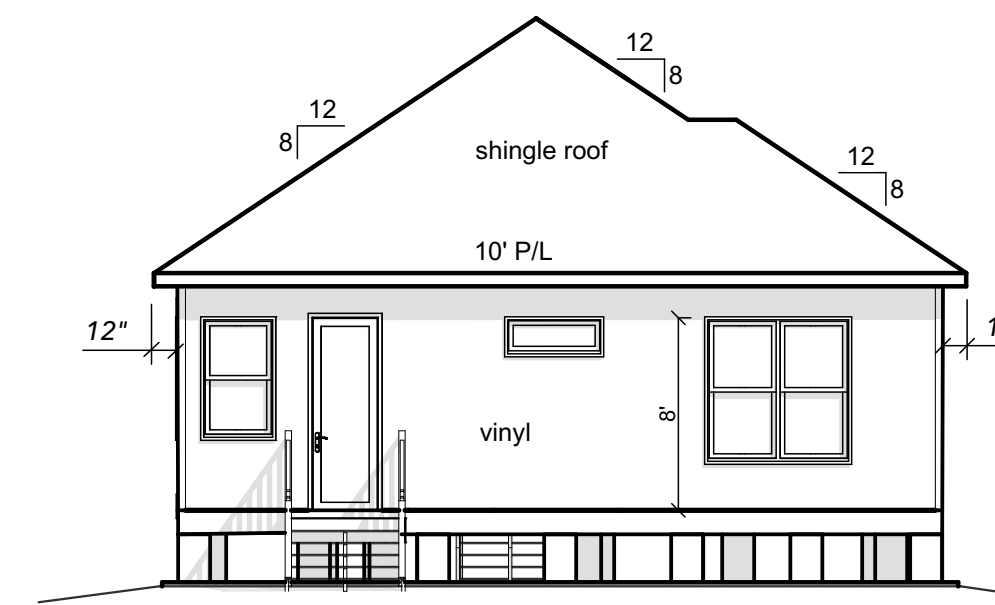

**SOUTHERN COUNTRY
DESIGNS, LLC.**
"Where the American Dream Begins"
985-624-8390
email: southerncountrydesigns@gmail.com

THESE DRAWINGS OR ANY OF ITS CONTENTS MAY NOT BE REPRODUCED OR USED WITHOUT AUTHORIZATION AND WRITTEN PERMISSION FROM SOUTHERN COUNTRY DESIGNS, LLC. AND IS THE EXCLUSIVE PROPERTY OF SOUTHERN COUNTRY DESIGNS, LLC.

Plans for:
Laurent Construction
Lot 13A, Bar Street
St. Tammany Parish, La.

I am sealing these plans for compliance with the IRC 2015 building code for structure design for the 130 MPH, 3 second burst wind load.

Del Caldwell Civil Engineer

Note:
Although every effort has been made in preparing these plans, the contractor must check all details and dimensions and be responsible same.

PROJECT NO: 5537
DATE: 5/20/21
DRAWN BY: HWM

SHEET TITLE

FLOOR PLAN

A1

Electrical Legend	
	Fan/light
	Light Fixture
	Heat, Vent, Light
	Vent, Light
	Receptacle, WP (weather proof)
	LED Disc Light
	Flood Light
	Single Switch
	3 Way, 4 way Switch
	TV
	CATV
	Smoke/ Carbon Monoxide Detector

Total Living.....	1408 sq. ft.
Front Porch.....	101 sq. ft.
Under beam.....	1509 sq. ft.

Door Schedule				
ID	SIZE		DESCRIPTION	Quantity
	WIDTH	HEIGHT		
1	3'	8'	Owner's choice	1
2	2'-8"	6'-8"	2 Panel Masonite Int.	4
2	2'-8"	6'-8"	2 Panel Masonite Solid Core	1
3	2'-4"	6'-8"	2 Panel Masonite Int.	2
4	2'	6'-8"	2 Panel Masonite Int.	4
5	4'	6'-8"	2 Panel Masonite Int.	1
6	5'	6'-8"	2 Panel Masonite bifold	1
7	2'-8"	8'	1 Lite Fiberglass Ext.	1



3D Kitchen View
NOT TO SCALE