


HVAC SYSTEM REPLACEMENT  
 STATE POLICE TROOP L HEADQUARTERS  
 2600 N CAUSEWAY BLVD  
 MANDEVILLE, LOUISIANA  
 PROJECT NO.: 01-107-06B-11, F.01003807  
 STATE ID: S00814 SITE CODE: 1-52-004



**TROOP L**  
 STATE OF LOUISIANA  
 JOHN BEL EDWARDS  
 GOVERNOR

DIVISION OF ADMINISTRATION  
 JAY DARDENNE  
 COMMISSIONER OF ADMINISTRATION

OFFICE OF FACILITY PLANNING AND CONTROL  
 MARK MOSES  
 DIRECTOR

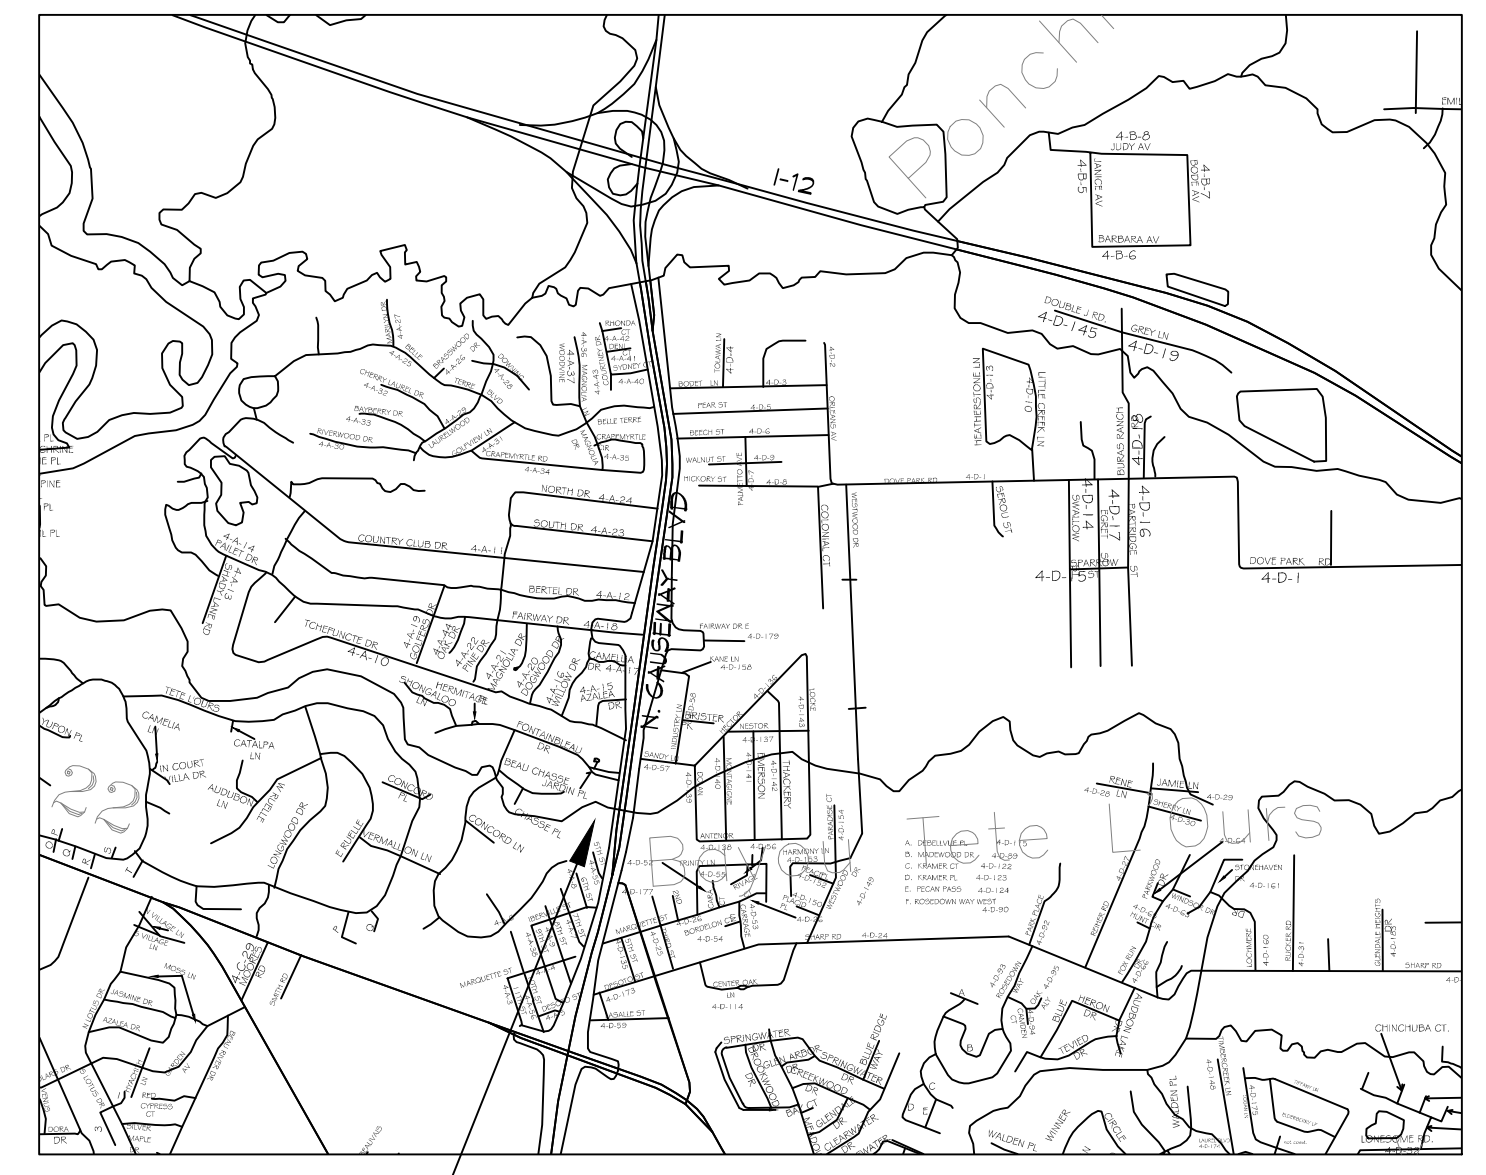

AREA OF WORK  
 VICINITY MAP  
 N.T.S.

INDEX OF DRAWINGS			
SHT#	DWG#	DRAWING NAME	REVISED
1	CS	COVERSHEET	
2	D101	MECHANICAL DEMO PLAN	
3	M101	MECHANICAL ZONES PLAN	
4	M102	MECHANICAL PLAN	
5	M102A	MECHANICAL PLAN WEST	
6	M102B	MECHANICAL PLAN EAST	
7	M102C	MECHANICAL DETAILS	
8	M103	HVAC DETAILS	
9	E101	ELECTRICAL PLAN	

**DAMMON**  
 ENGINEERING, INC.  
 LOUISIANA & MISSISSIPPI  
 Chief Engineer: Brian Mitchell, PE  
 554 Old Spanish Trail  
 Slidell, LA 70458  
 www.dammonengineering.com  
 info@dammonengineering.com  
 PH: 985.649.5832

#	DESCRIPTION	REVISIONS	DATE

SEAL:

HVAC SYSTEM REPLACEMENT  
 PROJECT NO.: 01-107-06B-11, F.01003807  
 STATE POLICE TROOP L  
 HEADQUARTERS  
 2600 N CAUSEWAY BLVD, MANDEVILLE, LA 70411  
 STATE ID: S00814 SITE CODE: 1-52-004  
 JOB No: 2573 DATE: 7/25/2019  
 DRAWN BY: DFPD CHECKED BY: BM

SHEET TITLE:  
 COVER SHEET

DRAWING NUMBER:  
**CS**