

ROOF PLAN LEGEND


- METAL ROOFING:
MANUFACTURER: AEP SPAN
STYLE: STANDING SEAM
COLOR: TBD
- 5" PER 12" **SLOPE OF ROOF**

FLOOR PLAN LEGEND


- KEYNOTE
- REVISION CLOUD
AND DELTA
- wall type W24B **WALL TYPE INDICATOR -
REFER TO SHEET G-002**
- 0" AFF **ELEVATION/HEIGHT
INDICATOR**
- 4 **DOOR NUMBER**
- B **WINDOW TYPE**
- office
101 **ROOM NAME
ROOM NUMBER**
- PLUMBING FIXTURES**
- WH **WATER HEATER**

**REFLECTED CEILING PLAN
LEGEND**


- 5/8" GYPSUM BOARD CEILING
WITH PAINTED EPOXY FINISH
- PERFORATED CEMENTITIOUS HARDIE
SOFFIT BOARDS WITH 1X2 BATTENS
AT EACH SEAM.
- 8'-0" AFF **INDICATES HEIGHTS AS REQUIRED**
- RECESSED EXTERIOR GRADE
LED CAN - 7"**
- 2X4 SURFACE MOUNTED LED
FIXTURE**

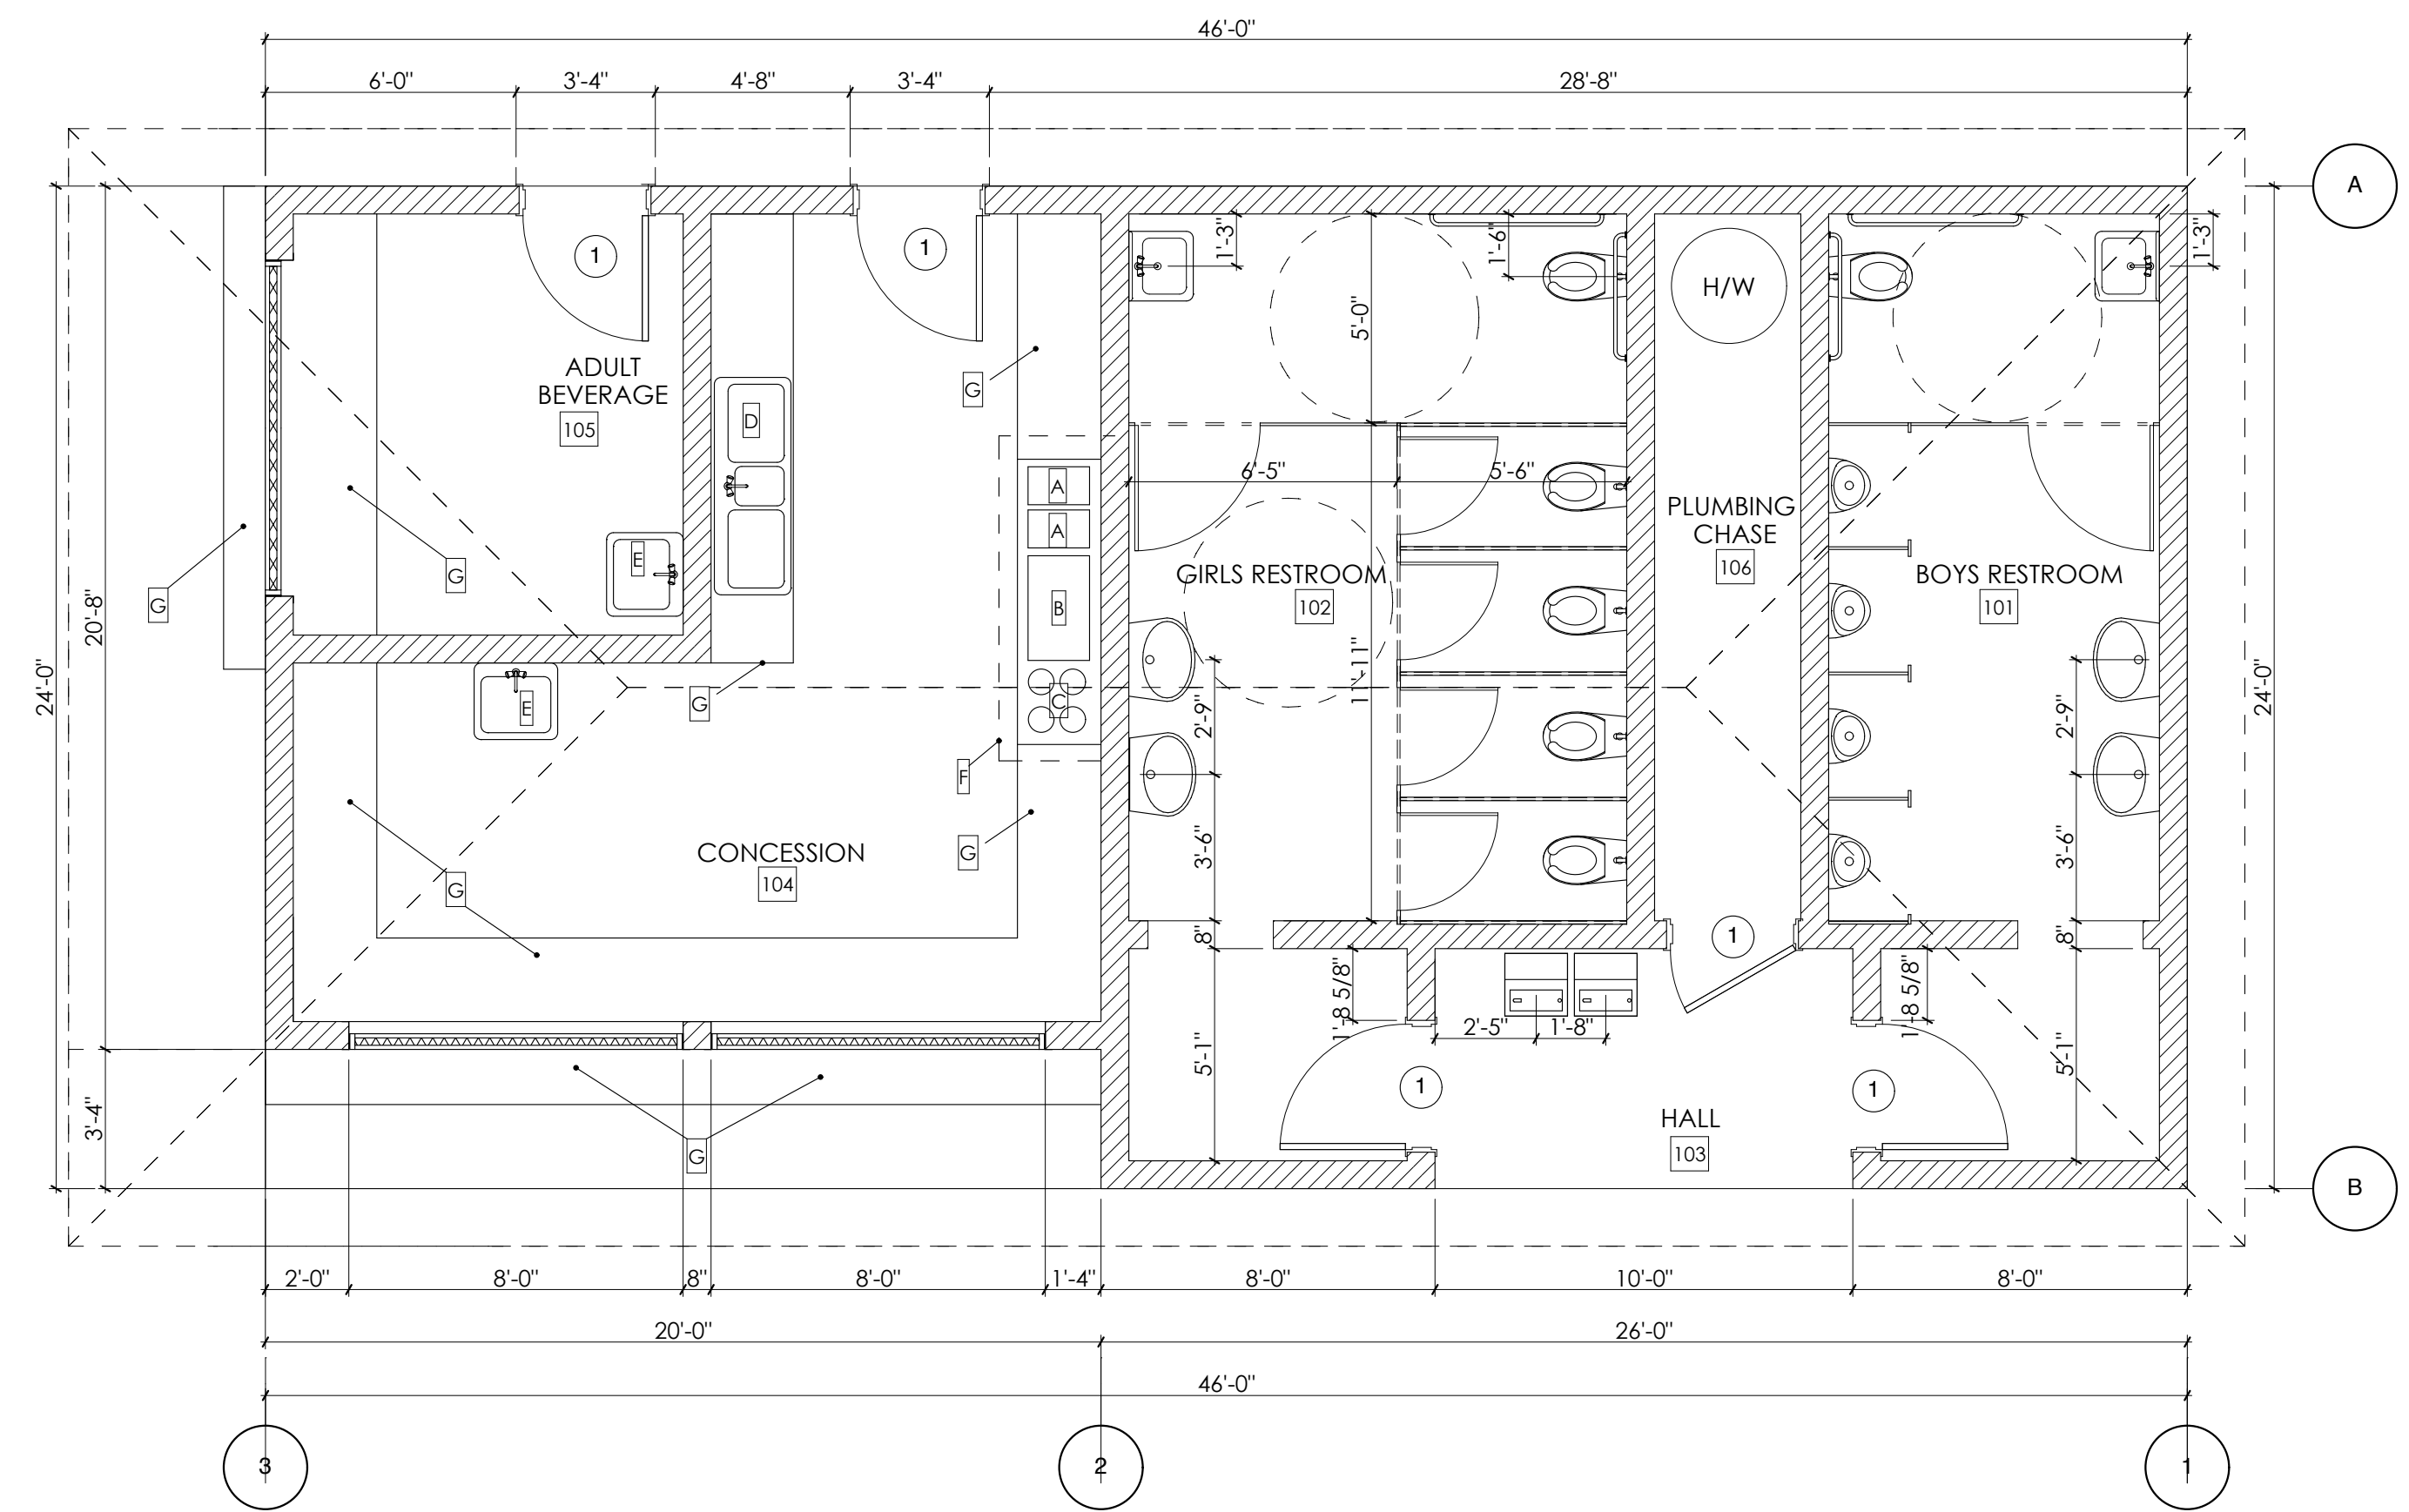

FIRST FLOOR PLAN
SCALE: 1/4" = 1'-0"

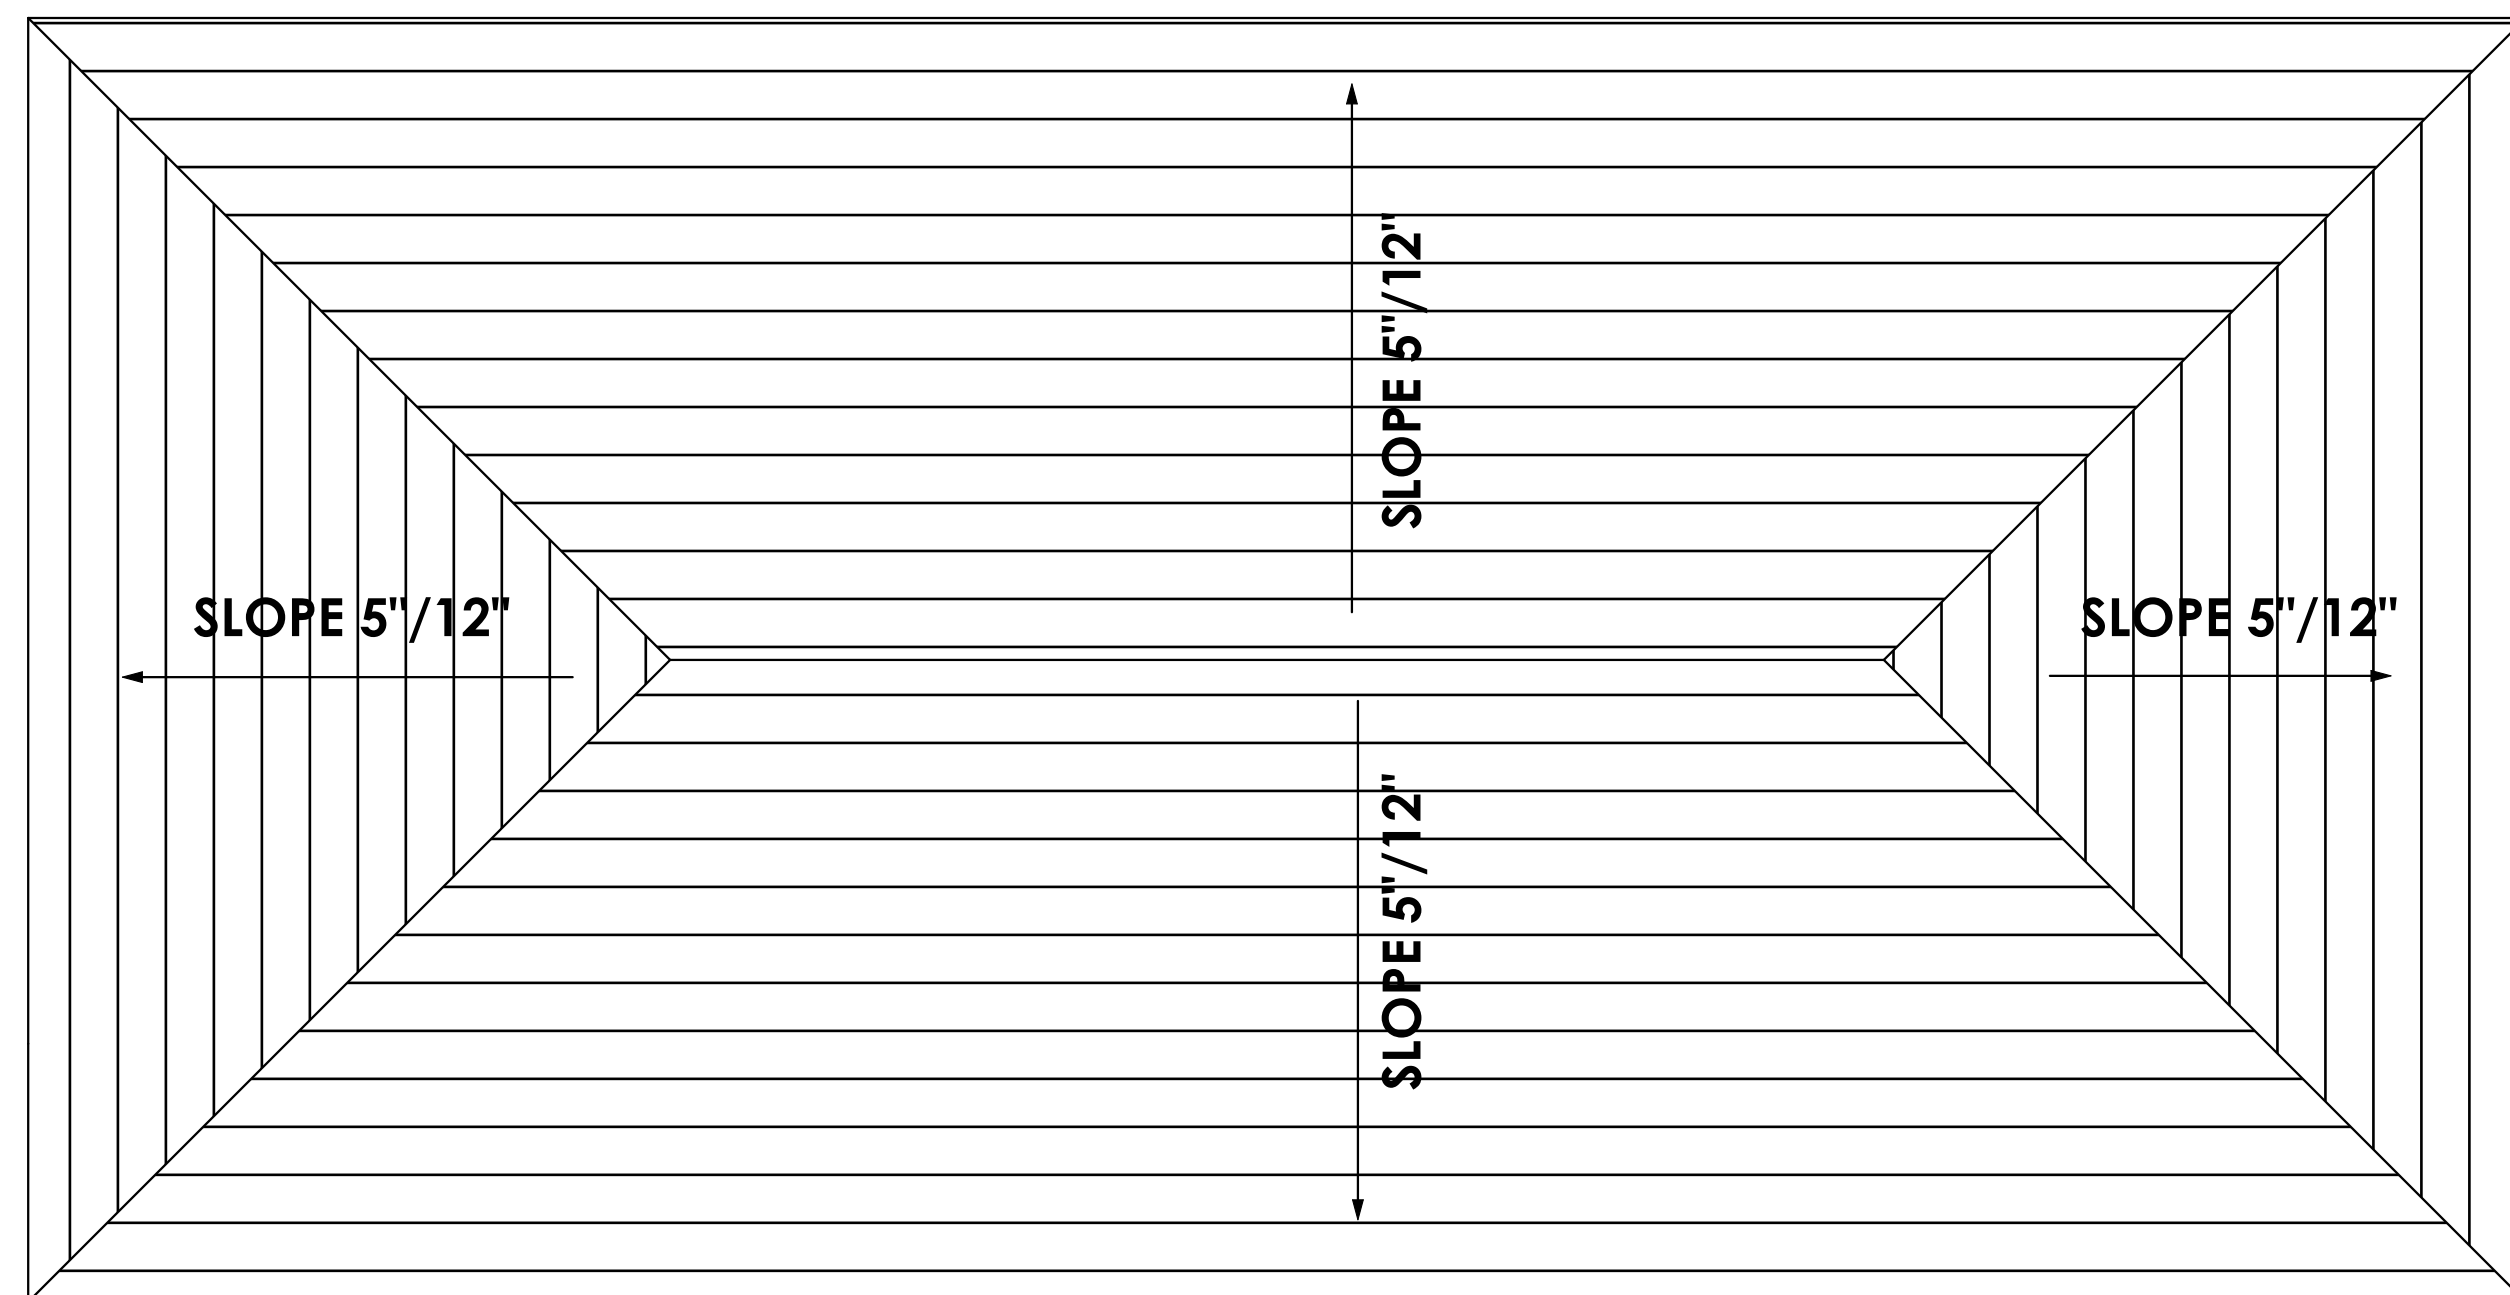

ROOF PLAN
SCALE: 1/4" = 1'-0"

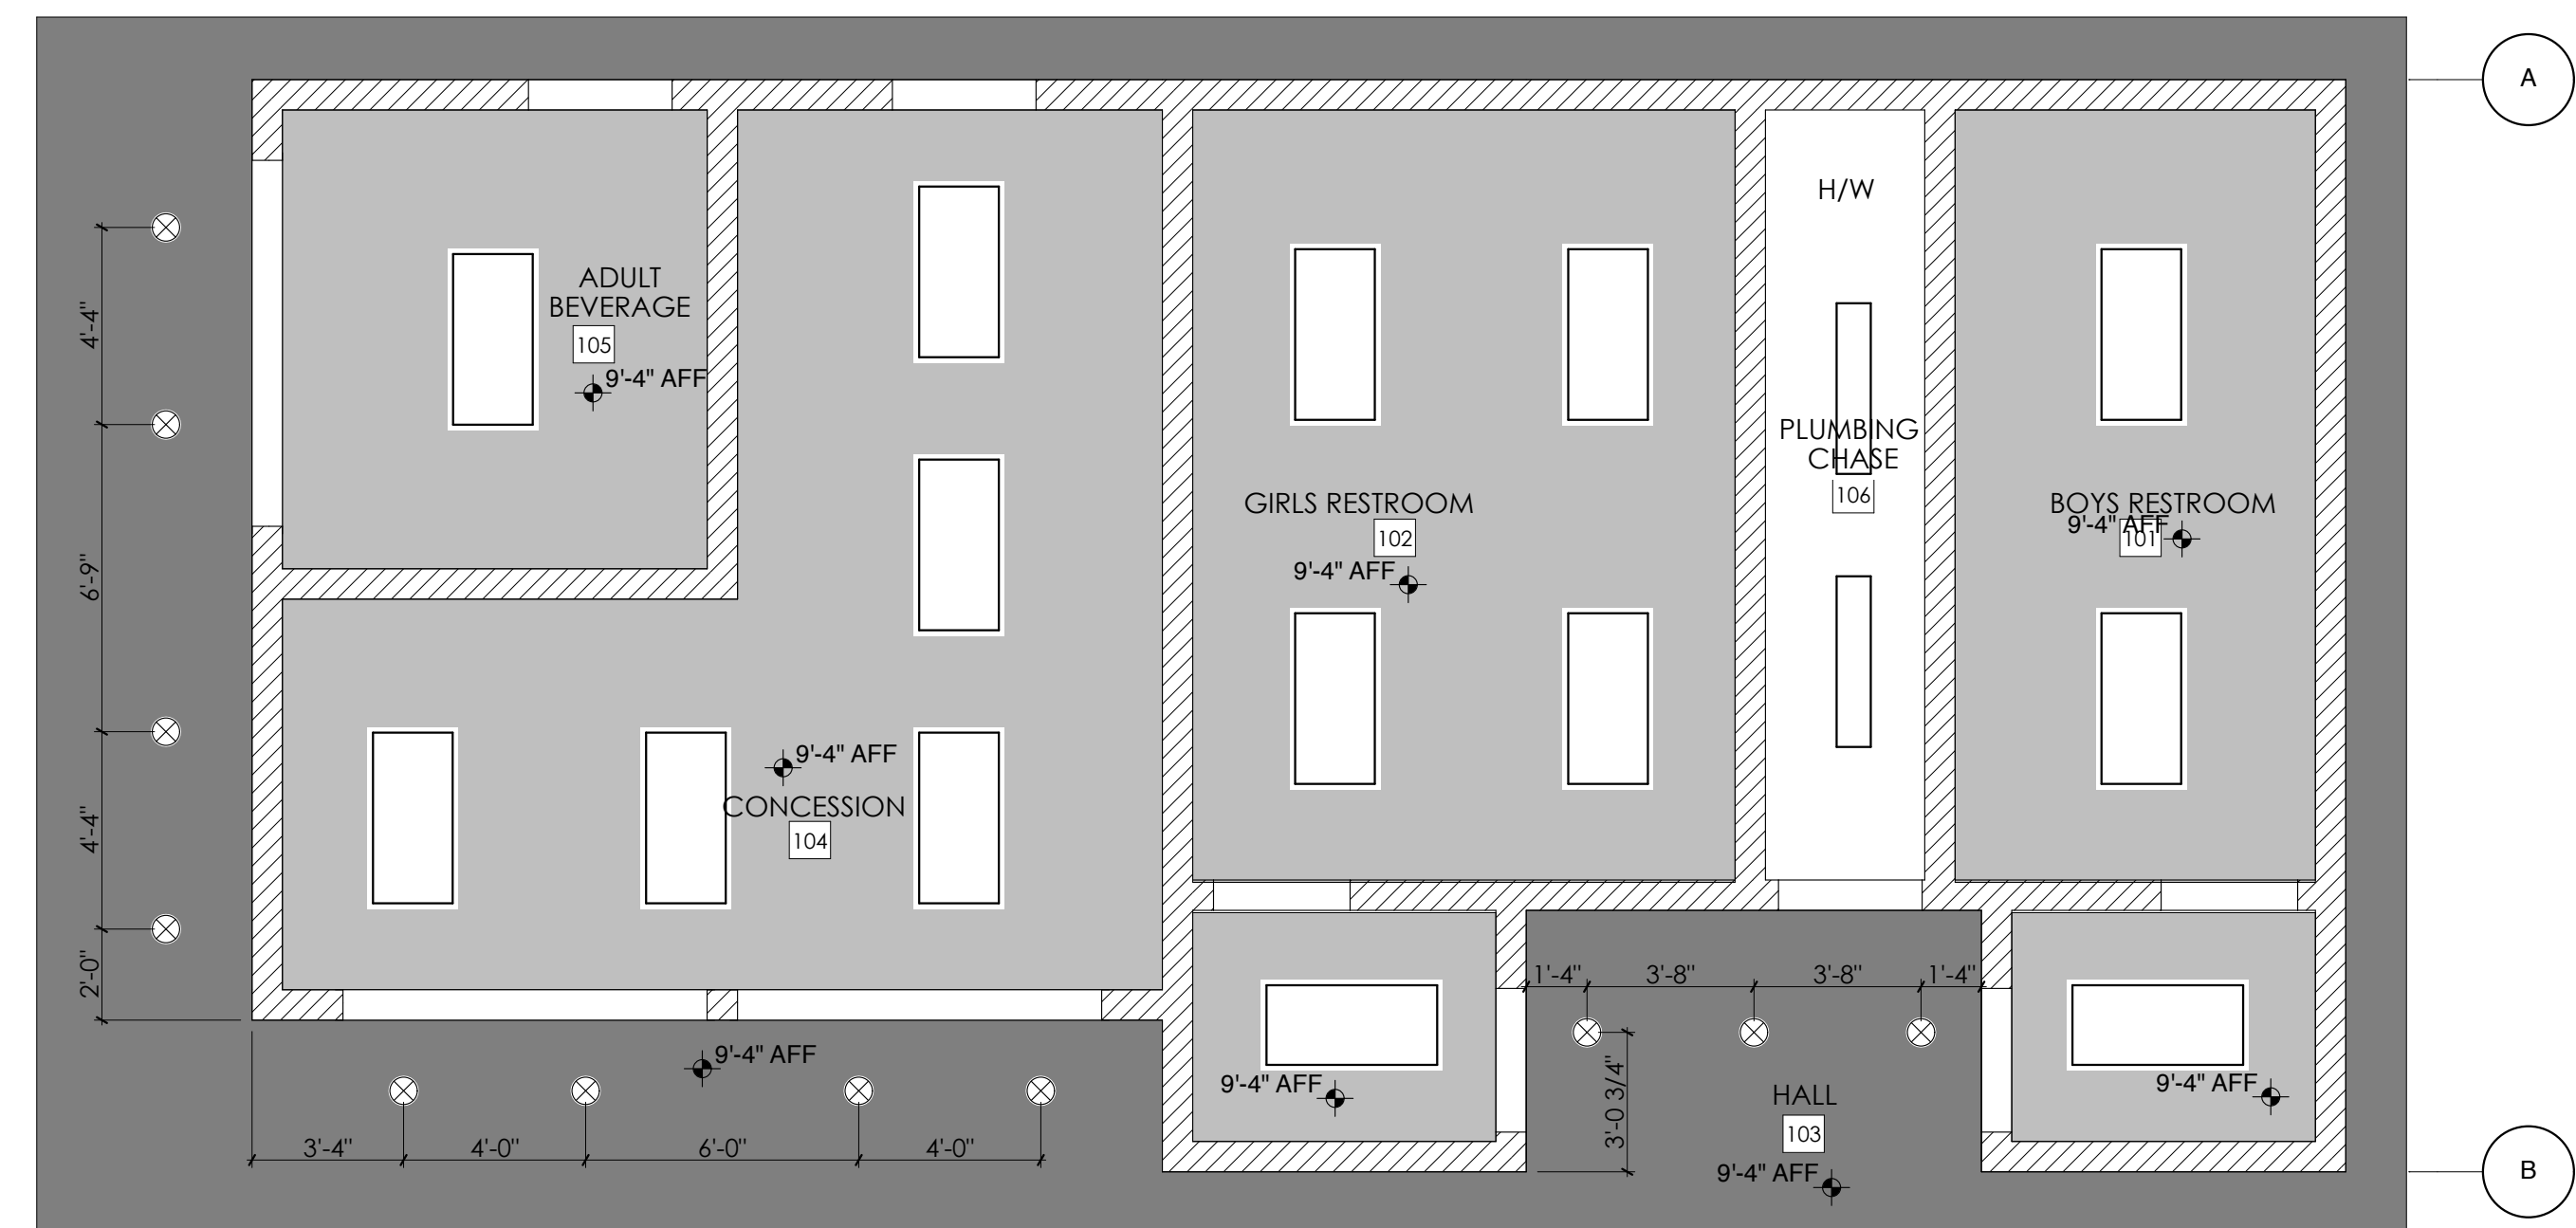

FIRST FLOOR RCP
SCALE: 1/4" = 1'-0"