




1 ELECTRICAL PLAN
SCALE: 1/8" = 1'-0"
NORTH

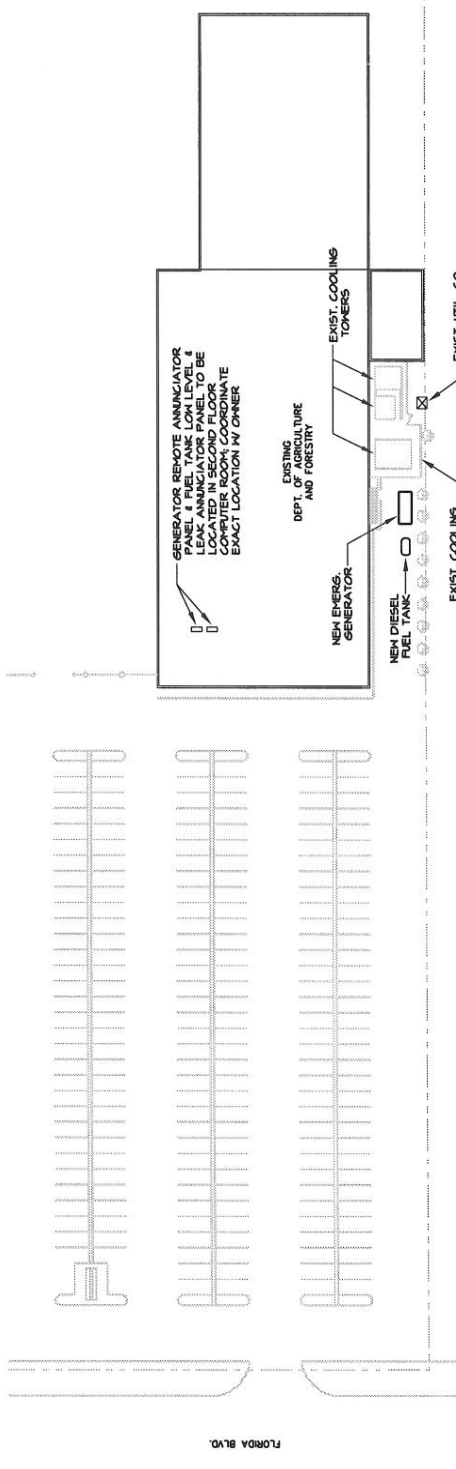

2 SITE PLAN
SCALE: 1" = 50'-0"
NORTH

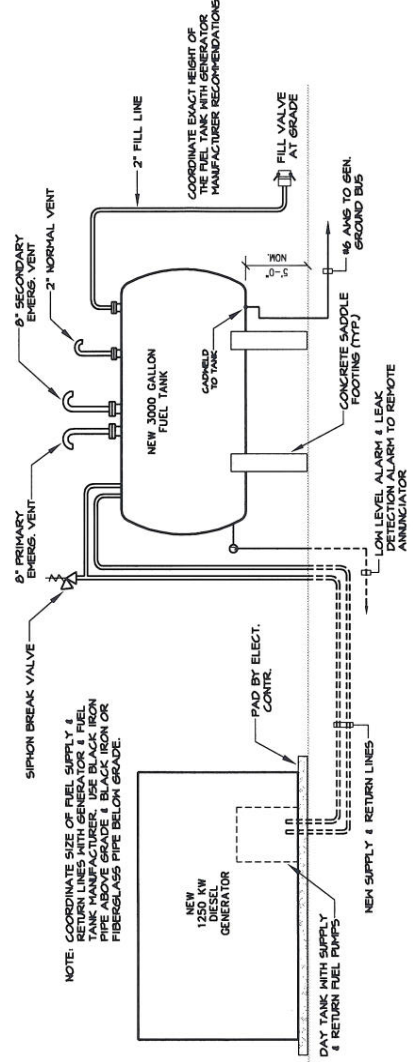

3 GENERATOR FUEL SYSTEM DETAIL
NOT TO SCALE

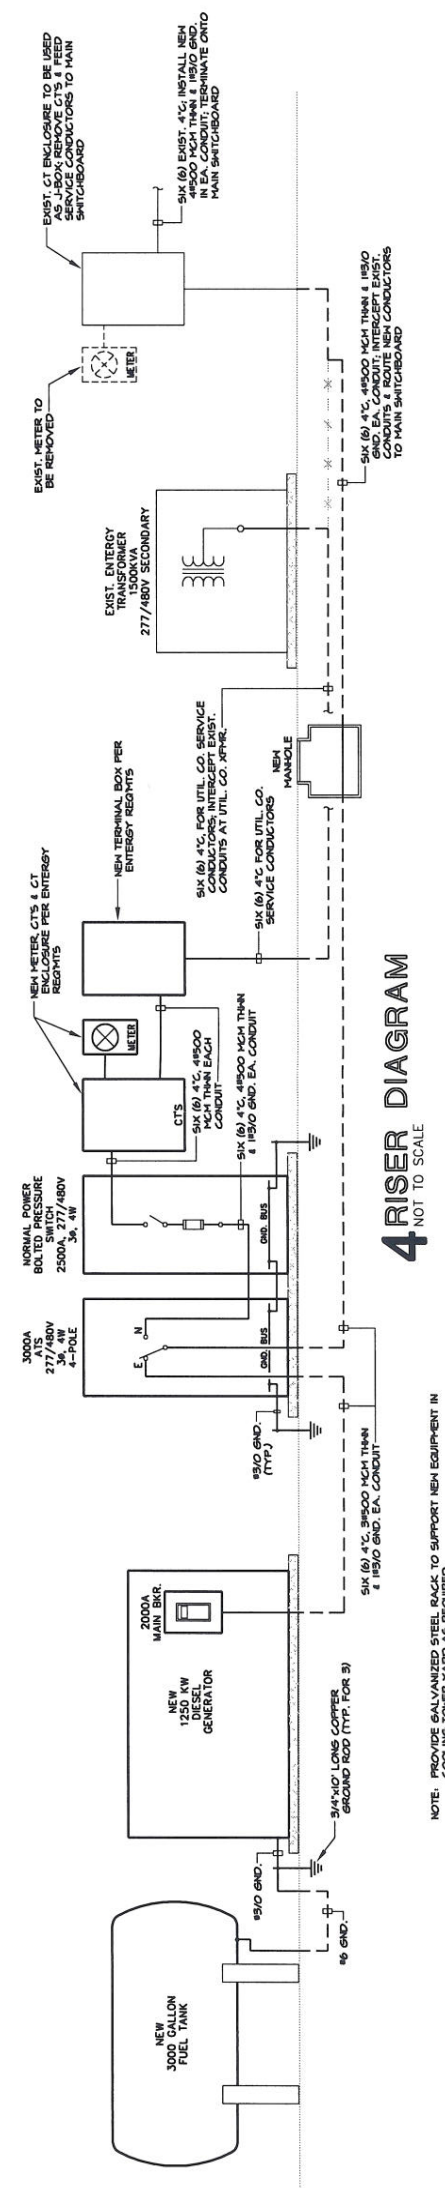

4 RISER DIAGRAM
NOT TO SCALE

NOTE: PROVIDE GALVANIZED STEEL BLACK TO SUPPORT NEW EQUIPMENT IN COOLING TOWER YARD AS REQUIRED.

DATE	REVISION

DESIGNED BY	DTC	CHECKED BY	DTC
DRAWN BY	SCP		

ASPHES Daniel T. Calongne 7911 Wrenwood Blvd., Suite D Baton Rouge, Louisiana 70809 voice (225) 382-2222 fax (225) 382-0414		STAMP
--	--	-------

OFFICE OF GROUP BENEFITS 5825 FLORIDA BOULEVARD, BATON ROUGE, LA	DATE 10-30-03 PROJECT NO. 03-083 SHEET NO. E-1
---	--

NEW GENERATOR INSTALLATION
ELECTRICAL SITE PLAN, RISER DIAGRAM,
GENERATOR FUEL SYSTEM DETAIL

