


# ALTERNATE BID #2

HVAC FAN COIL UNITS  
IN LIEU OF VAV SYSTEM

- NOTES:
- ONLY WORK PERTAINING TO HVAC SYSTEM IS PART OF ALTERNATE #2. ALL OTHER WORK IS PART OF BASE BID.



## LEGEND

- NEW DUPLEX RECEPTACLE
- EXHAUST FAN
- ▲ SECURITY ACCESS DOOR (SCANNER BY OTHERS)
- ◊ COMM @ DATA WALL PORT
- ⊙ COLUMN MOUNTED UTILITY DATA AND POWER FUTURE TELEPHONE DATA & POWER POLES BY OTHERS

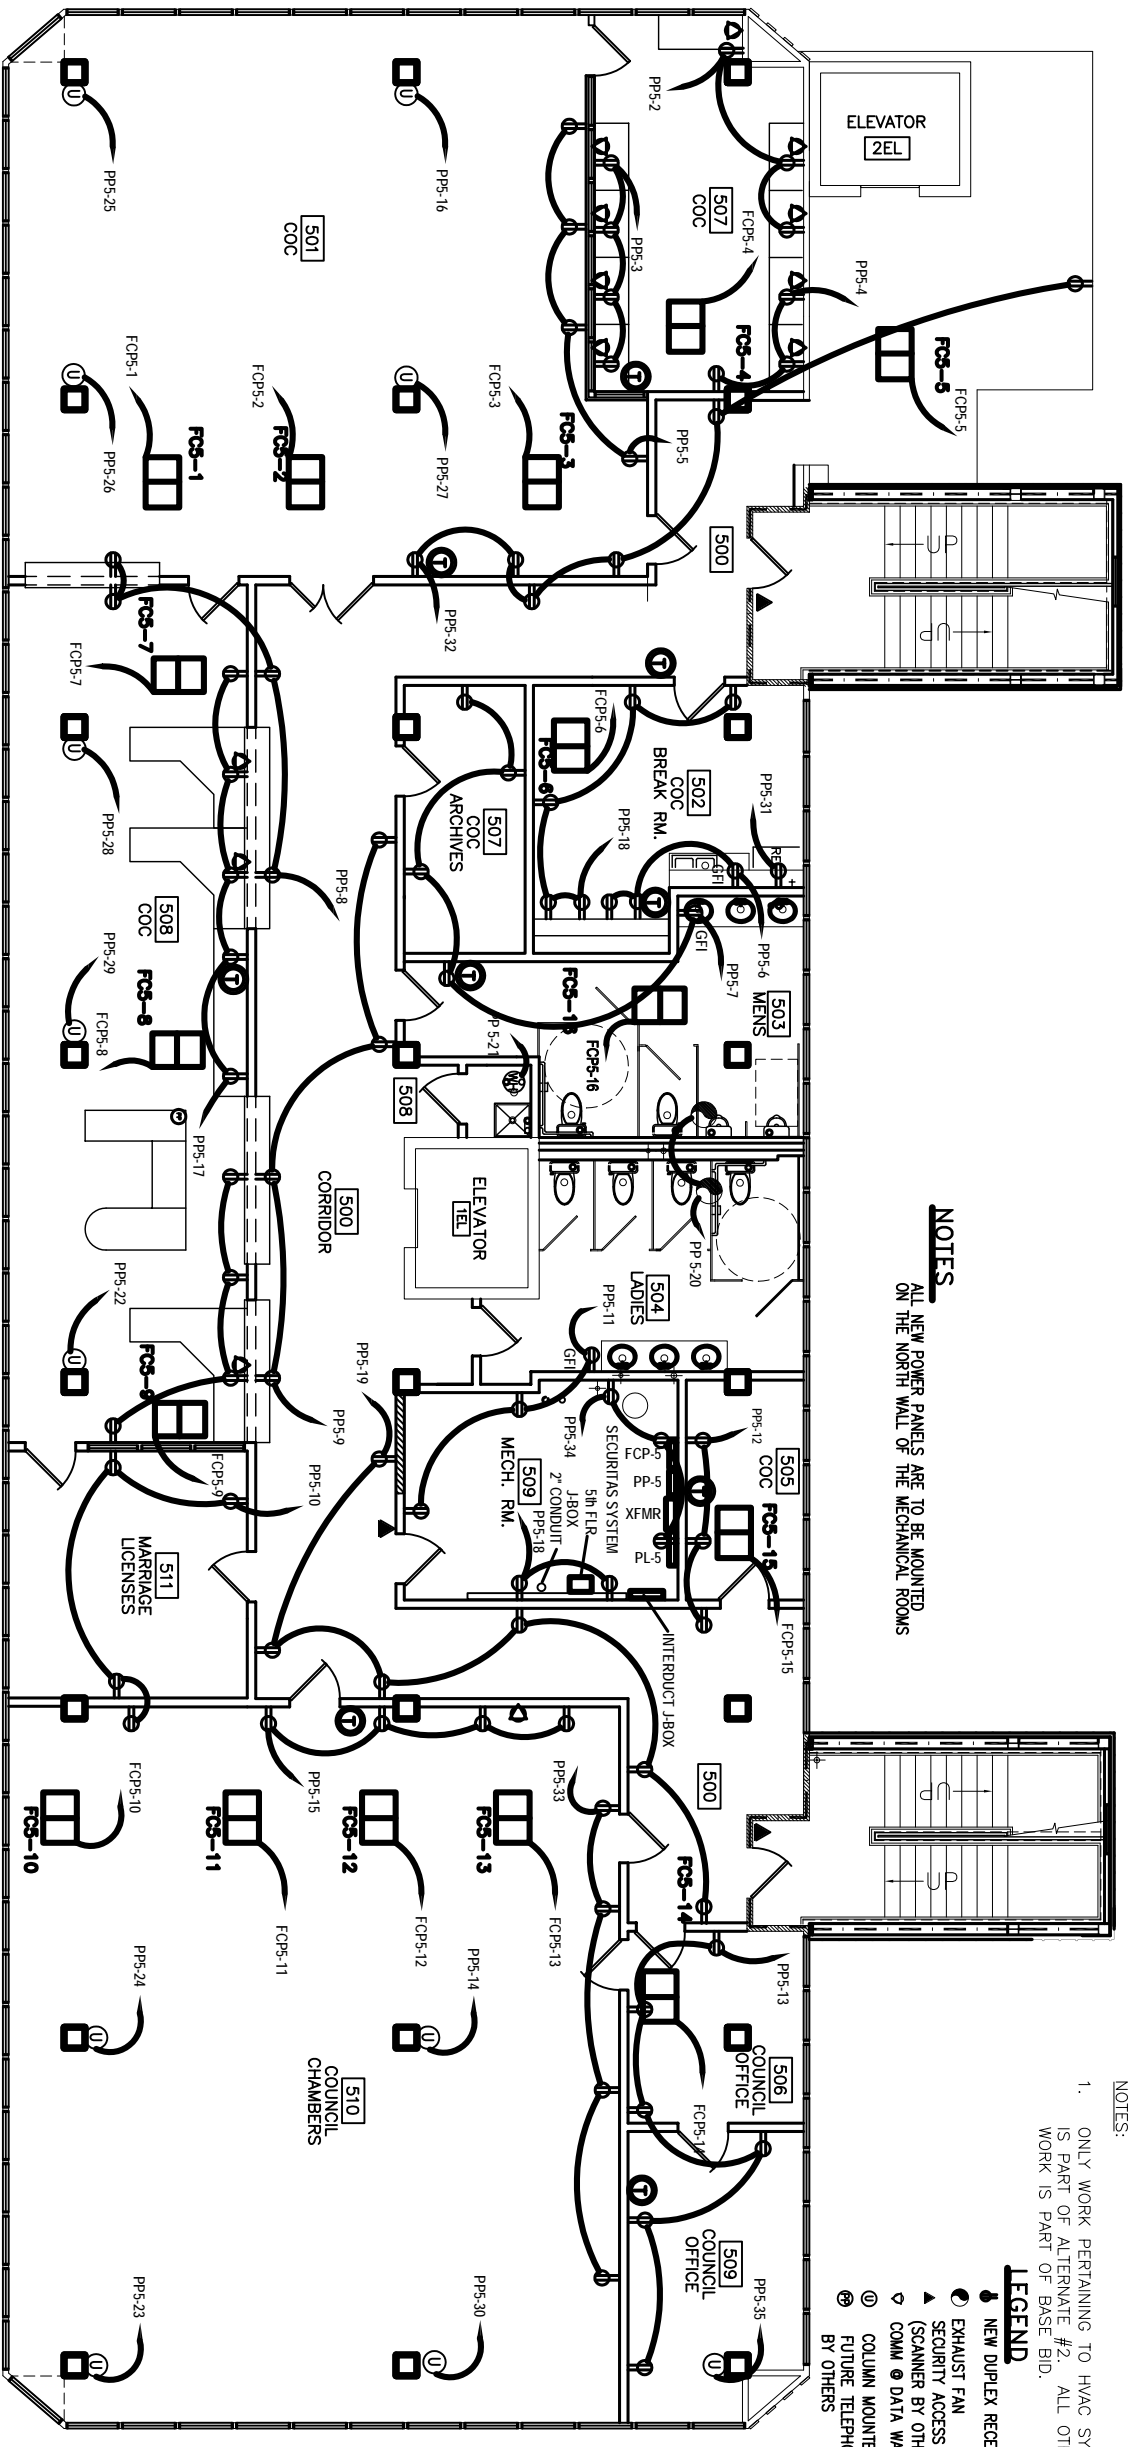

NOTES:  
ALL NEW POWER PANELS ARE TO BE MOUNTED ON THE NORTH WALL OF THE MECHANICAL ROOMS

**FIFTH FLOOR POWER PLAN**  
SCALE: 3/16" = 1'-0"

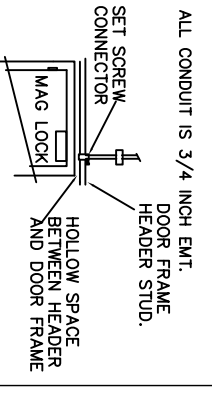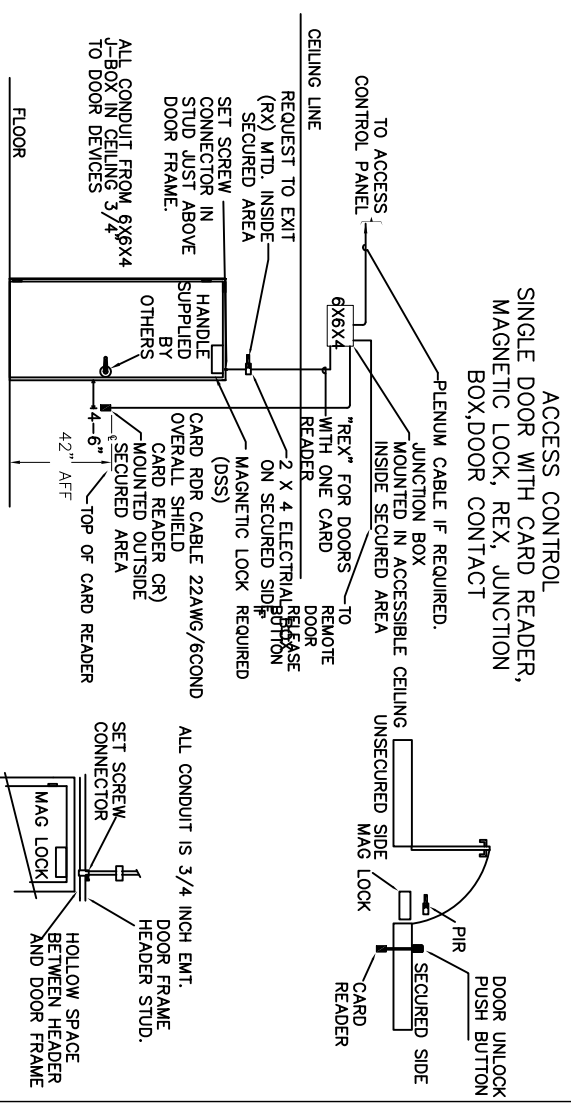

NOTE: EACH COLUMN CONSISTS OF  
2-YELLOW CAT.5 COMM LINES  
5-BLUE CAT.5 DATA LINES  
& 1-POWER CRT.

**COLUMN MOUNTED UTILITY DETAIL**  
SCALE: NTS

REVISED: 05/17/07/ab  
REVISED: 05/01/07/ab  
REVISED: 01/25/07

<p>RENOVATE OFFICE BUILDING</p> <h1 style="margin: 0;">DAMMON ENGINEERING. INC.</h1> <p style="font-size: small; margin: 0;">1095 FLORIDA AVENUE 985-649-5832 SLIDELL, LA. 70458 DAMMONENGINEERING.COM</p>	<p><b>5TH FLOOR POWER PLAN</b></p> <p>ST. TAMMANY PARISH ADMIN. COMPLEX OLD SPANISH TRAIL SLIDELL, LOUISIANA</p>	<p>SCALE:AS NOTED</p> <p>FILE: _____</p> <p>JOB NO. 1729</p> <p>DATE: 1-8-07</p> <p>SHEET _____</p> <p>OF _____</p> <h1 style="font-size: 2em; margin: 0;">ESP</h1>
--	--	---