

ALTERNATE BID #2

HVAC FAN COIL UNITS
IN LIEU OF VAV SYSTEM

NOTES:


- ONLY WORK PERTAINING TO HVAC SYSTEM IS PART OF ALTERNATE #2. ALL OTHER WORK IS PART OF BASE BID.

LEGEND


- NEW DUPLEX RECEPTACLE
- ⊙ EXHAUST FAN
- ⬆ SECURITY ACCESS DOOR (SCANNER BY OTHERS)
- ⊙ COMM @ DATA WALL PORT
- ⊙ COLUMN MOUNTED UTILITY DATA AND POWER
- ⊙ FUTURE TELEPHONE DATA & POWER POLES BY OTHERS

NOTES


ALL NEW POWER PANELS ARE TO BE MOUNTED ON THE NORTH WALL OF THE MECHANICAL ROOMS

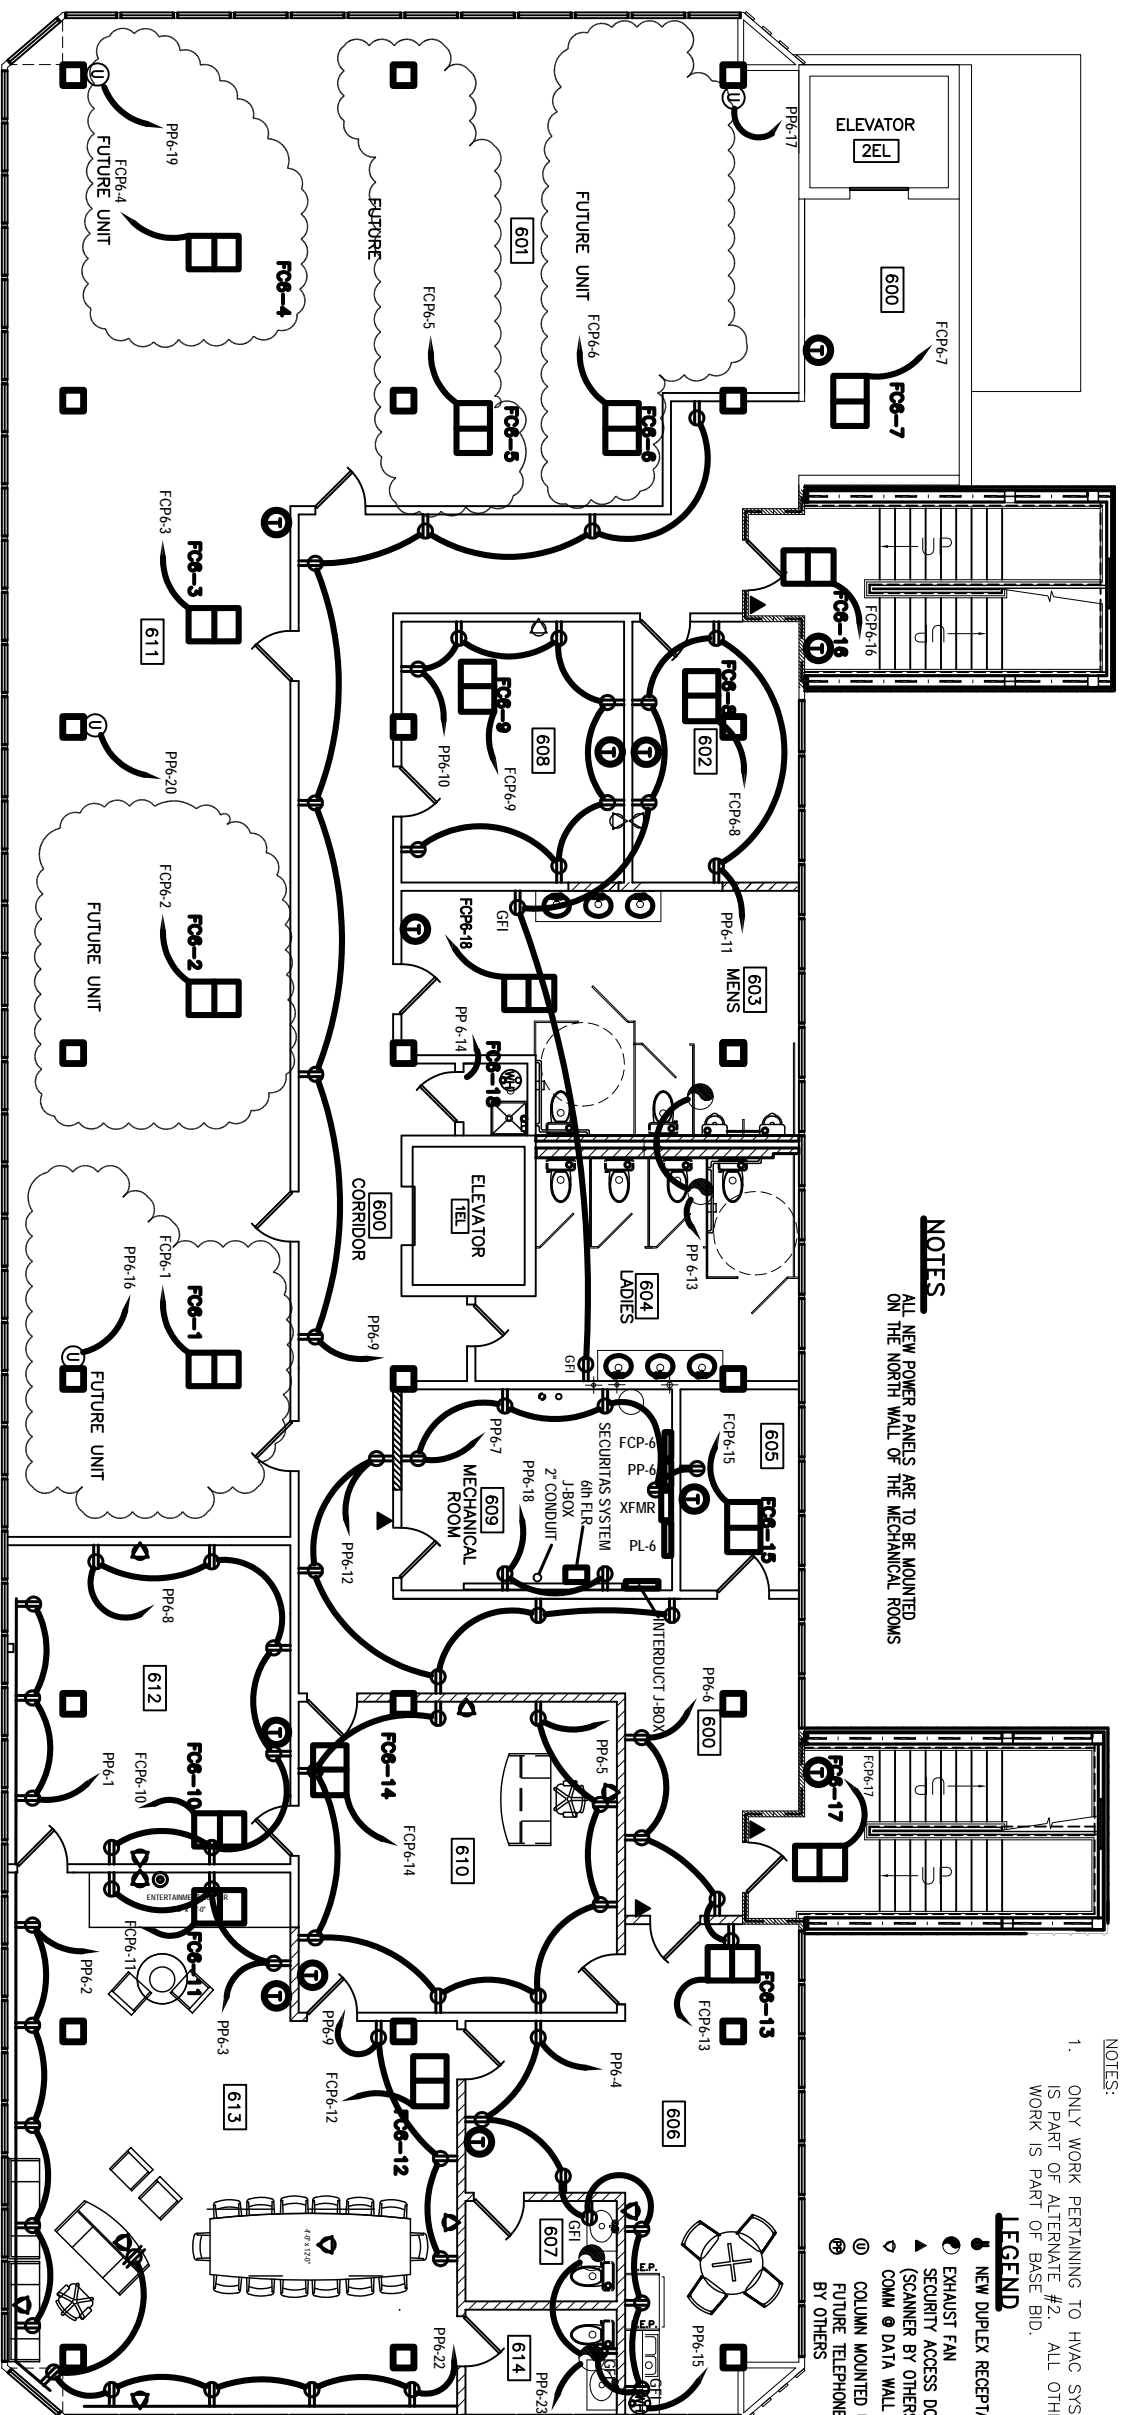

SIXTH FLOOR POWER PLAN
SCALE: 3/16" = 1'-0"

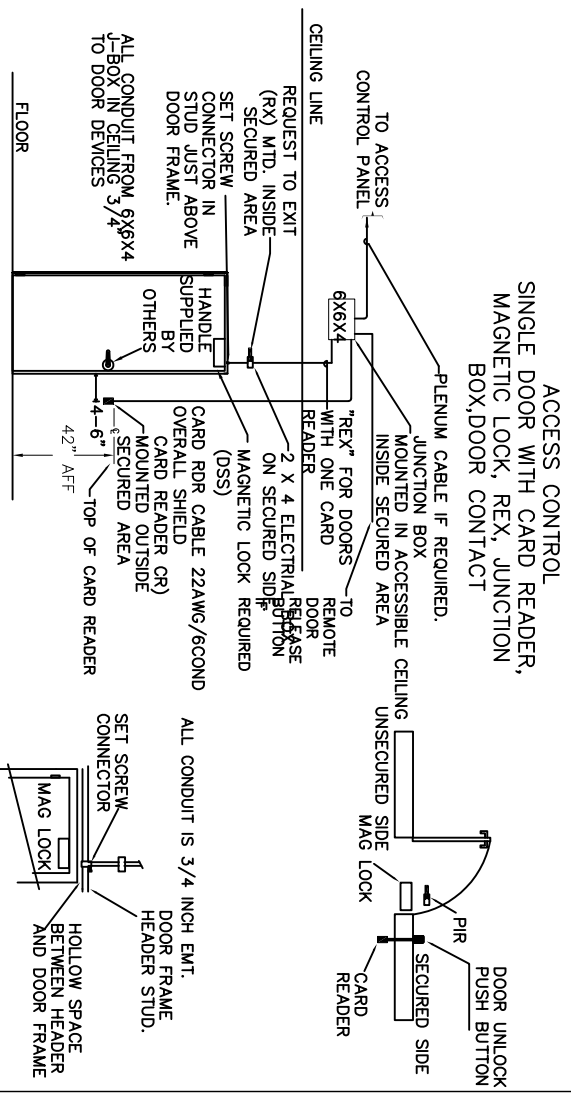

COLUMN MOUNTED UTILITY DETAIL
SCALE: NTS

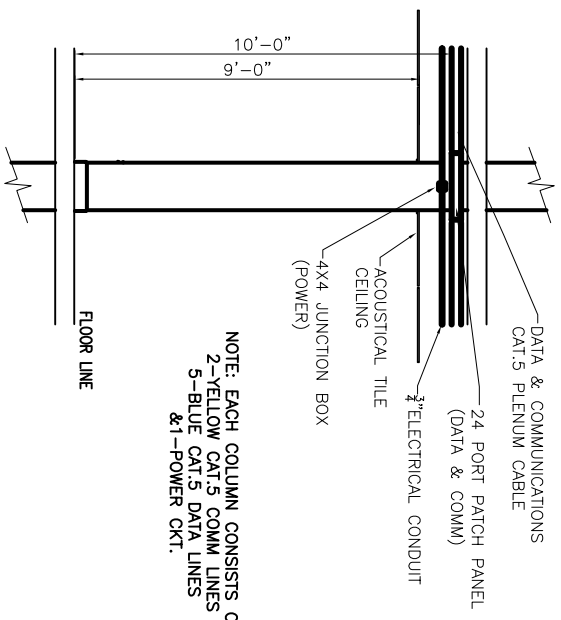

NOTE: EACH COLUMN CONSISTS OF
2-YELLOW CAT5 COMM LINES
5-BLUE CAT5 DATA LINES
& 1-POWER CRT.

REVISED: 05/17/07/ab
REVISED: 05/07/07/ab
REVISED: 04/23/07
REVISED: 01/23/07

<p>RENOVATE OFFICE BUILDING</p> <h1 style="margin: 0;">DAMMON ENGINEERING. INC.</h1> <p style="font-size: small;">1095 FLORIDA AVENUE 985-649-5832 SLIDELL, LA. 70458 DAMMONENGINEERING.COM</p>	<p>6TH FLOOR POWER PLAN</p> <p>ST. TAMMANY PARISH ADMIN. COMPLEX OLD SPANISH TRAIL SLIDELL, LOUISIANA</p>	<p>SCALE:AS NOTED</p> <p>FILE:</p> <p>JOB NO. 1729</p> <p>DATE:1-8-07</p> <p>SHEET</p> <p style="font-size: large;">E6P</p> <p>OF</p>
---	--	---