


**ST. TAMMANY PARISH  
ADMINISTRATION COMPLEX RENOVATIONS**

520 OLD SPANISH TRAIL  
SLIDELL, LOUISIANA

DESIGNED BY:	FRED FATH
DATE:	OCTOBER 2008
PROJ. NO.:	
SCALE:	3/16"=1'-0"

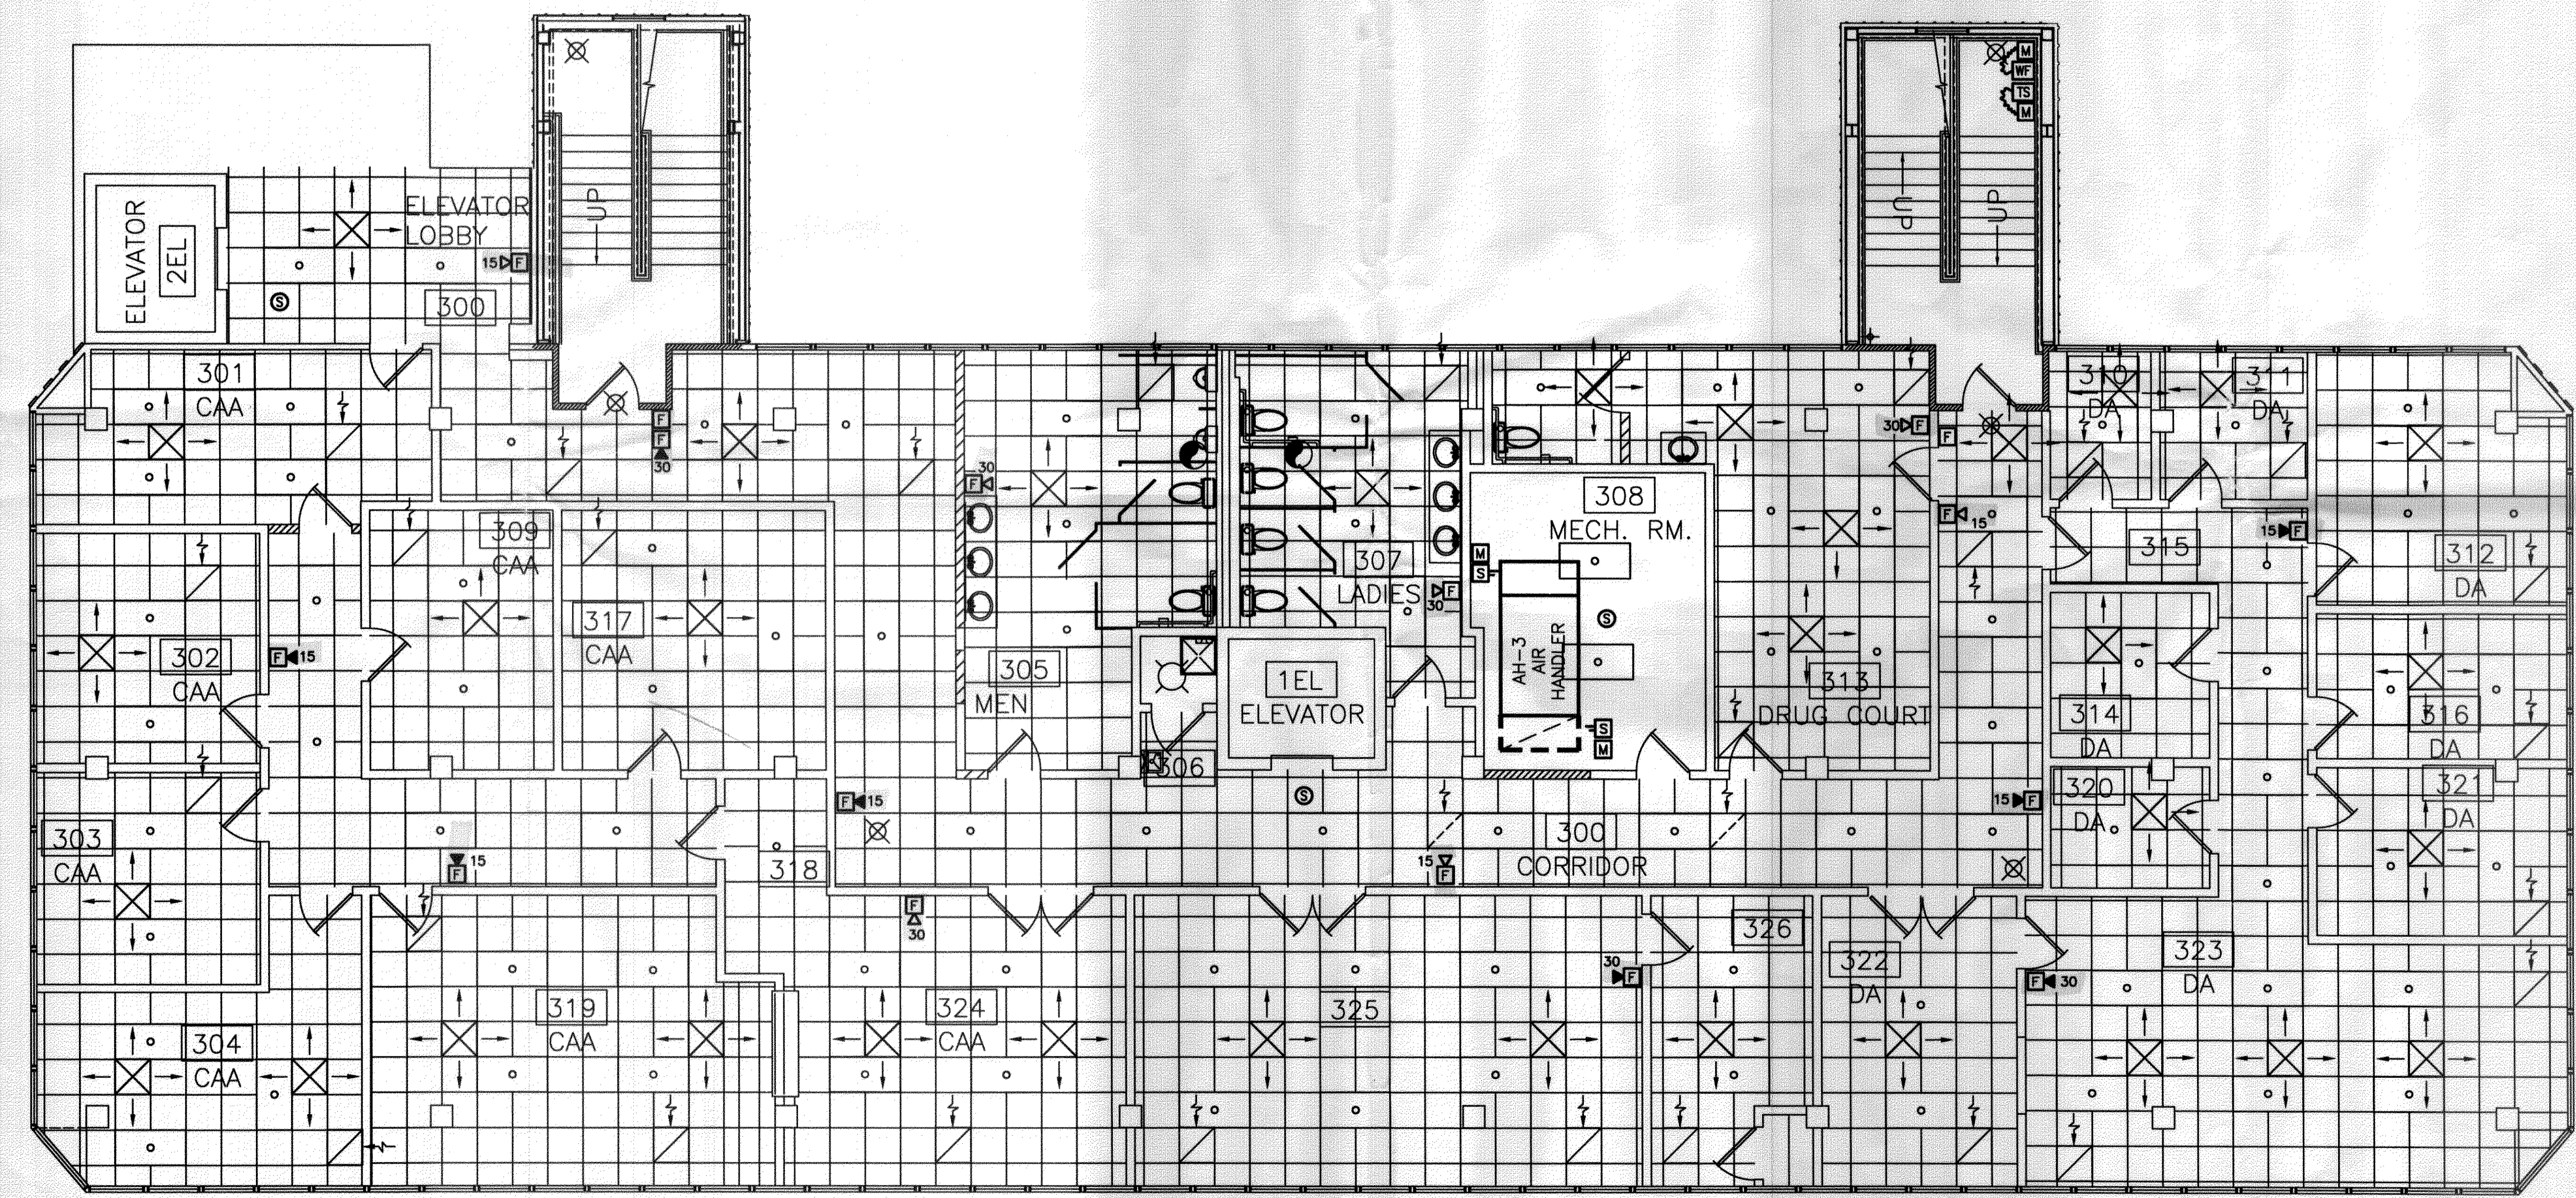

**THIRD FLOOR PLAN – FIRE DETECTION AND ALARM SYSTEM**  
SCALE 3/16" = 1'-0"

357110  
REVIEWED FOR  
STATE FIRE MARSHAL  
AS PER REVIEW LETTER  
BY: WILLIAM D. JONES, ARCHITECT, CBO  
*William D. Jones*

**NOTE:**  
FIRE ALARM SYSTEM SMOKE DETECTORS  
SHALL NOT BE INSTALLED WITHIN  
3'-0" FROM AN A.H.U. AIR SUPPLY  
DIFFUSER OR WITHIN 1'-0" OF A  
LIGHT FIXTURE.