




OFFICE  
801 SOUTH OAK STREET  
MONROE, LA 70001

MAILING  
P.O. BOX 415  
MONROE, LA 70004

PHONE (985) 439-1040  
FAX (985) 439-1041

ST. TAMMANY PARISH  
ADMINISTRATION COMPLEX RENOVATIONS  
620 OLD SPANISH TRAIL  
SLIDELL, LOUISIANA

DESIGNED BY: FRED FATH  
DATE: OCTOBER 2010  
PROJ. NO.:  
SCALE: 3/16"=1'-0"

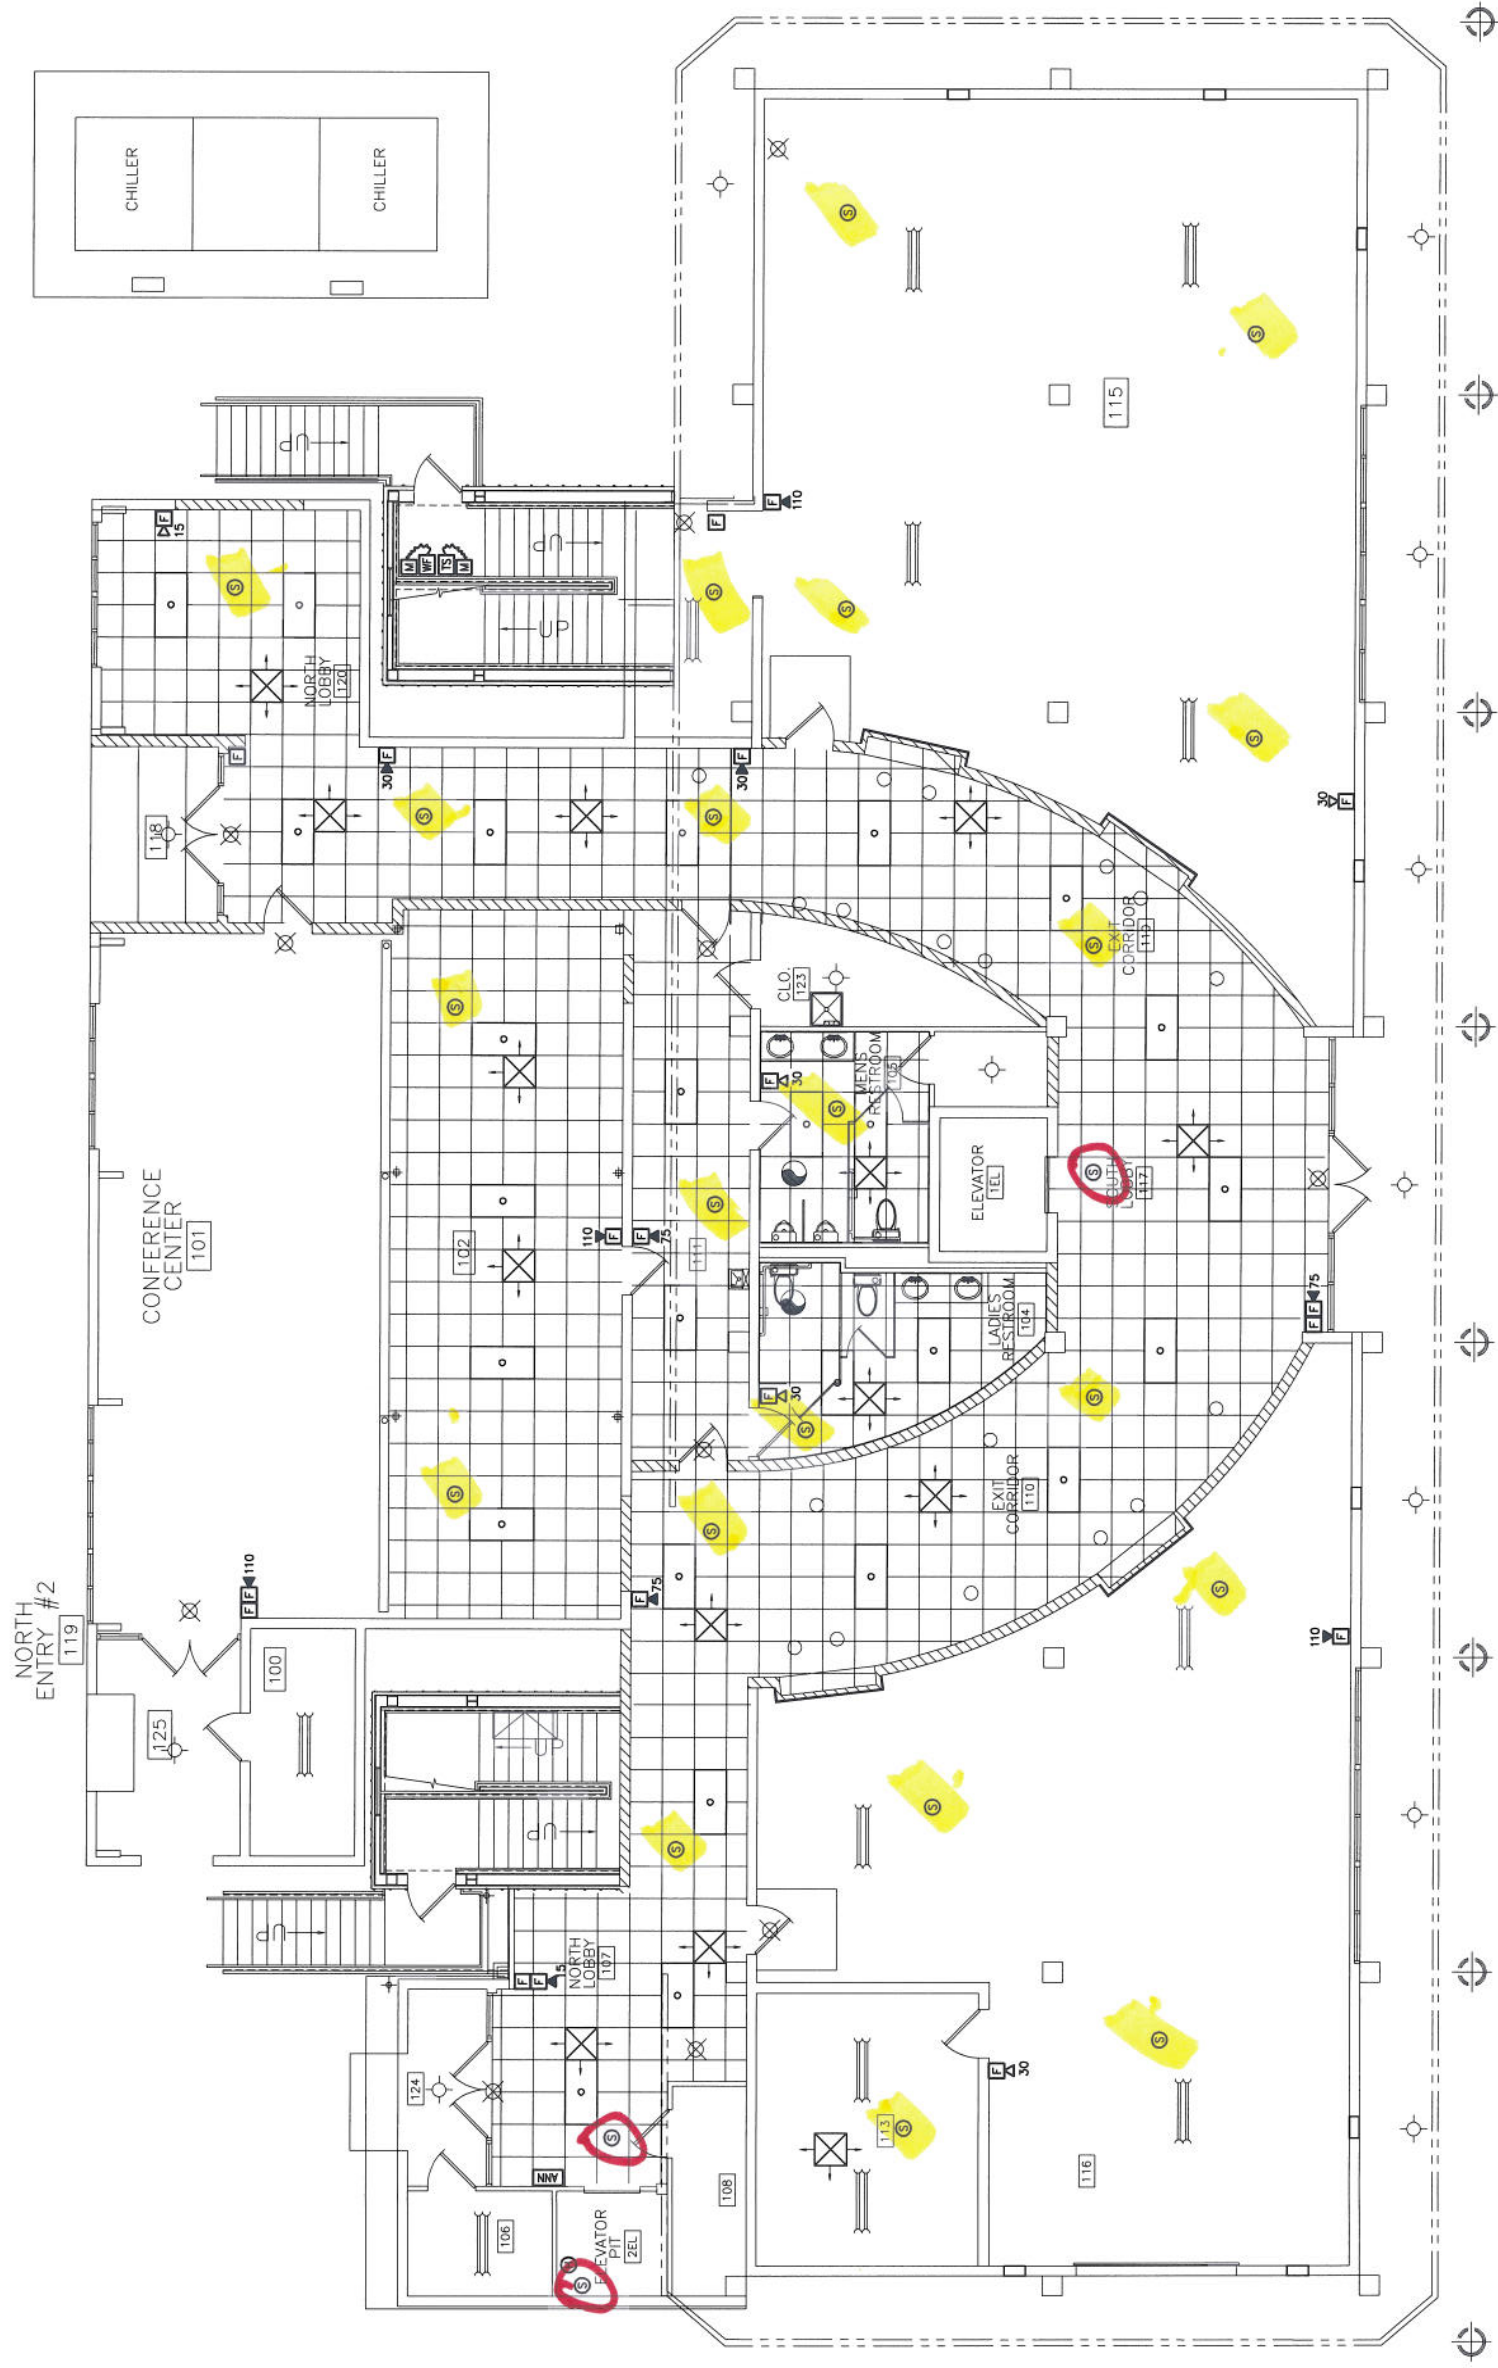

NOTE:  
FIRE ALARM SYSTEM SMOKE DETECTORS  
SHALL NOT BE INSTALLED WITHIN  
3'-0" FROM AN A.H.U., AIR SUPPLY  
DIFFUSER OR WITHIN 1'-0" OF A  
LIGHT FIXTURE.

FIRST FLOOR PLAN - FIRE DETECTION AND ALARM SYSTEM  
SCALE 3/16" = 1'-0"