




**CONDUIT DOOR LAYOUT
SINGLE DOOR MAG LOCK**

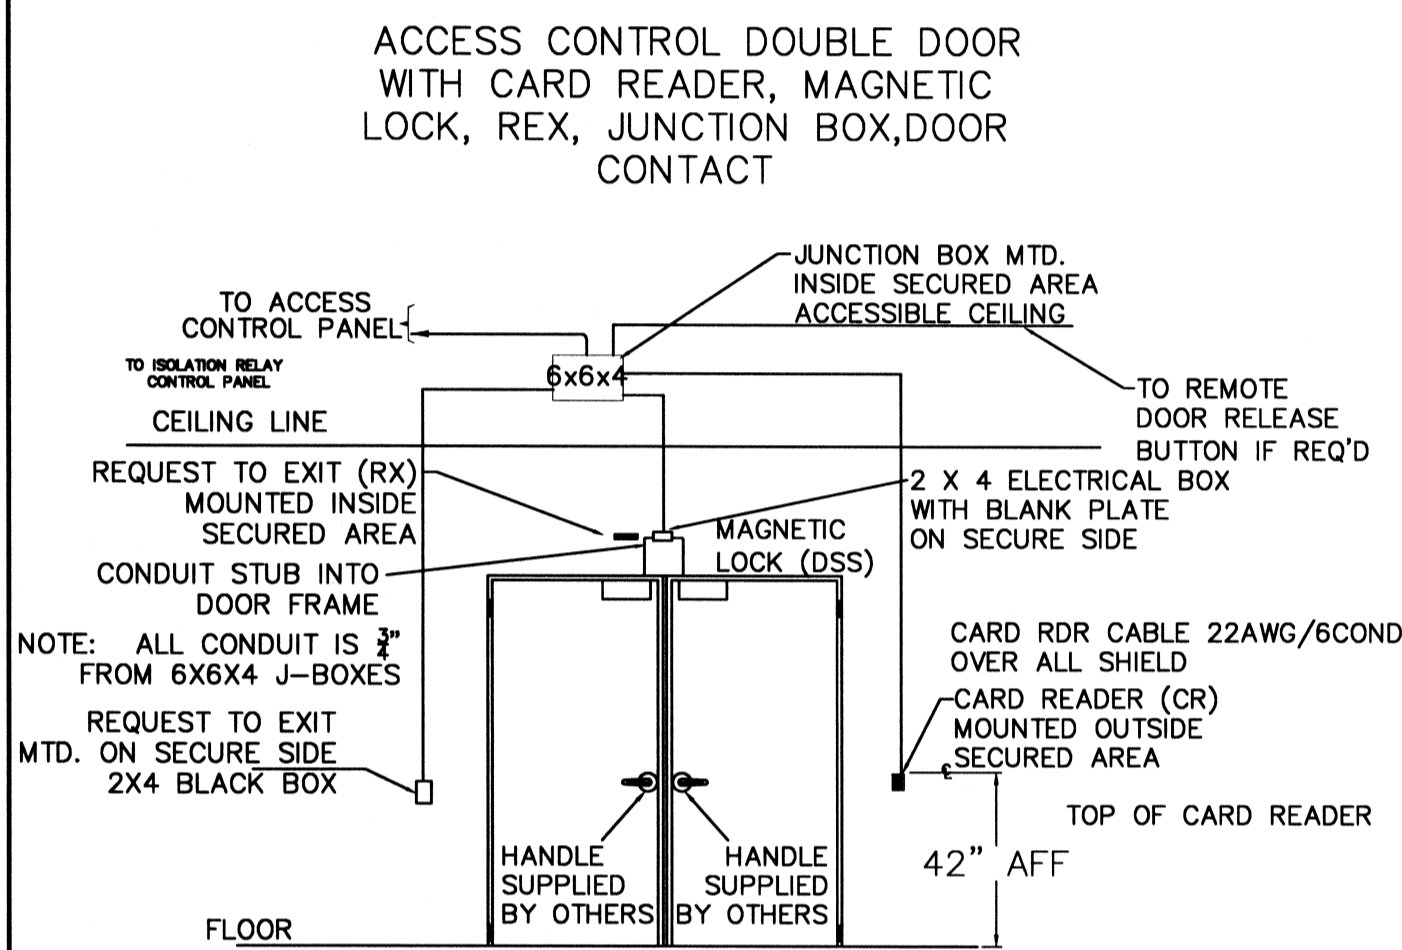

**CONDUIT DOOR LAYOUT
DOUBLE DOOR MAG LOCK**

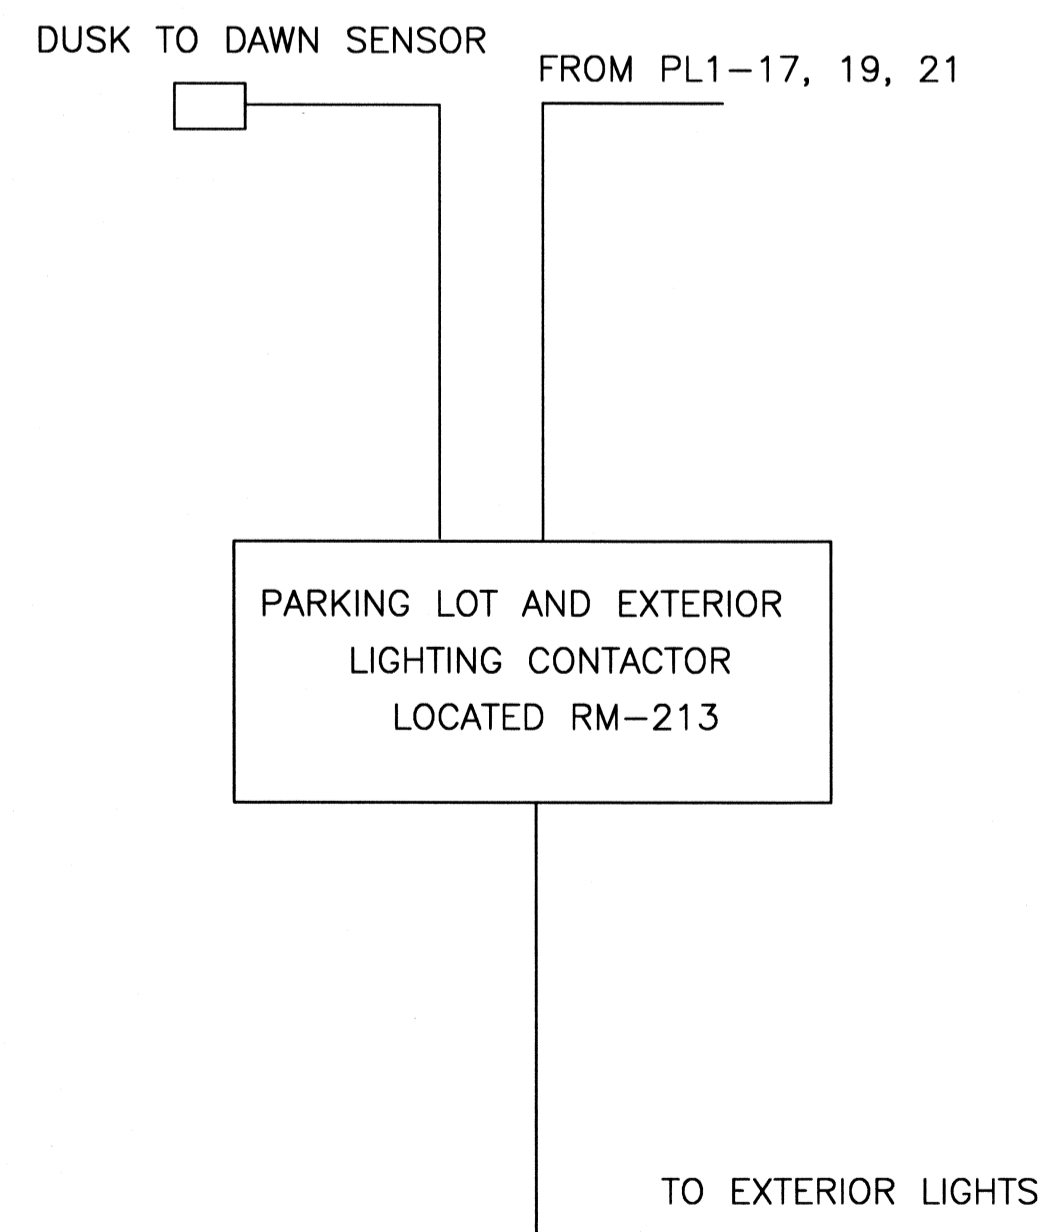

- LEGEND**
- ⊕ NEW DUPLEX RECEPTACLE
 - ⊙ EXHAUST FAN
 - ▲ SECURITY ACCESS DOOR (SCANNER BY OTHERS)
 - ⊕ COLUMN MOUNTED UTILITIES
 - ⊙ JUNCTION BOX
- NOTE**

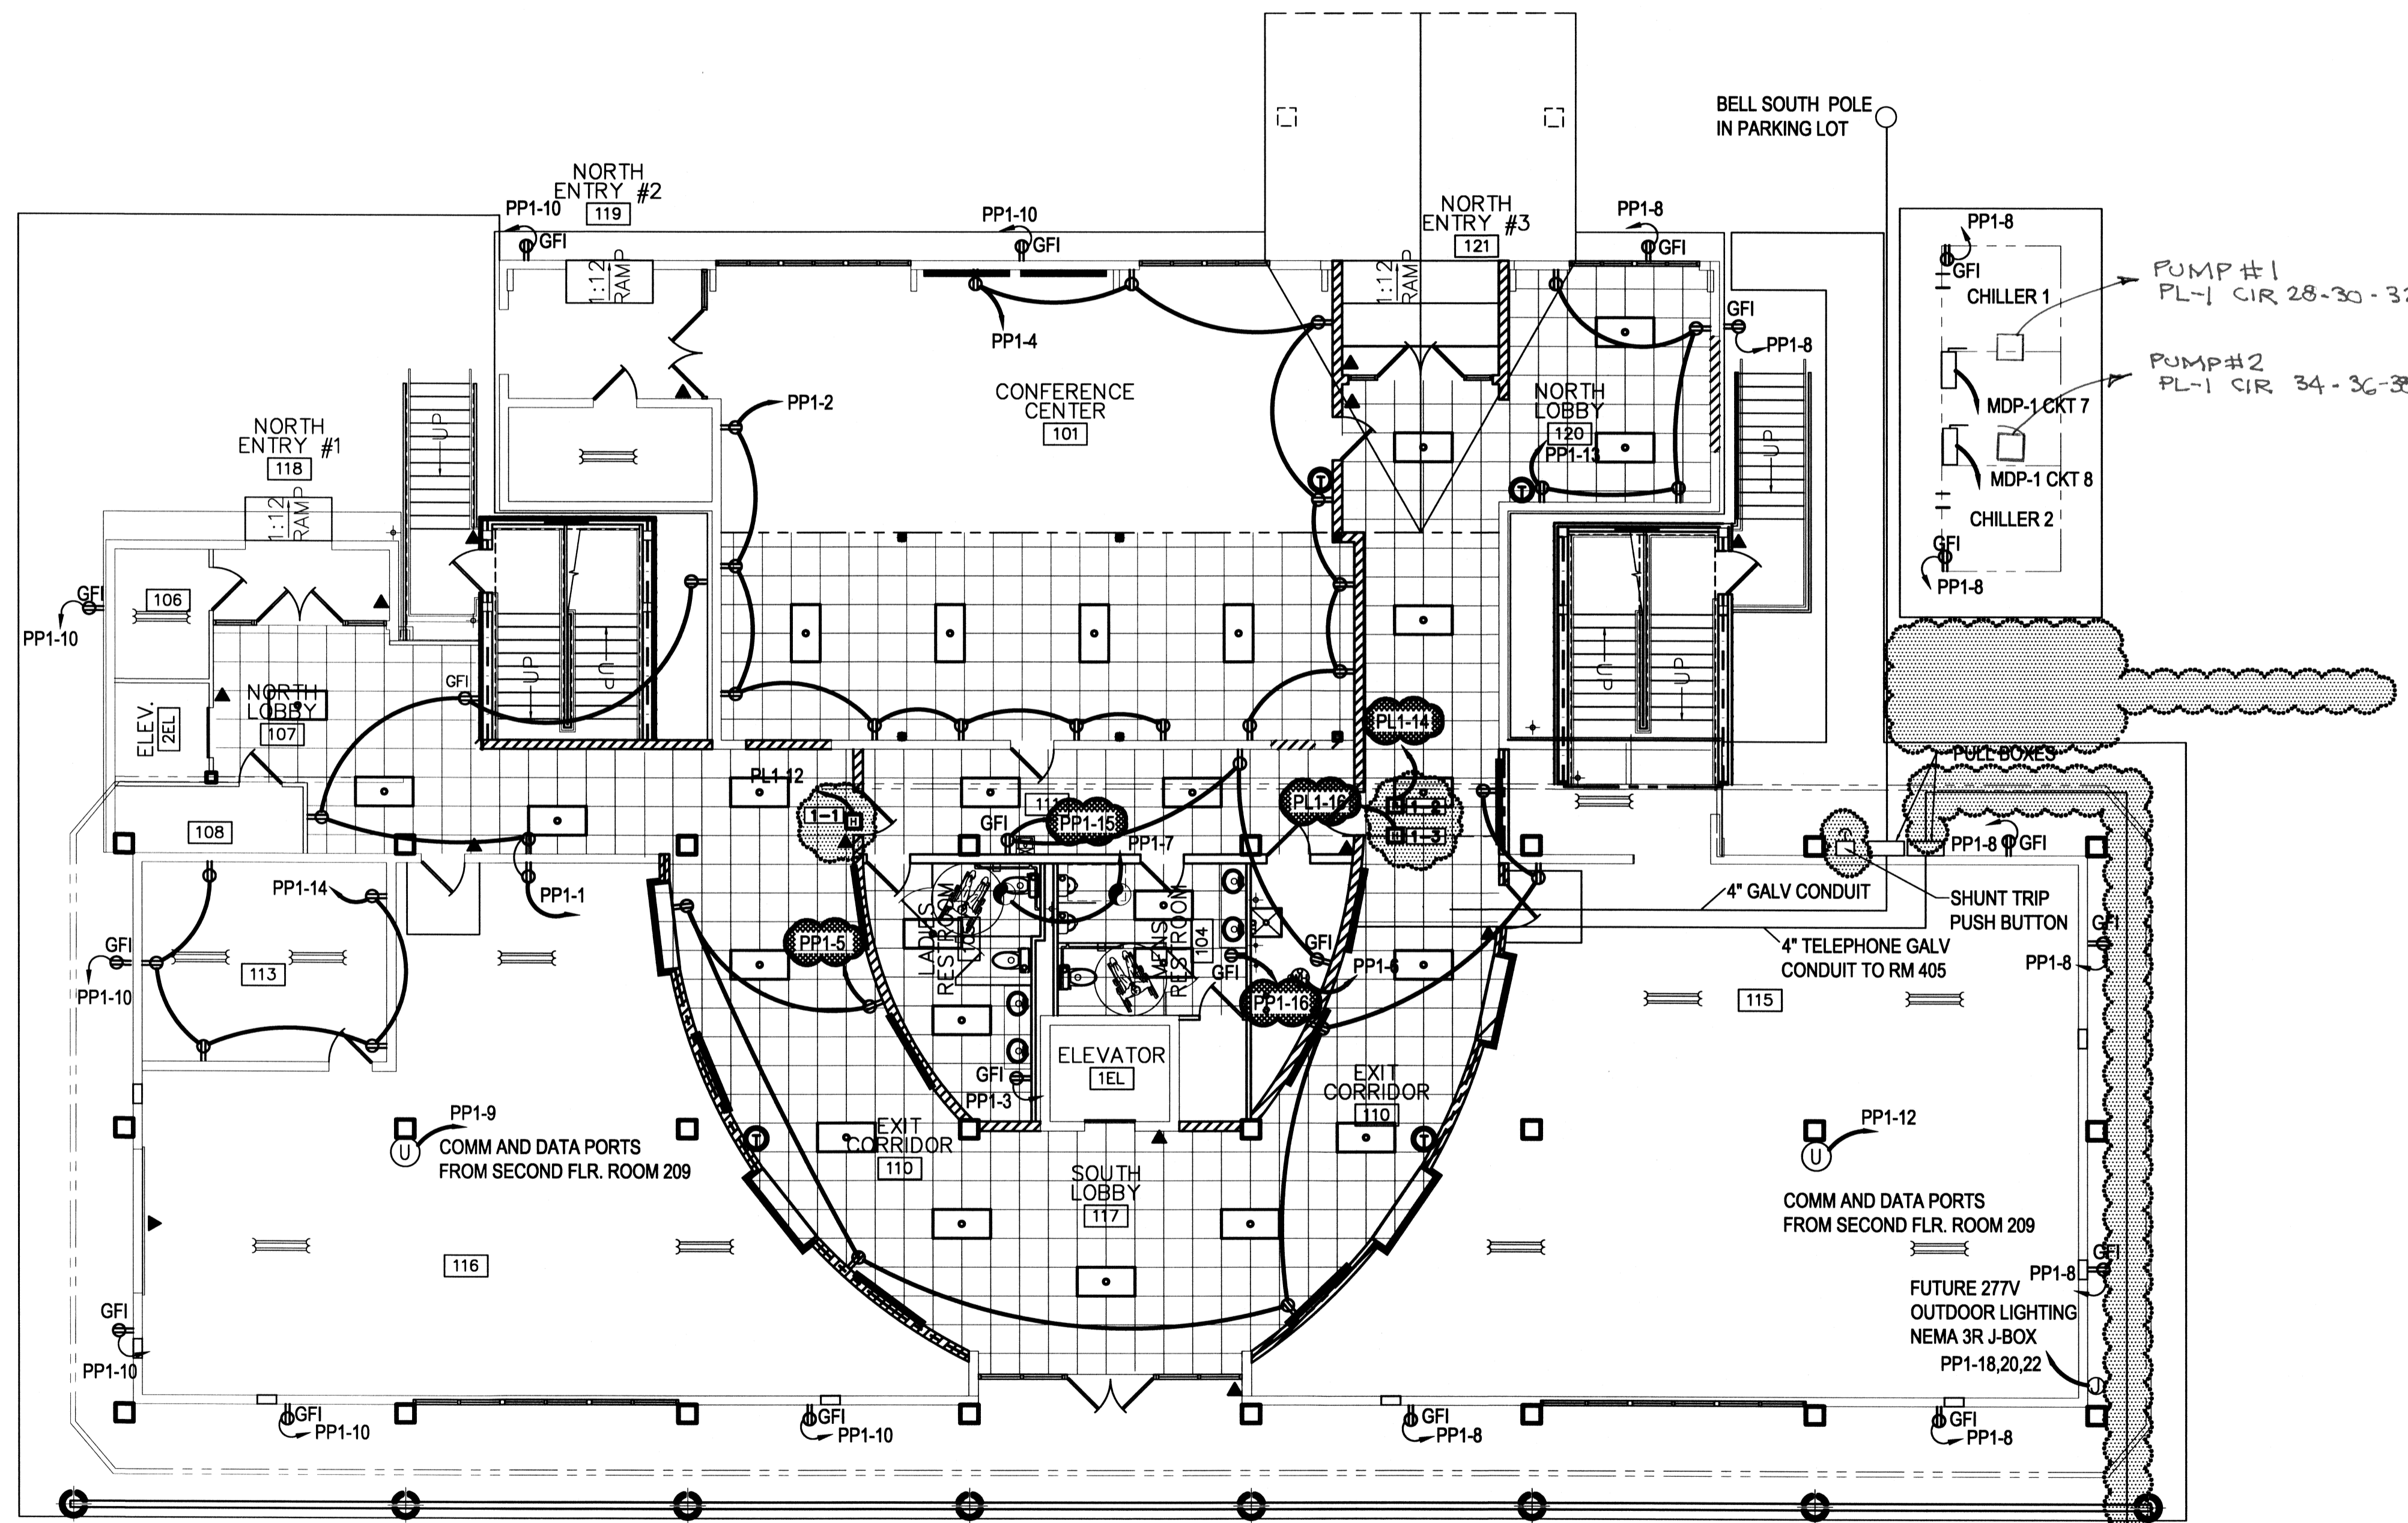

FIRST FLOOR POWER PLAN
SCALE: 1/8" = 1'-0"

PL1-18 - INDICATES ITEMS CHANGED- 06/27/08
0000 - INDICATES ITEMS CHANGED- 05/29/08

REVISED: 06/27/08 ab
STAR HVAC REVISED: 05/29/08 ab
ELECT XFRM. 020708 KD
HVAC CHANGES: 11/05/07ab

RFP #2 11-13-07

1ST FLOOR POWER PLAN
ST. TAMMANY PARISH ADMIN. COMPLEX
OLD SPANISH TRAIL
SLIDELL, LOUISIANA

RENOVATE OFFICE BUILDING
DAMMON ENGINEERING, INC.
1095 FLORIDA AVENUE 985-649-5832 SLIDELL, LA. 70458
DAMMONENGINEERING.COM

SCALE: AS NOTED
FILE:
JOB NO. 1729
DATE: 1-8-07

SHEET
E1P
OF