




- LEGEND**
- ⊕ NEW DUPLEX RECEPTACLE
  - ⊙ EXHAUST FAN
  - ▲ SECURITY ACCESS DOOR (SCANNER BY OTHERS)
  - ◊ COMM & DATA
  - ⊕ COLUMN MOUNTED UTILITY
- NOTES**
- ALL NEW POWER PANELS ARE TO BE MOUNTED ON THE NORTH WALL OF THE MECHANICAL ROOMS

3RD FLOOR POWER PLAN  
 ST. TAMMANY PARISH ADMIN. COMPLEX  
 OLD SPANISH TRAIL  
 SLIDELL, LOUISIANA

RENOVATE OFFICE BUILDING  
**DAMMON ENGINEERING, INC.**  
 1095 FLORIDA AVENUE 986-649-5632 SLIDELL, LA. 70458  
 DAMMONENGINEERING.COM

**D**AMMON ENGINEERING, INC.

SCALE: AS NOTED  
 FILE:  
 JOB NO. 1729  
 DATE: 1-8-07  
 SHEET  
**E3P**  
 OF

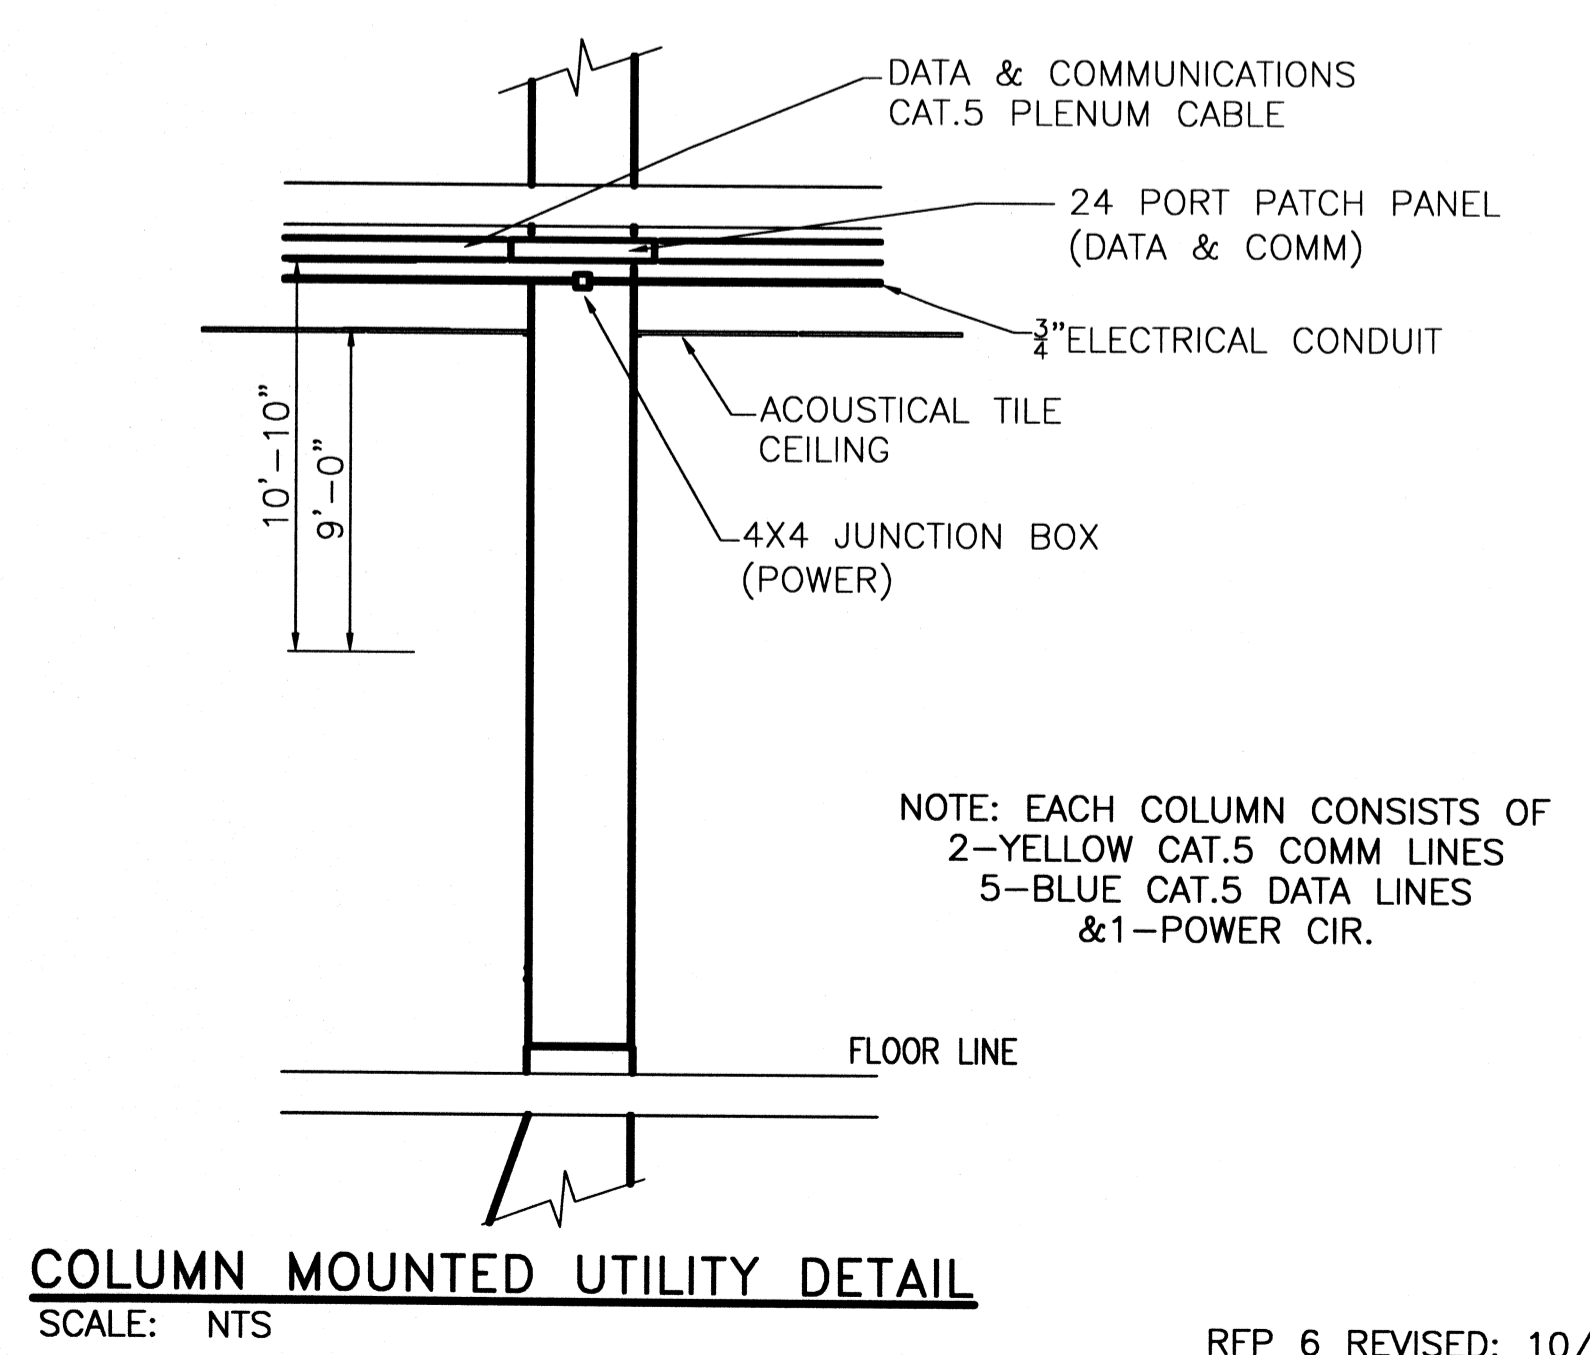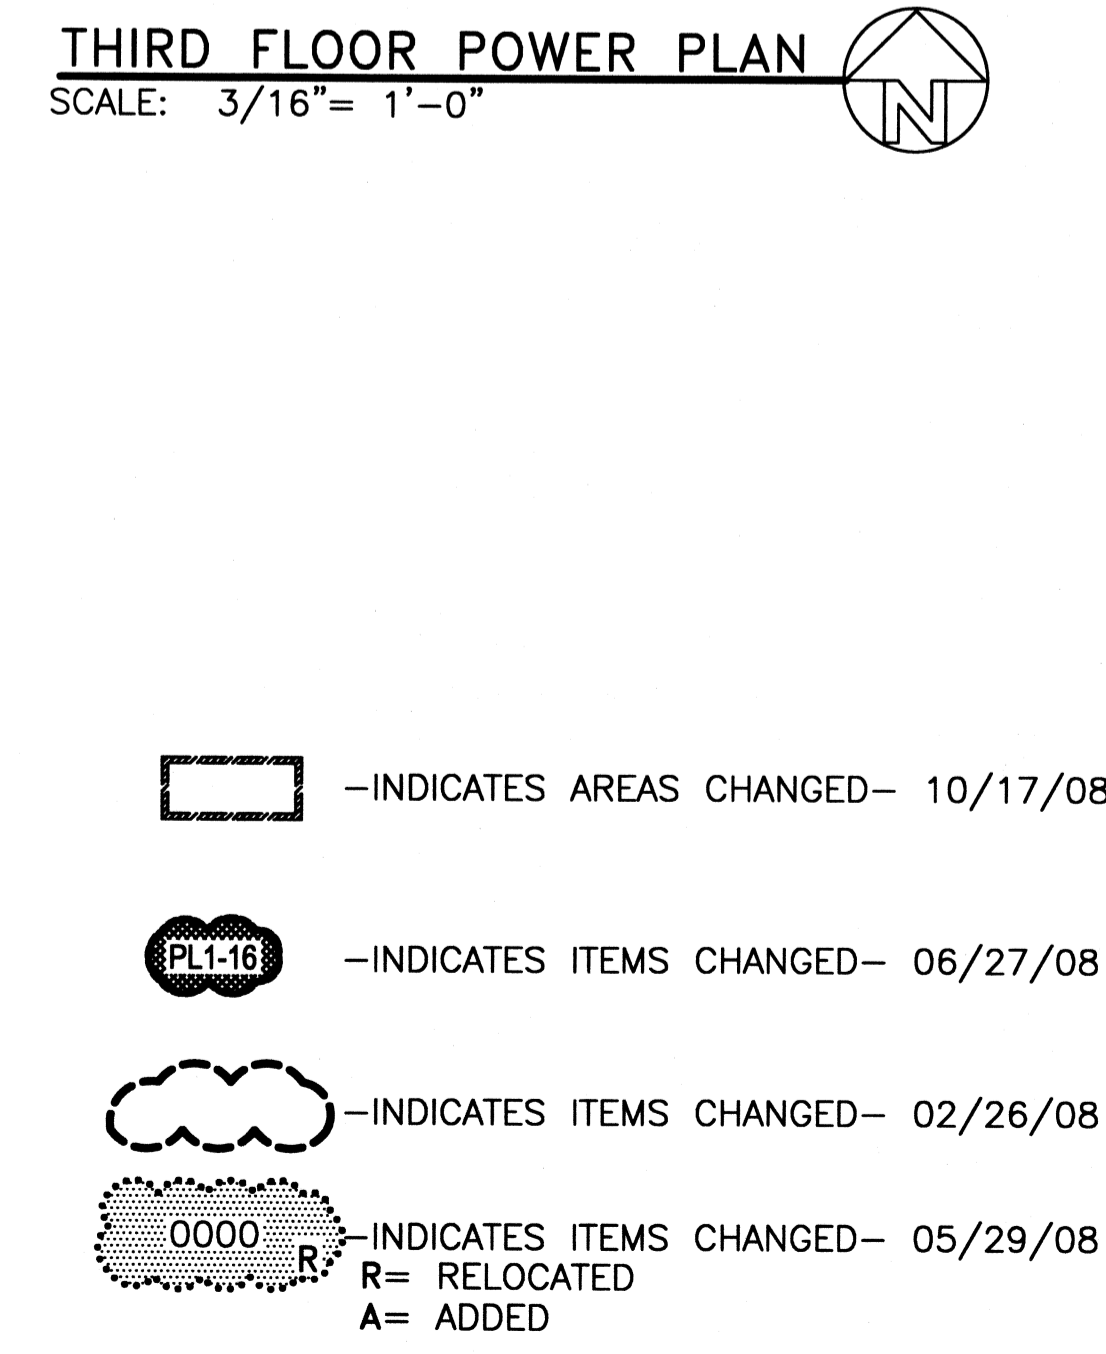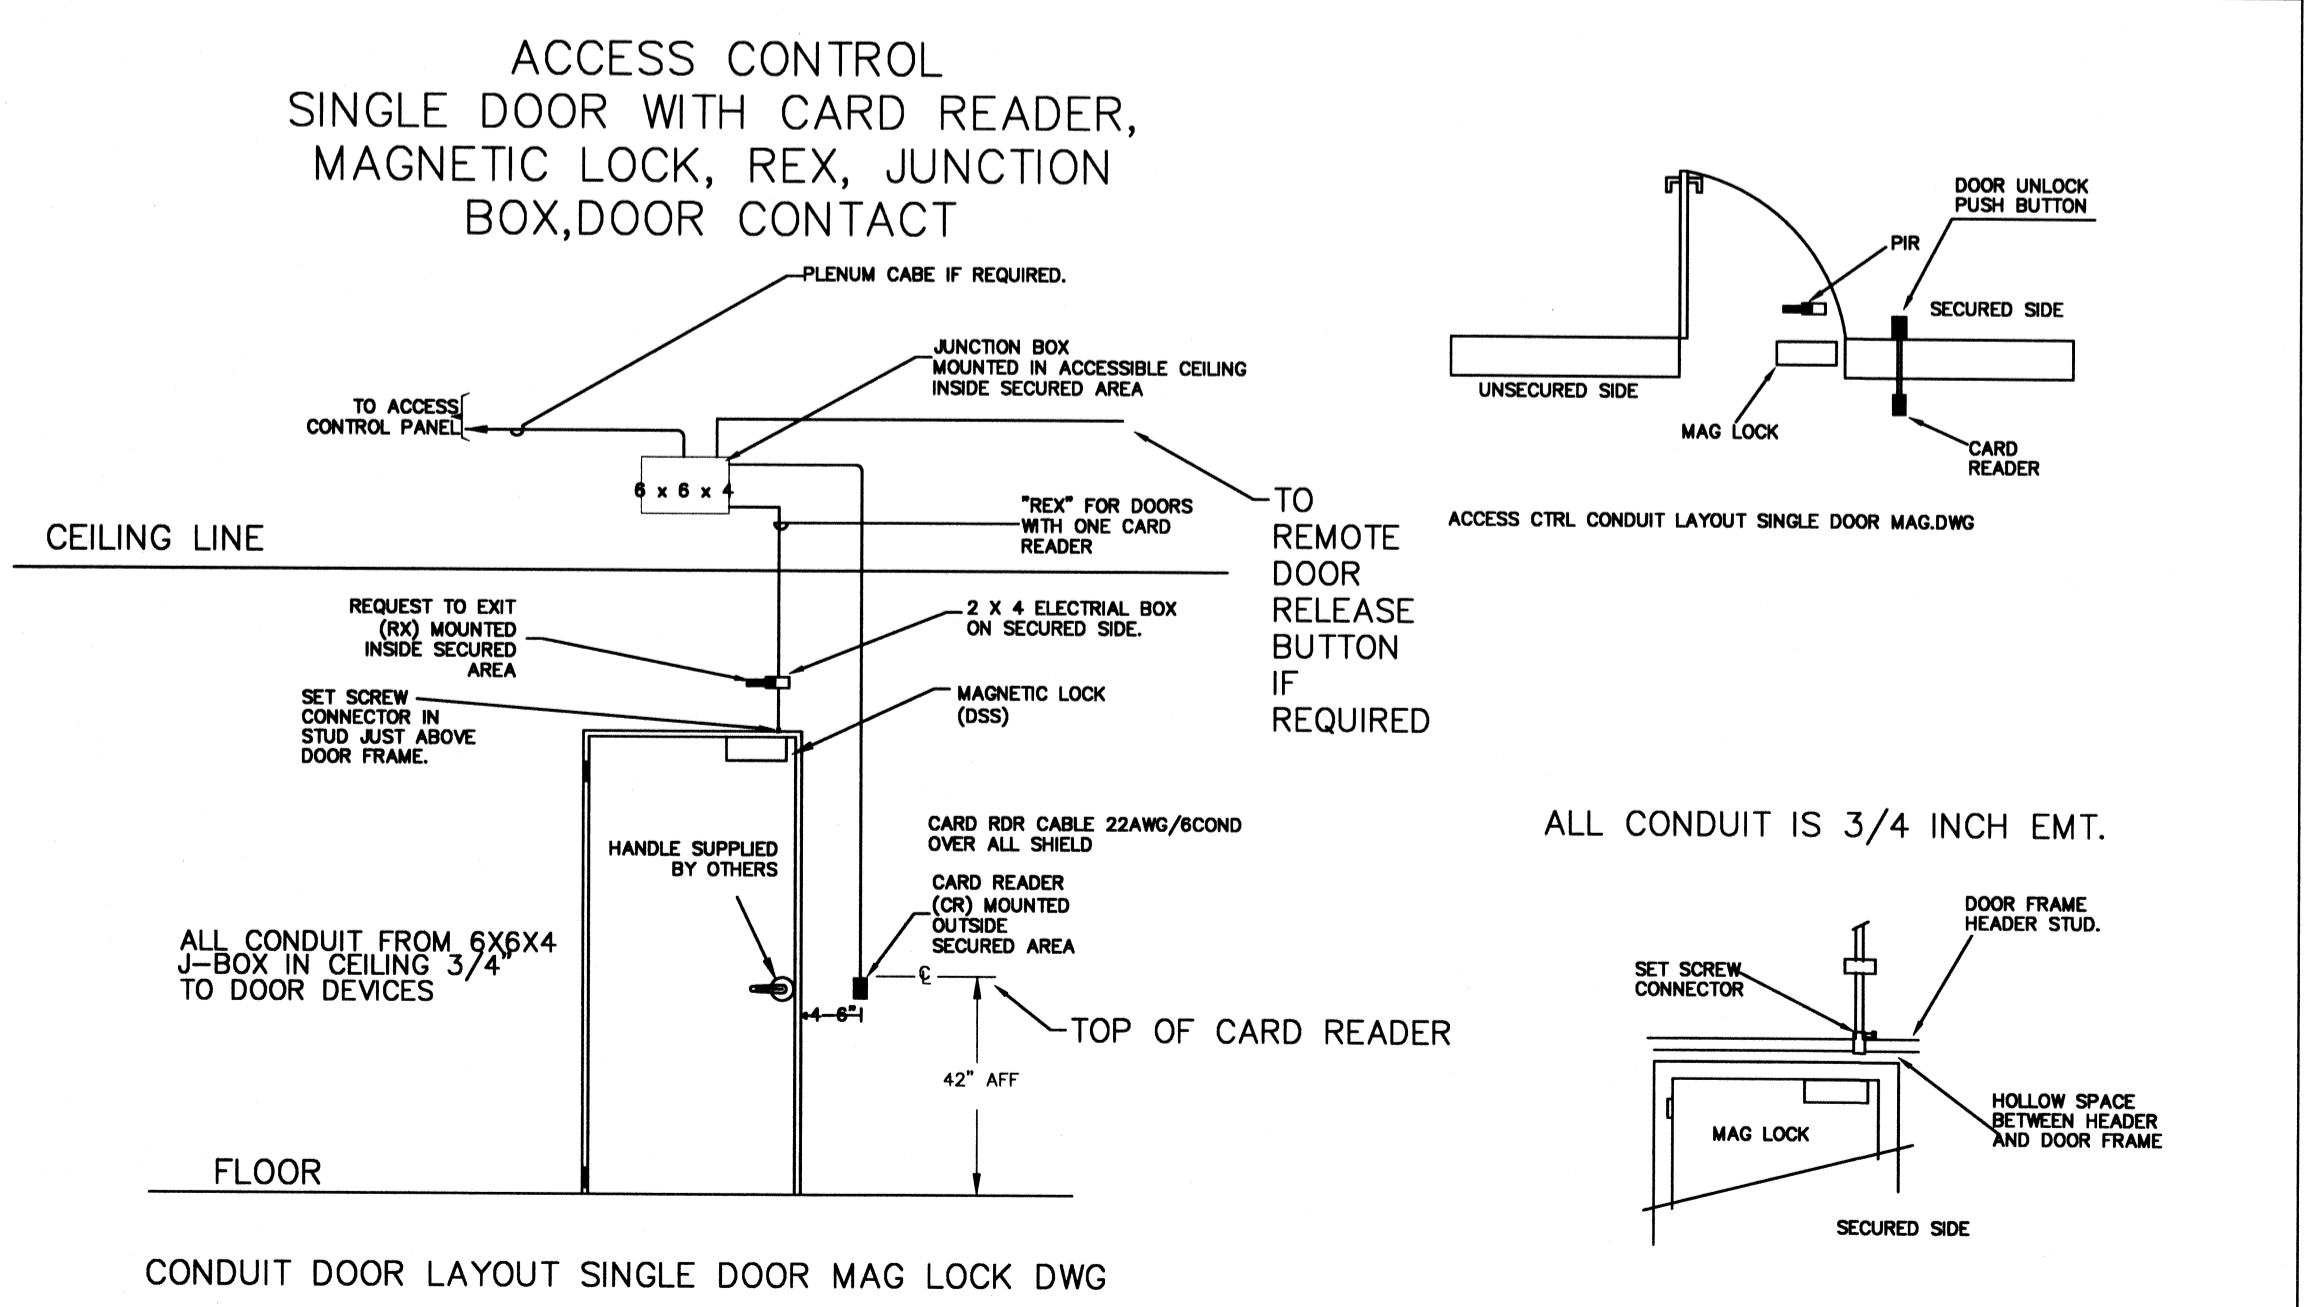

RFP 6 REVISED: 10/17/08 ab  
 STAR HVAC REVISED: 05/29/08 ab  
 HVAC REVISED: 02/26/08 ab  
 HVAC REVISED: 11/05/07 ab  
 REVISED: 01/23/07

**RFP #2 11-13-07**