


LEGEND

- NEW DUPLEX RECEPTACLE
- EXHAUST FAN
- ▲ SECURITY ACCESS DOOR (SCANNER BY OTHERS)
- ▽ COMM @ DATA
- Ⓜ COLUMN MOUNTED UTILITY
- Ⓢ POWER AND COMM POLE
- Ⓢ SINGLE POLE SWITCH
- Ⓢ THREE-WAY SWITCH
- Ⓢ EXIT LIGHT FIXTURE (BATTERY BACK UP)
- ▲ SECURITY ACCESS DOOR (SCANNER BY OTHERS)
- ≡ TWO TUBE 4' FLOURESCENT
- Ⓢ OUTSIDE FLOOD WORK LIGHTS 120/240 V 250W HPS W/ BATTERY BACKUP

NOTES


ALL NEW POWER PANELS ARE TO BE MOUNTED ON THE NORTH WALL OF THE MECHANICAL ROOMS

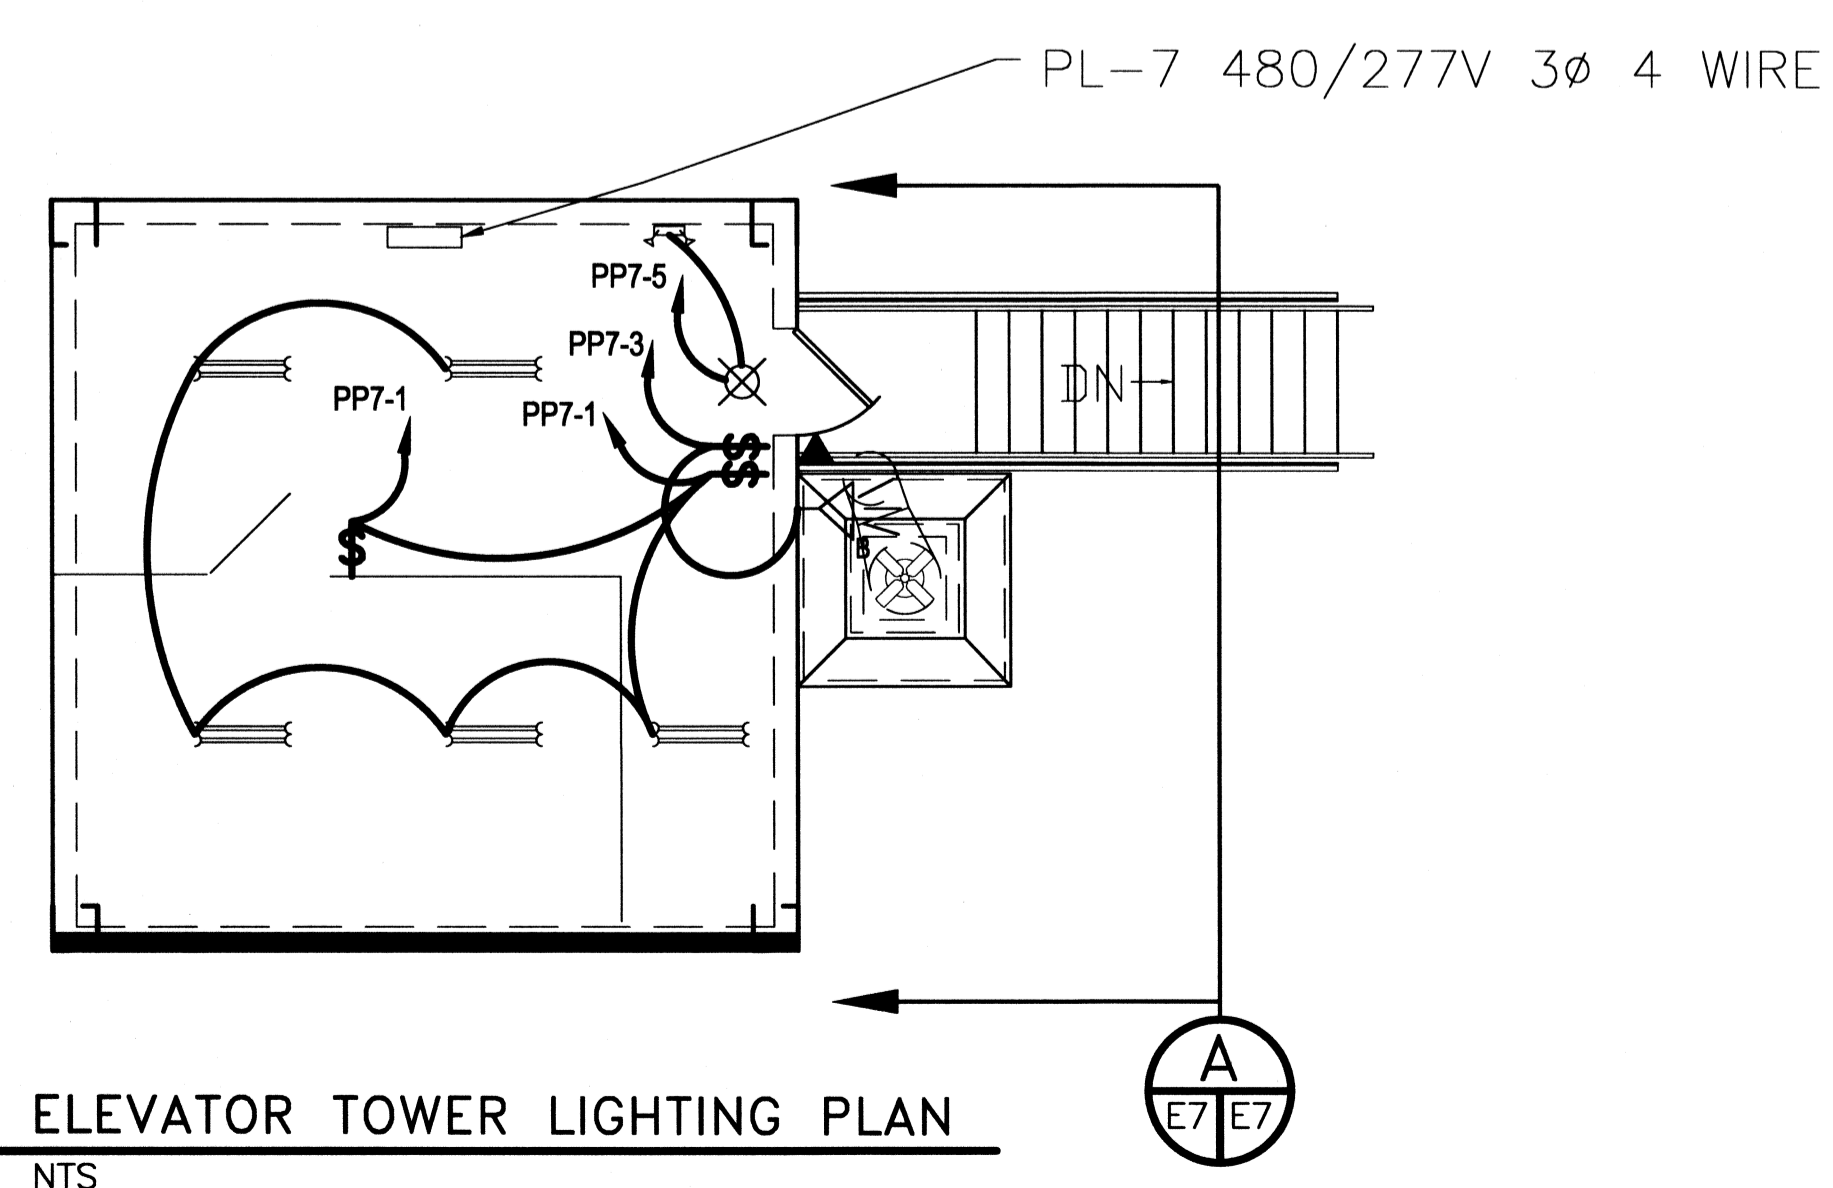

ELEVATOR TOWER LIGHTING PLAN
NTS

ROOF ELECTRICAL PLAN
SCALE: 1/8" = 1'-0"

☁ -INDICATES ITEMS CHANGED- 02/26/08

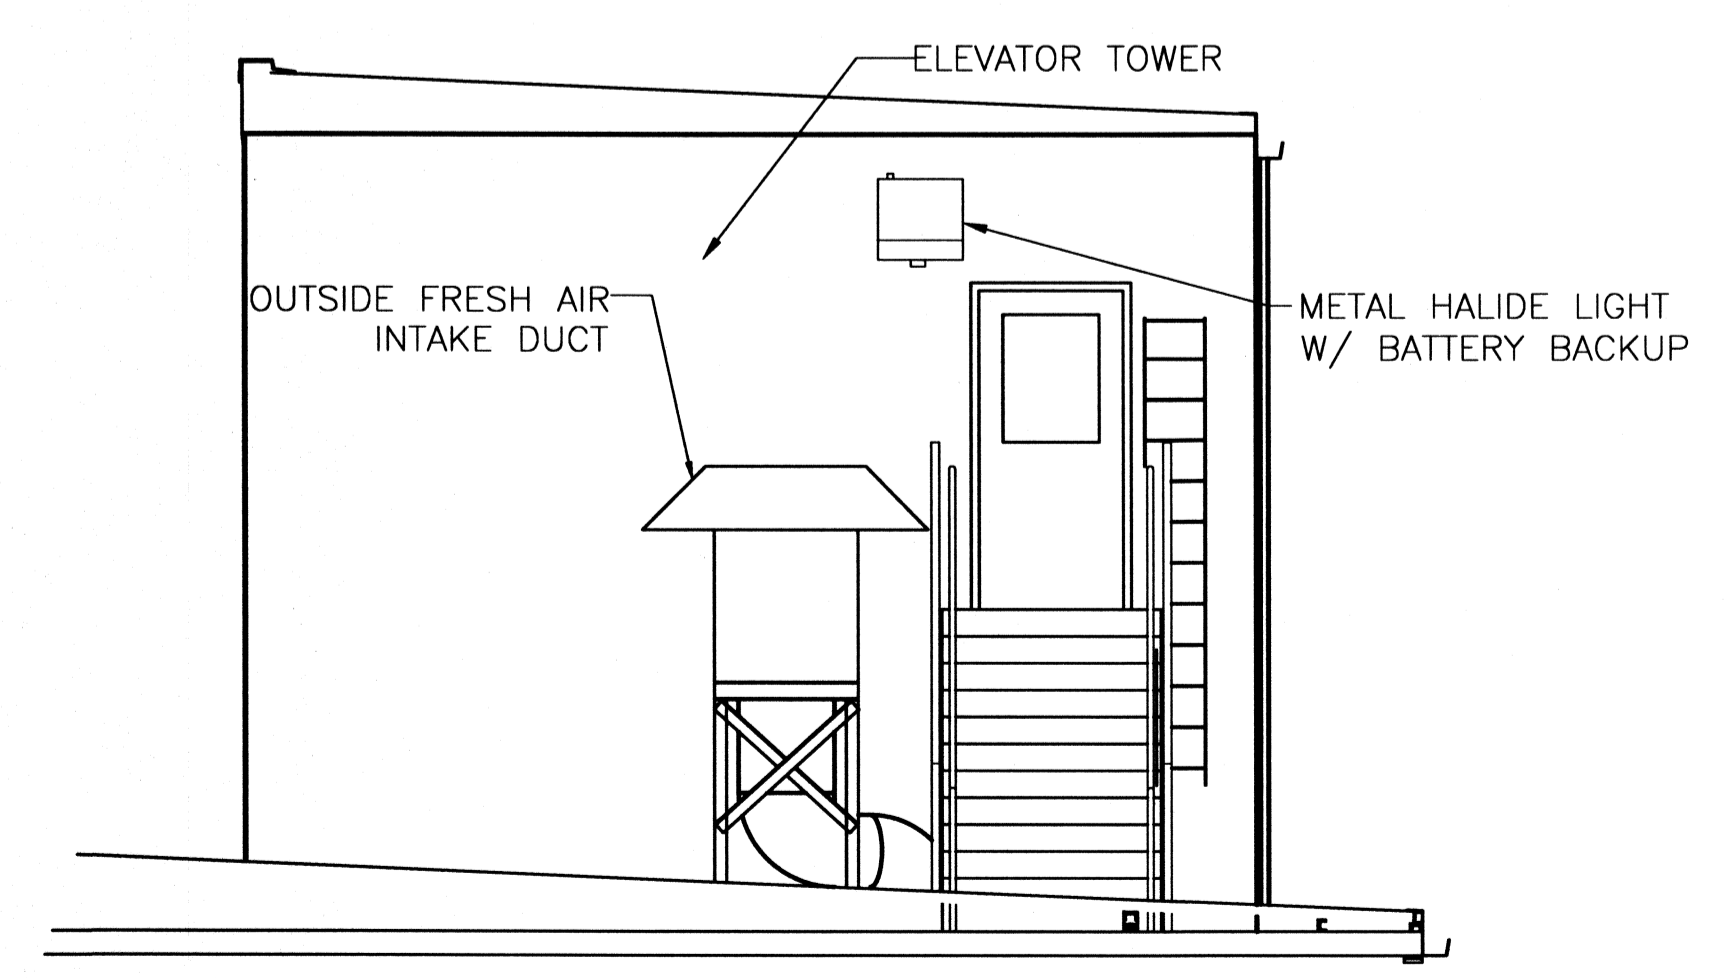

SECTION
SCALE: 1/4" = 1'-0"

HVAC REVISED: 02/26/08ob
HVAC REVISED: 11/05/07ab
REVISED: 05/17/07ab
REVISED: 05/07/07ab
REVISED: 03/07/07ab

ROOF ELECTRICAL PLAN
 ST. TAMMANY PARISH ADMIN. COMPLEX
 520 OLD SPANISH TRAIL
 SLIDELL, LOUISIANA

RENOVATE OFFICE BUILDING
DAMMON ENGINEERING, INC.
 1095 FLORIDA AVENUE 985-649-5832 SLIDELL, LA. 70458
 DAMMONENGINEERING.COM

SCALE: AS NOTED

FILE:

JOB NO. 1729

DATE: 1-8-07

SHEET

E7

OF