

# FINISH SCHEDULE

ROOM	ROOM #	FLOOR	BASE	WALLS				CEILING		NOTES
				NORTH	EAST	SOUTH	WEST	MATERIAL	HEIGHT	
ENTRY	101	LVT	RB	PTGB	PTGB	PTGB	PTGB	PTGB	8'-0"	
DAY ROOM	102	LVT	RB	PTGB	PTGB	PTGB	PTGB	PTGB	8'-10 1/2"	
CAPTAIN	103	LVT	RB	PTGB	PTGB	PTGB	PTGB	PTGB	8'-10 1/2"	
ANTE ROOM	104	LVT	RB	PTGB	PTGB	PTGB	PTGB	PTGB	8'-0"	
IT CLOSET	105	LVT	RB	PTGB	PTGB	PTGB	PTGB	PTGB	8'-10 1/2"	
WOMEN'S TOILET	107	CT	CT	PTMRGB	PTMRGB	PTMRGB	PTGB	PTGB	8'-10 1/2"	
CAPTAIN	108	LVT	RB	PTGB	PTGB	PTMRGB	PTGB	PTGB	8'-10 1/2"	
MENS TOILET	110	CT	CT	PTMRGB	PTMRGB	PTMRGB	PTMRGB	PTMRGB	8'-8"	
MENS SHOWER	111	CT	CT	PTMRGB	PTMRGB	PTMRGB	PTMRGB	PTMRGB	8'-8"	
BUNK ROOM	112	LVT	RB	PTGB	PTGB	PTGB	PTGB	PTGB	8'-10 1/2"	
DINING ROOM	116	LVT	RB	PTGB	PTGB	PTGB	PTGB	PTGB	8'-10 1/2"	
KITCHEN	117	LVT	RB	PTGB	PTGB	PTGB	PTGB	PTGB	8'-10 1/2"	
APPARATUS BAYS	118	EP	C	MLP	MLP	MLP	MLP	MLP	VARIES	
UTILITY ROOM	119	EP	C	PTAGB	PTAGB	PTAGB	PTAGB	PTGB	8'-10 1/2"	
MAINTENANCE BAY	120	EP	C	NA	PTMRGB	PTMRGB	PTAGB	PTGB	12'-10 3/4"	
STORAGE	121	EP	C	PTMRGB	PTMRGB	PTMRGB	PTMRGB	PTMRGB	8'-10 1/2"	
REST ROOM	122	EP	C	PTMRGB	PTMRGB	PTMRGB	PTMRGB	PTMRGB	8'-10 1/2"	
GEAR ROOM	123	EP	C	PTMRGB	PTMRGB	PTMRGB	PTMRGB	PTMRGB	12'-10 3/4"	
MECH ELEC	124	CONC	C	PTMRGB	PTMRGB	PTMRGB	PTMRGB	PTMRGB	12'-10 3/4"	
MEZZANINE	201	PT	WD	PTMRGB	PTMRGB	PTMRGB	PTMRGB	PTMRGB	VARIES	
STORAGE MEZZANINE	202	PT	WD	PTMRGB	PTMRGB	PTMRGB	PTMRGB	PTMRGB	VARIES	

# TOILET ACCESSORY SCHEDULE

MK	DESCRIPTION	MFR	MODEL #	DIMENSIONS	MTG HT	NOTES
GB1	36" GRAB BAR	BRADLEY	812	1 1/2"Øx36"	34" - 36"	
GB2	42" GRAB BAR	BRADLEY	812	1 1/2"Øx42"	34" - 36"	
H1	ROBE HOOK	BRADLEY	932	2 1/8" x 5/8"	60"	
M1	CHANNEL-FRAME MIRROR	BRADLEY	781	24" x 36"	40"	MEASURE TO REFLECTIVE SURF.
PT1	TOWEL DISPENSER	BRADLEY	2441-11	13" x 17" x 4"	48"	SURFACE MOUNTED
R1	SHOWER CURTAIN ROD	BRADLEY	9539	1 1/4"Øx36"	72"	
R2	SHOWER CURTAIN ROD	BRADLEY	9539	1 1/4"Øx60"	72"	
TP1	TOILET TISSUE DISPENSER	BRADLEY	9539	13" x 2" x 4"	SEE ELEV	

### FINISH LEGEND:

- PTGB PAINTED GYPSUM WALL BOARD
- PTMRGB PAINTED MOISTURE RESISTANT GYPSUM WALL BOARD
- PTABGB PAINTED ABUSE/MOISTURE RESISTANT GYPSUM WALL BOARD
- RB RUBBER BASE
- CTB CERAMIC/PORCELAIN TILE BASE
- CB CEMENTITIOUS BASE
- WD WOOD BASE (PAINTED)
- LVT LUXURIOUS VINYL TILE
- CT CERAMIC/PORCELAIN TILE
- EP EPOXY
- CONC CONCRETE (SEALED)
- PT PAINTED
- MLP METAL LINER PANEL

### GENERAL FINISH NOTES:






- WHERE CEMENTITIOUS BASE IS SPECIFIED WITH AN EPOXY FLOOR, INSTALL BASE WITH ROUGH SIDE FACING AWAY FROM WALL.
- APPLY ACRYLIC PAINT (HIGH-PERFORMANCE COATING) TO ABUSE/MOISTURE GYPSUM WALL BOARD. REFER TO FINISH SCHEDULE FOR EXTENTS OF ABUSE/MOISTURE GYPSUM WALL BOARD (PTABGB) INSTALLATION.

### GENERAL FLOOR PLAN NOTES:

- ALL PLUMBING FIXTURES, FURNITURE, AND APPLIANCES THAT ARE SHOWN AS GREYED AND DASHED ARE TO BE OWNER PROVIDED AND NOT IN CONTRACT (NIC) AND ARE SHOWN FOR COORDINATION PURPOSES ONLY. CONTRACTOR TO VERIFY THOSE ITEMS THAT ARE OWNER FURNISHED AND CONTRACTOR INSTALLED (OFCI).

### PARTITION LEGEND

- BEARING PARTITION
- NON-BEARING PARTITION
- FIRE RATED PARTITION - SEE LIFE-SAFETY PLANS FOR FIRE RATINGS

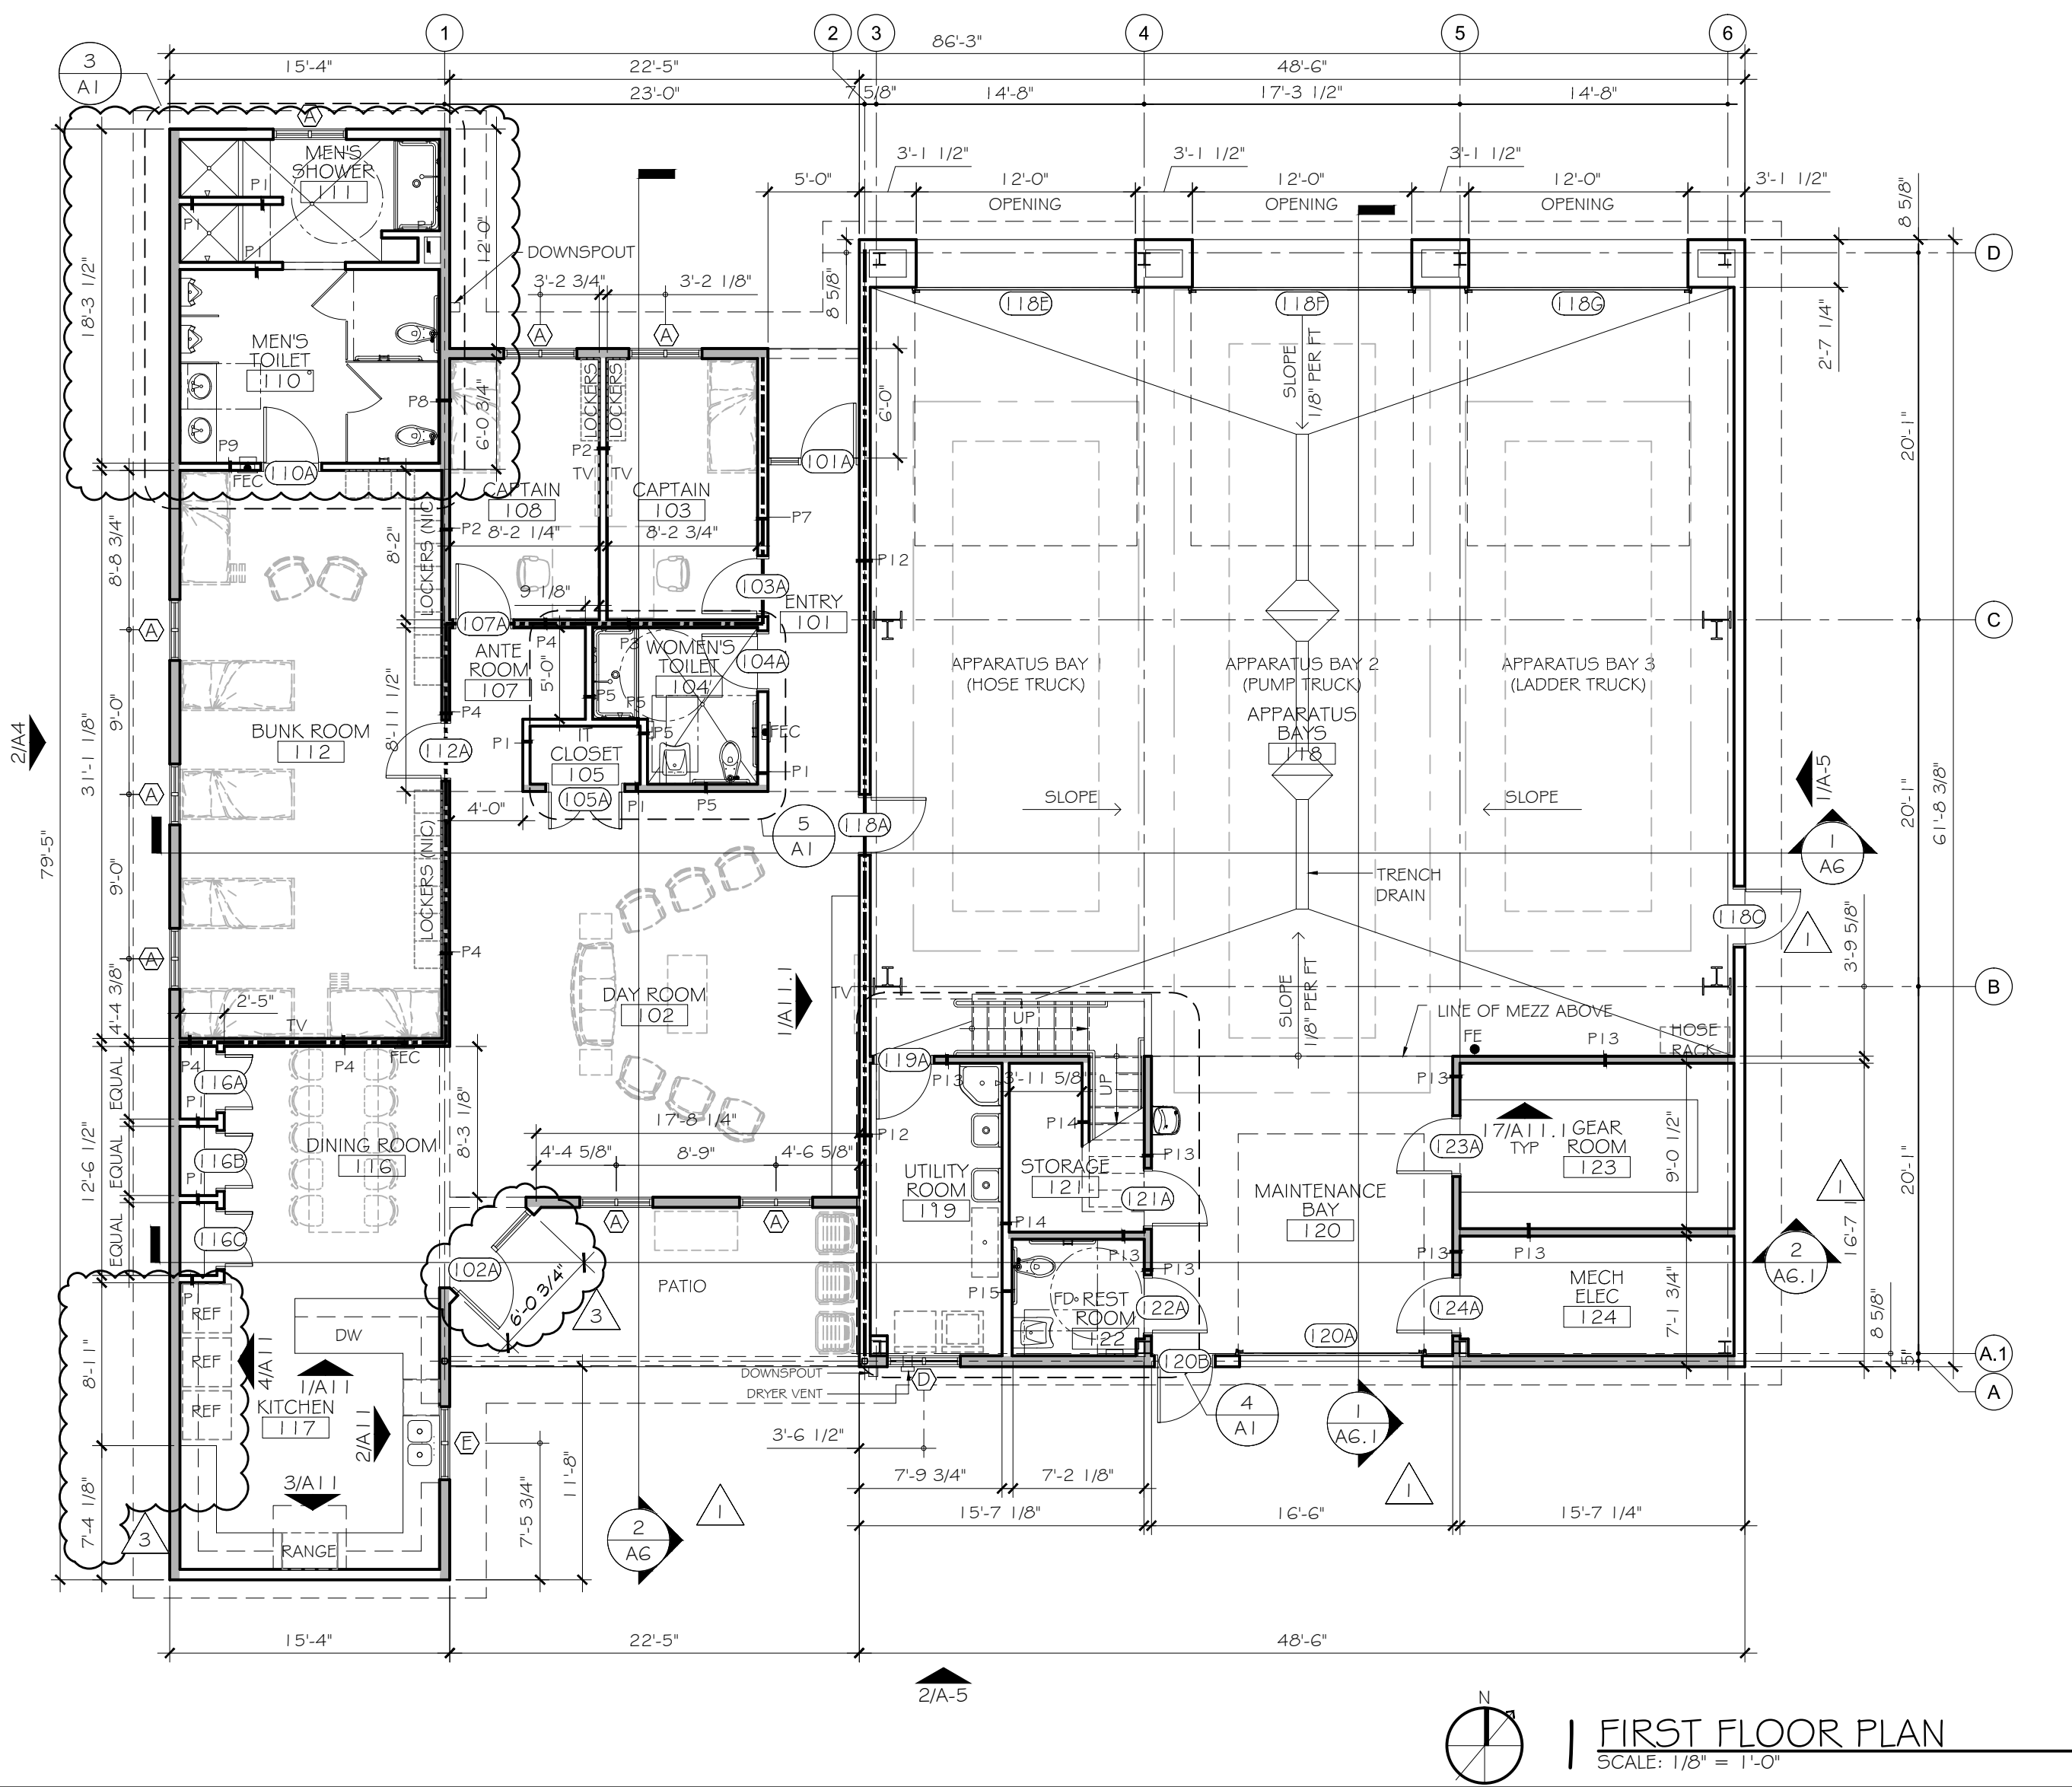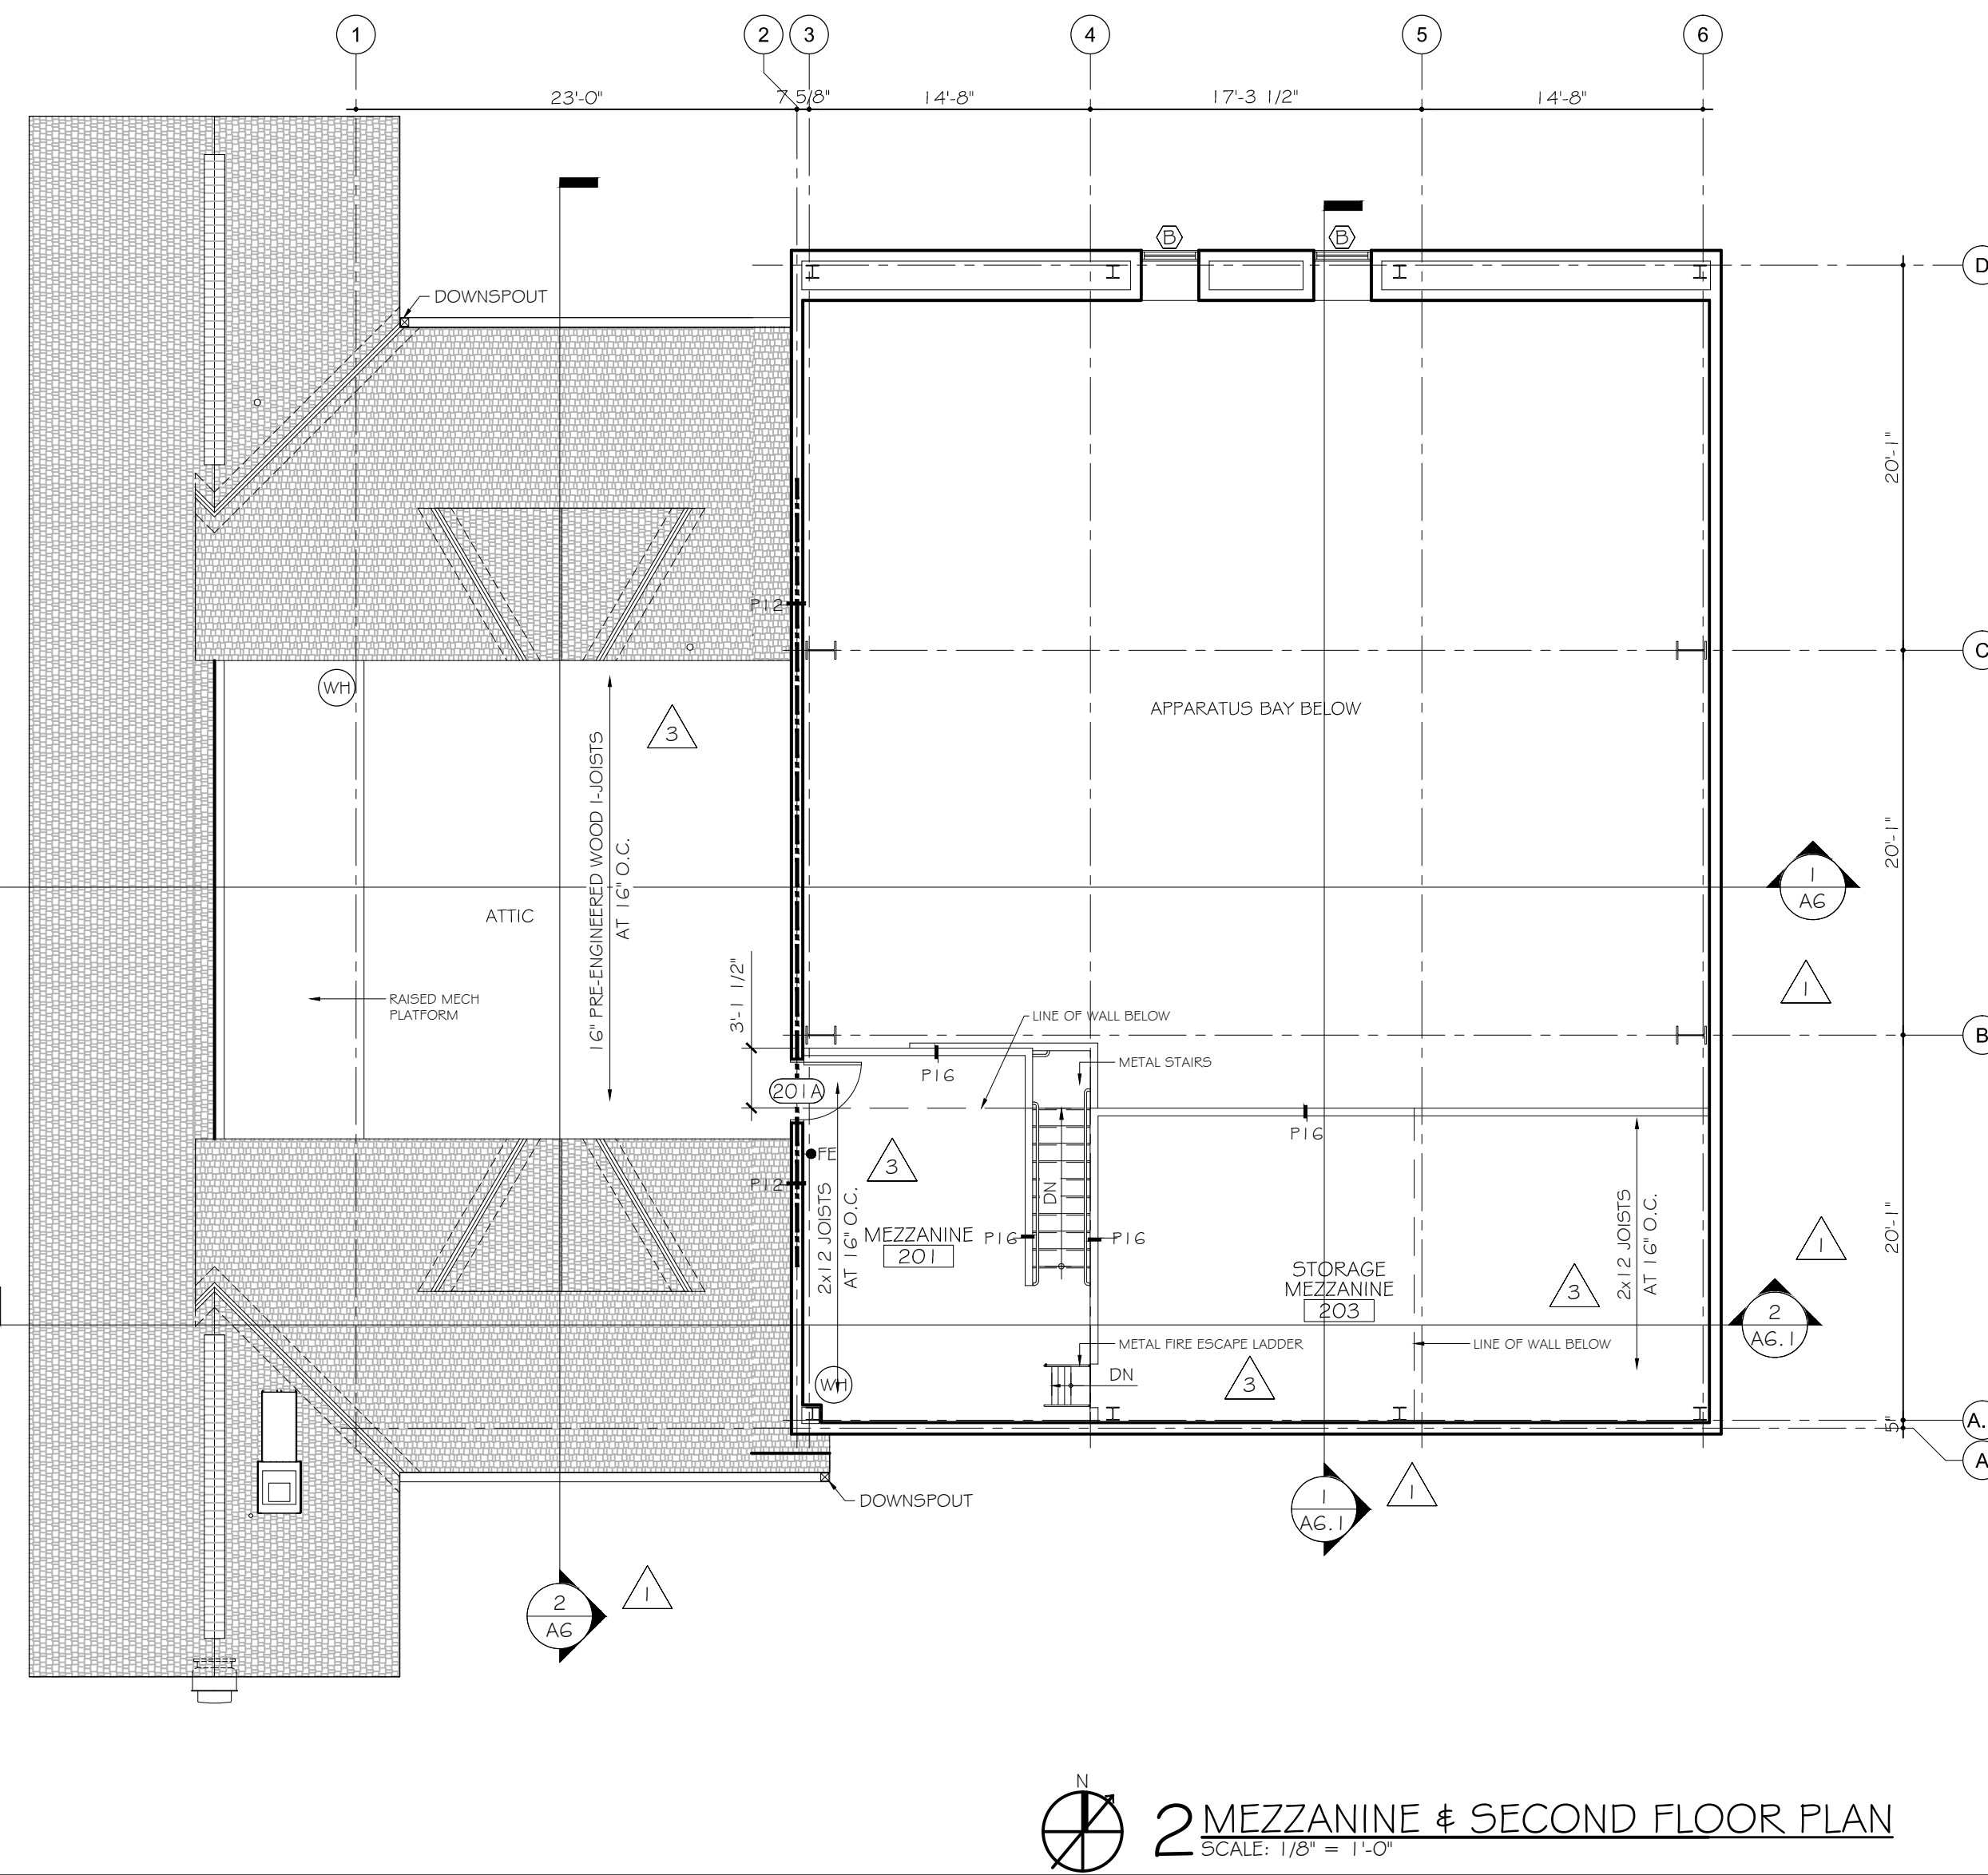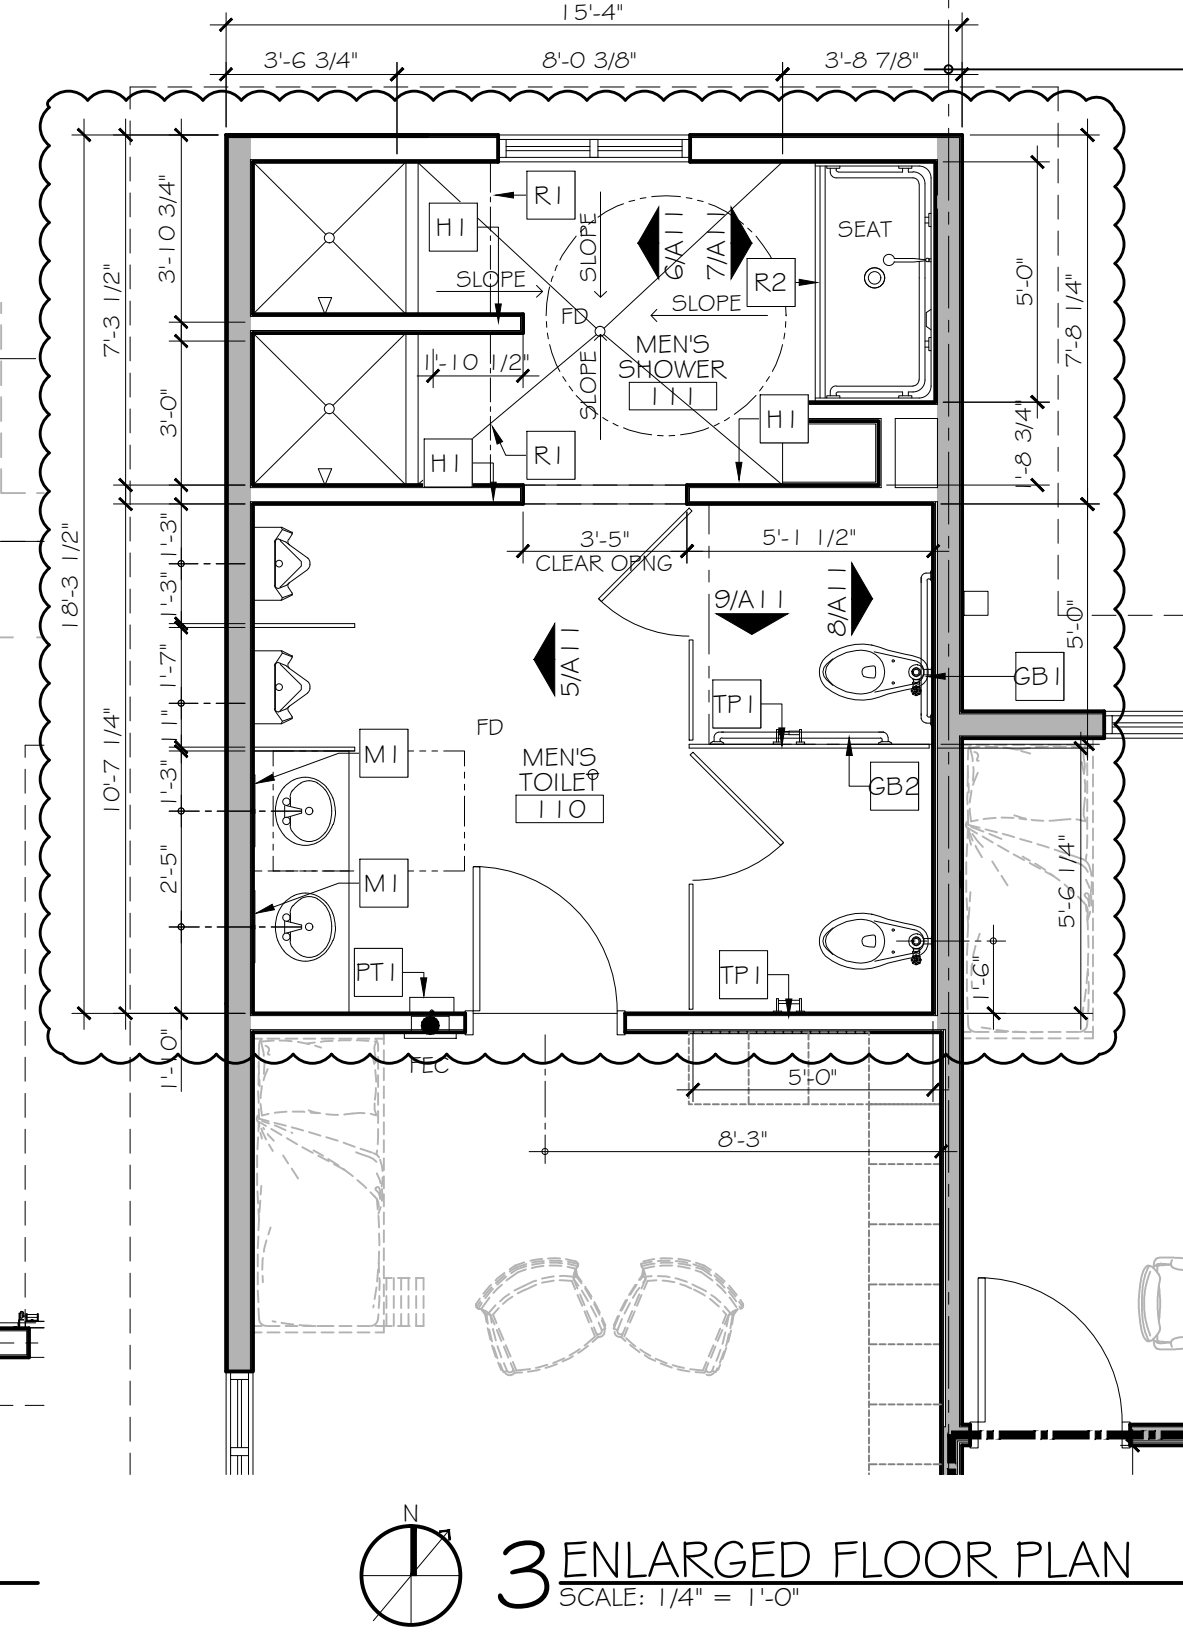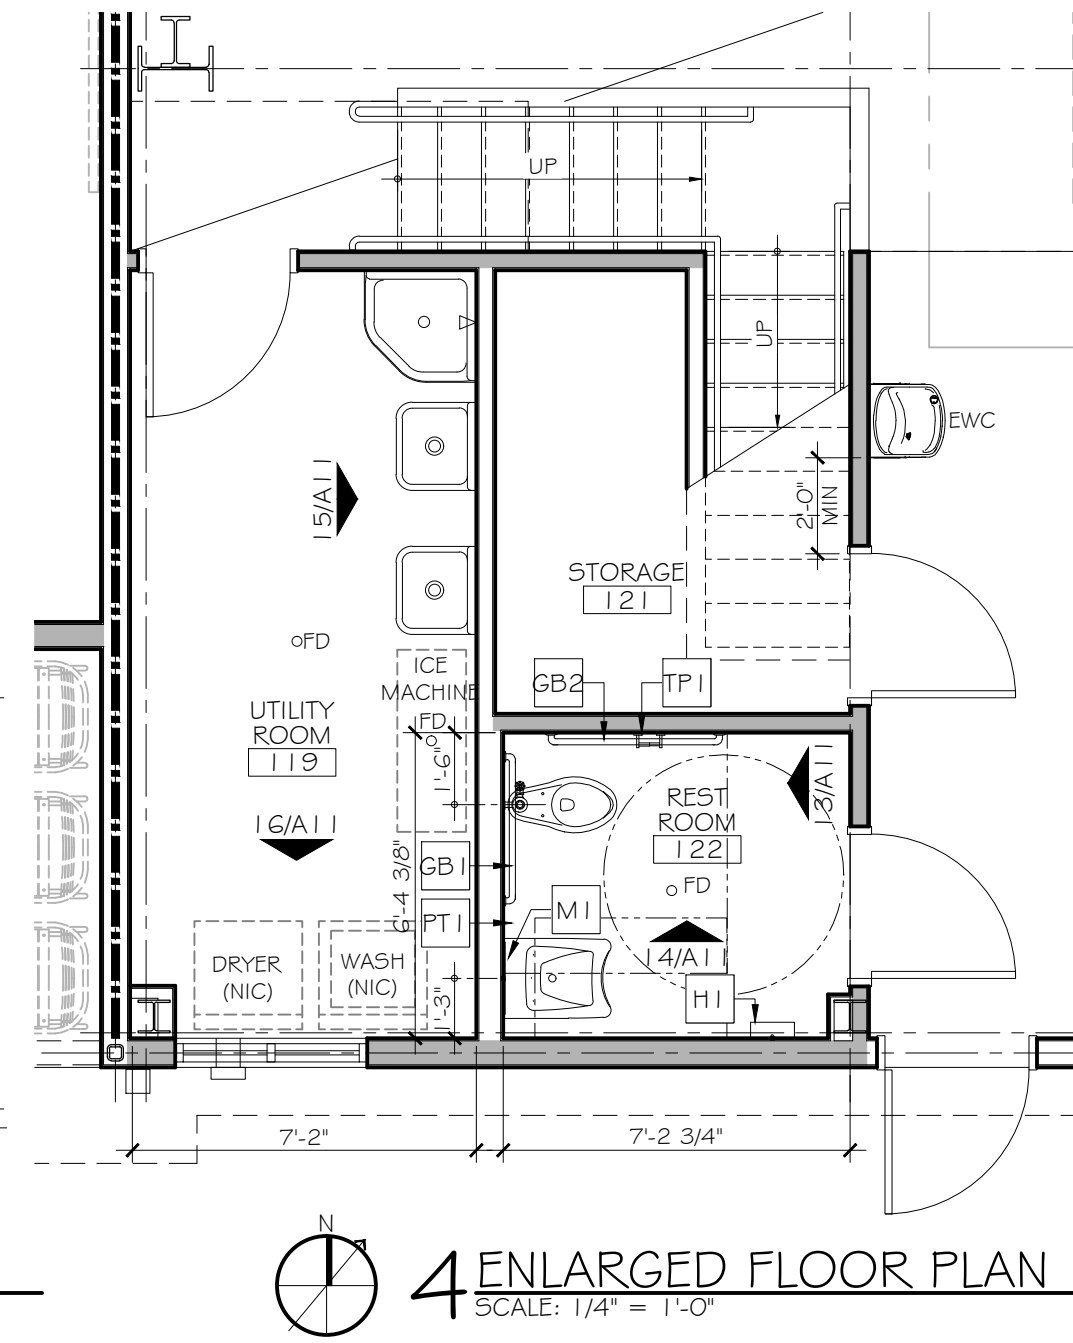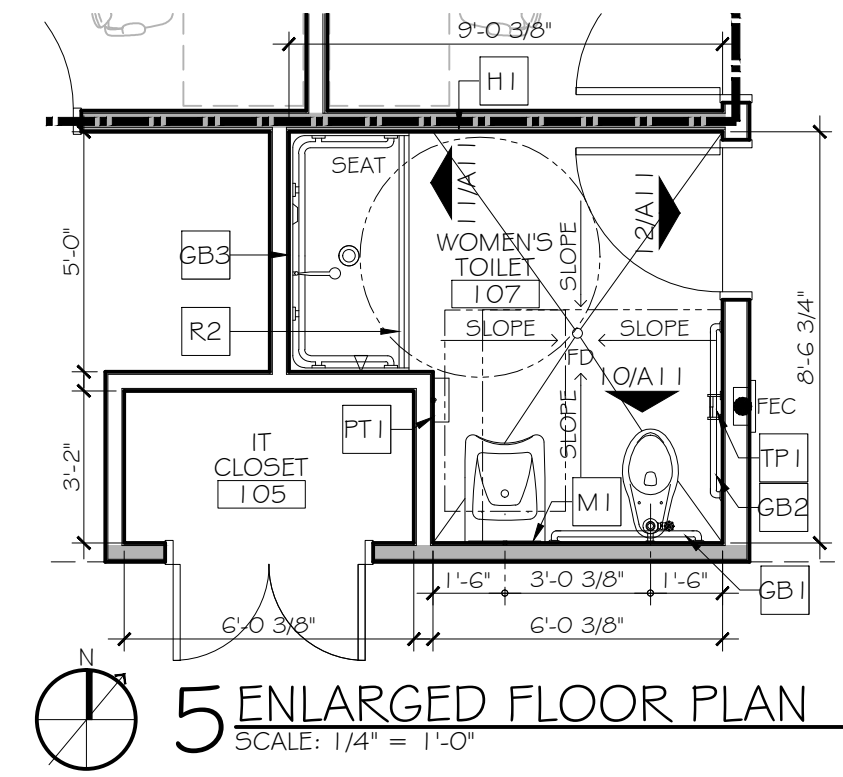

ST. TAMMANY FIRE PROTECTION DISTRICT No 1  
FIRE STATION # 14  
297 STEELE ROAD  
SLIDELL, LA

REVISIONS	DATE
# DESCRIPTION	
1 ADDENDUM 2	5-25-2013
2 ADDENDUM 5	6-3-2013
3 ADDENDUM 6	6-7-2013



FLOOR PLANS & ENLARGED FLOOR PLANS

SHEET No: 10 OF 32

A1

**DAMMON ENGINEERING, INC.**  
Architects & Engineers  
554 OLD SPANISH TRAIL  
SLIDELL, LA 70458  
PHONE: 985-649-5932  
FAX: 985-641-5950

JOB No: 2161 DATE: 4/30/2013  
DRAWN BY: KJK CHECKED BY: KJK