

FILE NAME: A:\1 - Commercial\3100 - New Build\DW - SUDS - 10/2021\DW - SUDS - 10/2021.dwg  
 PLOT DATE: 05/16/2022 11:01:12 AM  
 PLOT SCALE: 1/4" = 1'-0"

**PLUMBING ABBREVIATIONS**


LAV	LAVATORY	W	WASHER MACHINE
WC	WATER CLOSET	WH	WATER HEATER
CB	CATCH BASIN	SH	SHOWER

**PLUMBING LEGEND**

CLEAN OUT	SEWAGE LINE	CATCH BASIN
P-TRAP	VENT LINE	METER
FLOOR DRAIN	GAS LINE	PLUG COCK
	WASTE LINE	COLD WATER
	HOT WATER	GATE VALVE

**DAMMON ENGINEERING, INC.**  
 LOUISIANA & MISSISSIPPI

Chief Engineer: Brian Hirsch, PE  
 554 Old Spanish Trail  
 Slidell, LA 70458  
 www.dammonengineering.com  
 info@dammonengineering.com  
 PH: 985.649.8832

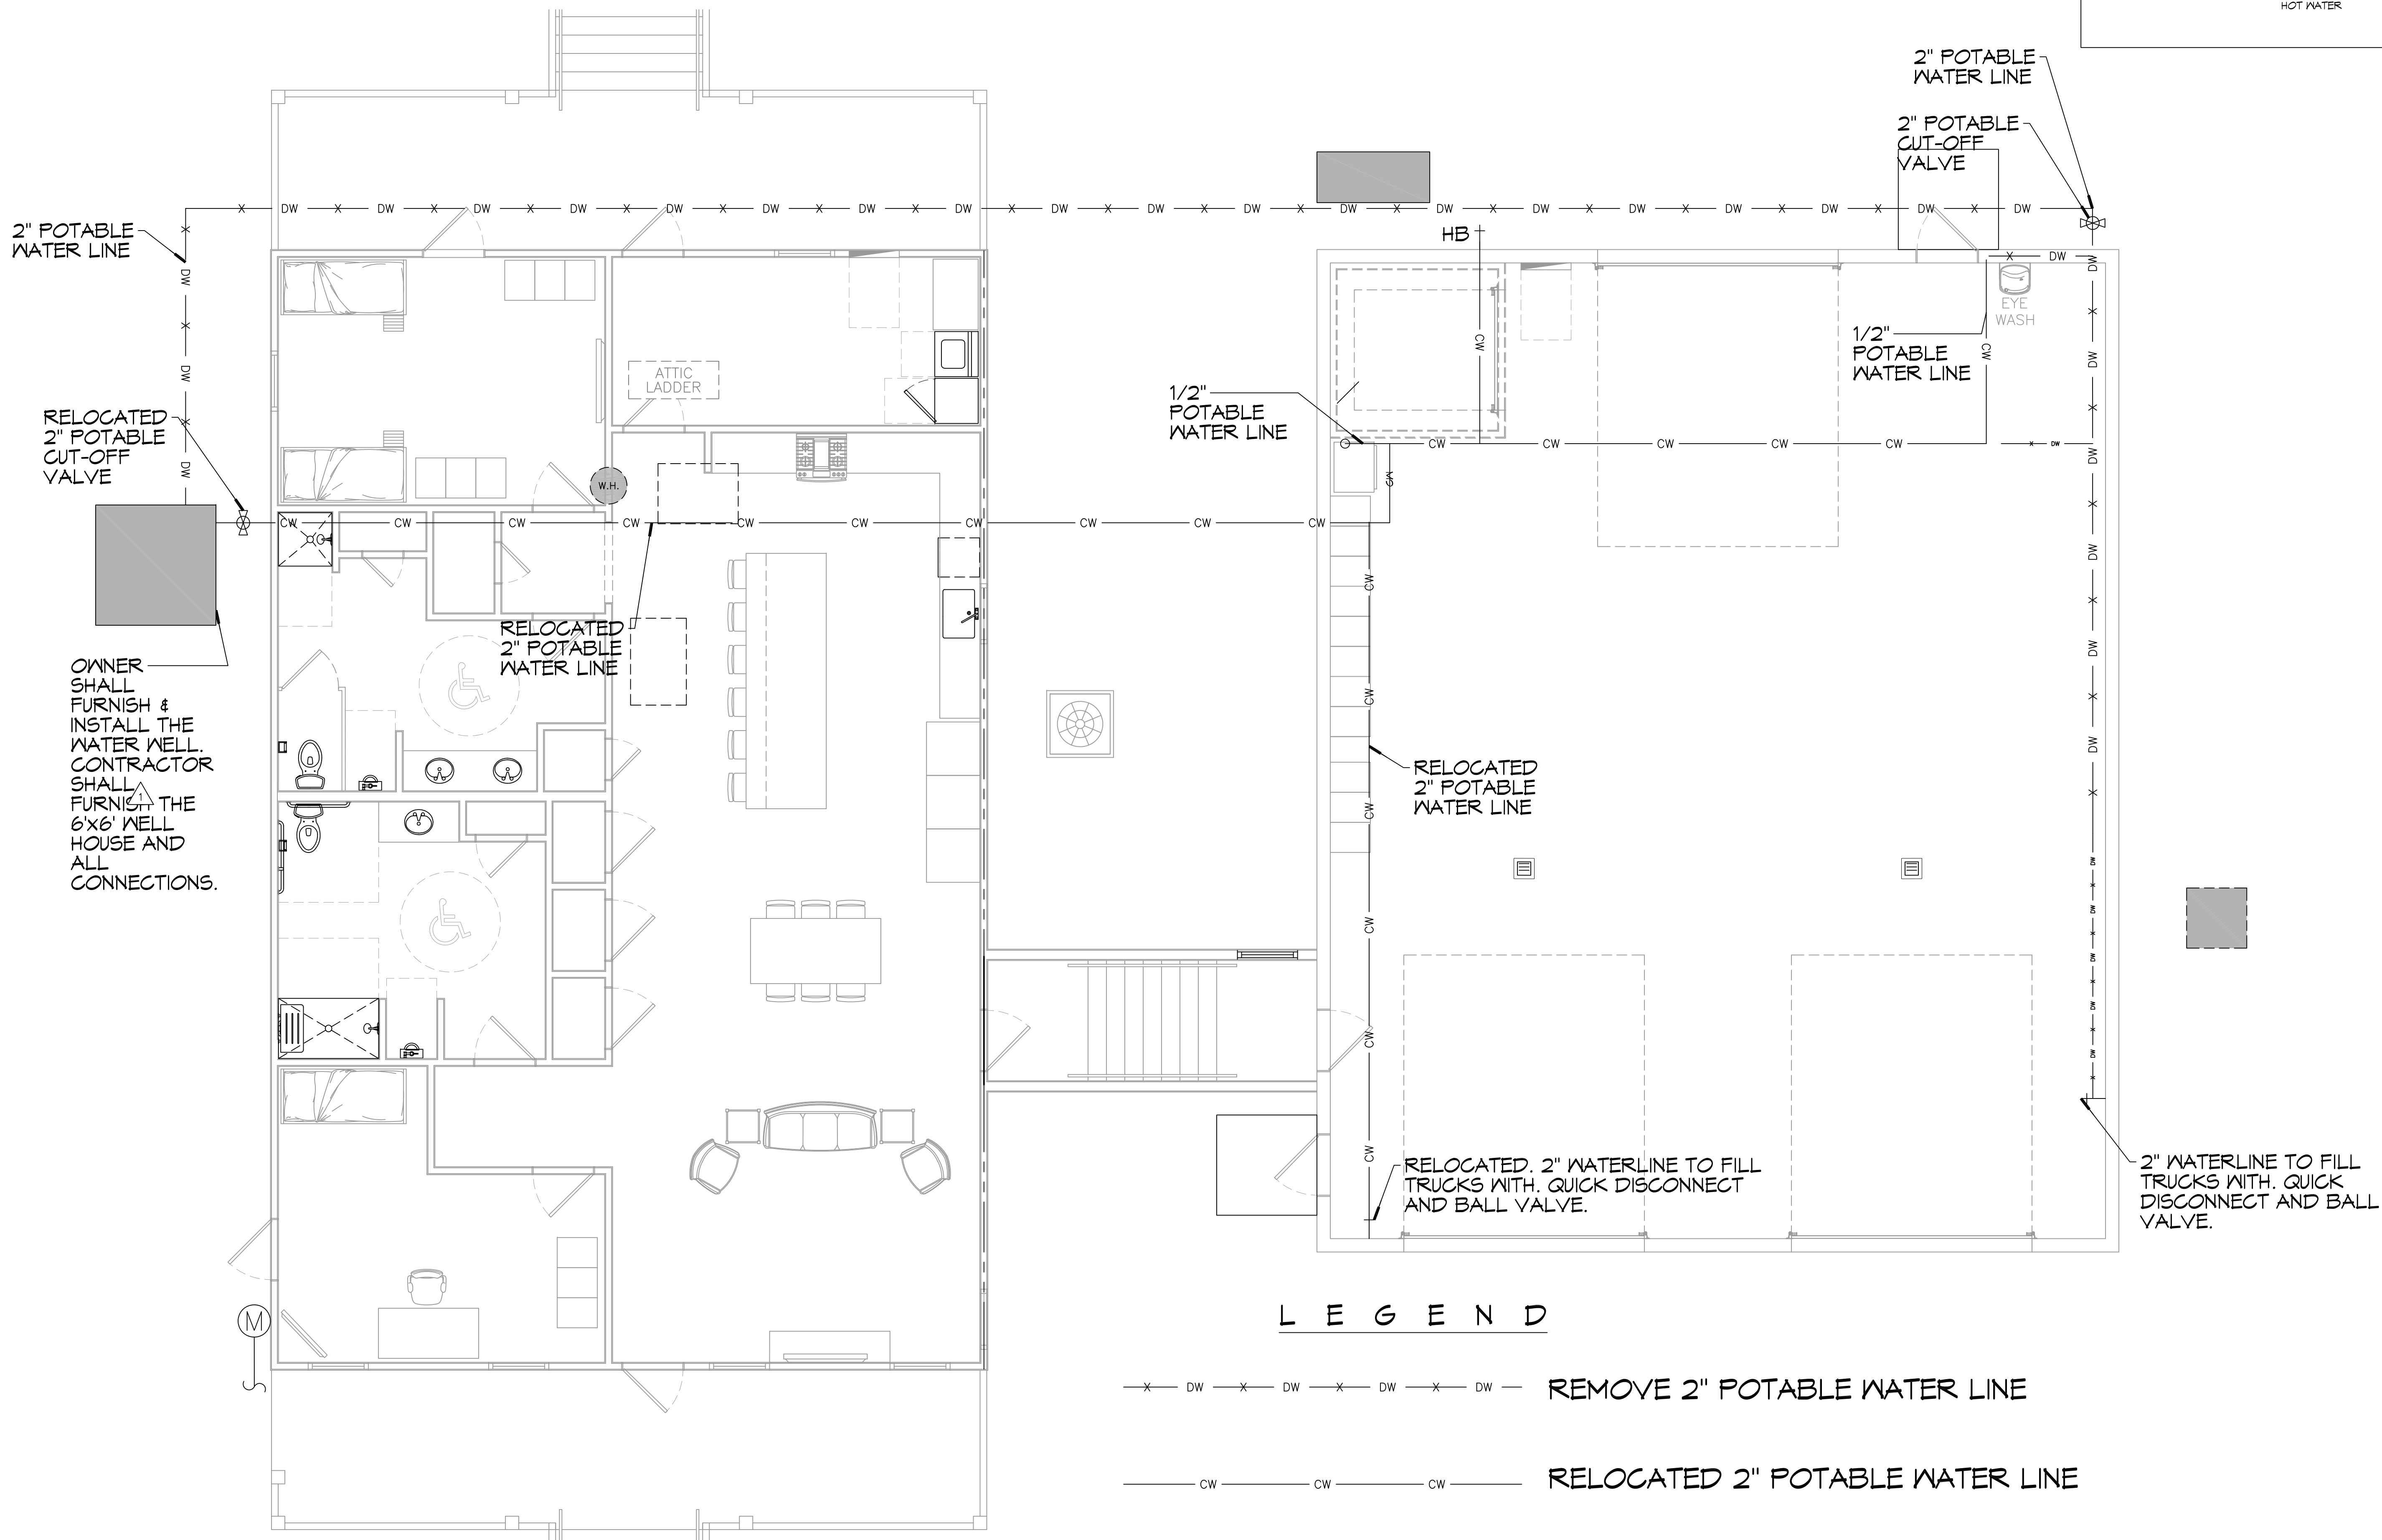

**LEGEND**

--- X DW X DW X DW X DW --- REMOVE 2" POTABLE WATER LINE

— CW — CW — CW — RELOCATED 2" POTABLE WATER LINE

OWNER SHALL FURNISH & INSTALL THE WATER WELL. CONTRACTOR SHALL FURNISH THE 6'x6' WELL HOUSE AND ALL CONNECTIONS.

**39 PLUMBING PLAN**  
SCALE: 1/4" = 1'-0"

#	DESCRIPTION	DATE
1	OWNER SHALL FURNISH WELL AND TREATMENT PLANT	01-28-22
2	RELOCATED TREATMENT PLANT AND WELL	04-08-22

Brian La Stamp Professional.jpg  
9/7/2022

ST. TAMMANY FIRE PROTECTION DISTRICT NO. 1  
**FIRE STATION 19**  
 5704T ALLEN ROAD  
 SLIDELL, LOUISIANA 70461  
 JOB No: 2456  
 DATE: 05-16-2022  
 DRAWN BY: CKD  
 CHECKED BY: JMS

SHEET TITLE:  
PLUMBING PLAN

DRAWING NUMBER:

**P101**