


D:\MISC\A-1\Gammmon\3905 - New West Fire Station, US (2022)\3905 - Fire Station\3905 - Fire Station.dwg, 12/12/22 2:14:44 PM

**PLUMBING ABBREVIATIONS**

LAV LAVATORY  
 WC WATER CLOSET  
 CB CATCH BASIN  
 W WASHER MACHINE  
 WH WATER HEATER  
 SH SHOWER

**PLUMBING LEGEND**

CLEAN OUT  
 P-TRAP  
 FLOOR DRAIN  
 SEWAGE LINE  
 VENT LINE  
 GAS LINE  
 WASTE LINE  
 CATCH BASIN  
 METER  
 PLUG COCK

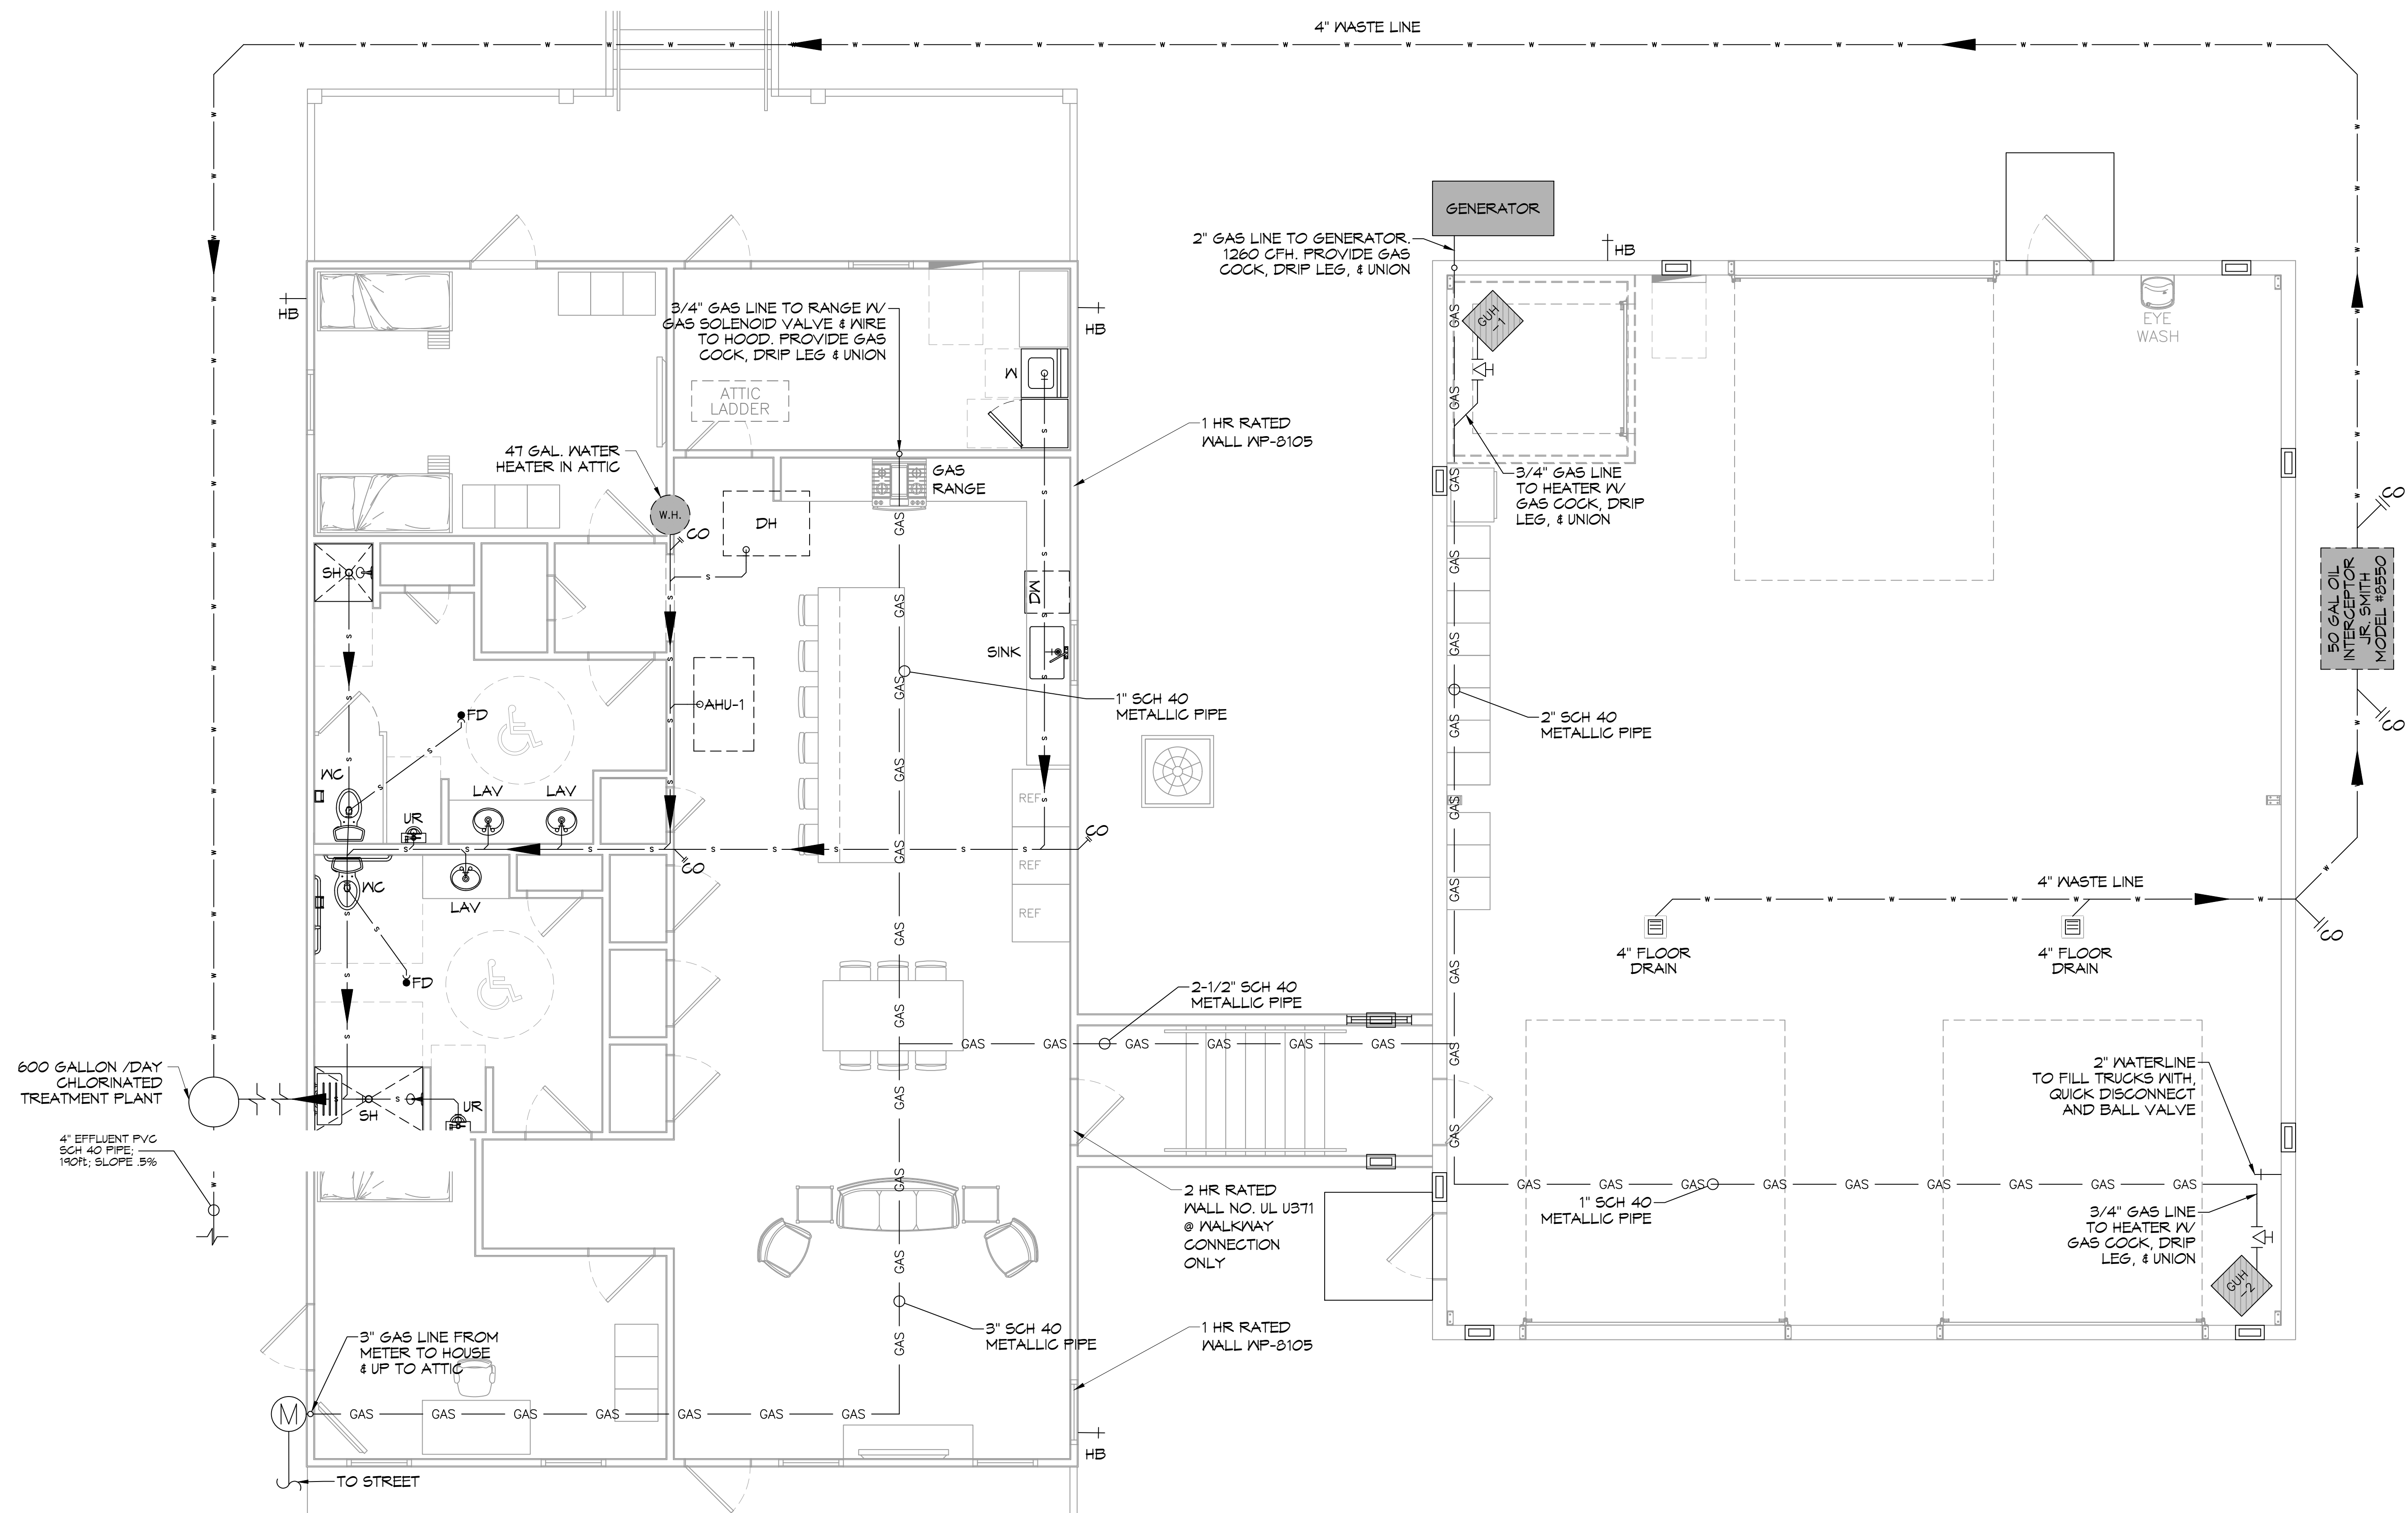


**39 PLUMBING PLAN**  
SCALE: 1/4" = 1'-0"

**DAMMON ENGINEERING, INC.**  
LOUISIANA & MISSISSIPPI

Chief Engineer: Brian Misch, PE  
 554 Old Spanish Trail  
 Slidell, LA 70458  
 www.dammonengineering.com  
 info@dammonengineering.com  
 PH: 985.649.8832

#	DESCRIPTION	DATE

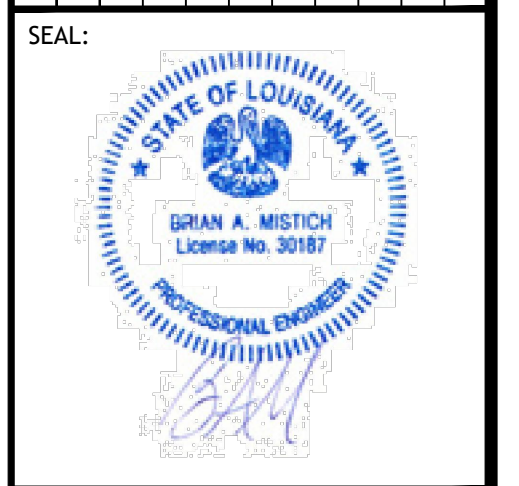

ST. TAMMANY FIRE PROTECTION DISTRICT NO. 1  
**FIRE STATION 19**  
 57041 ALLEN ROAD  
 SLIDELL, LOUISIANA 70461  
 JOB No: 2456  
 DATE: 09-12-2022  
 DRAWN BY: CKD  
 CHECKED BY: JMS

SHEET TITLE:  
 PLUMBING PLAN  
 DRAWING NUMBER:  
**P101**  
 SHEET No: 22 of 24