

D:\E_M\A1 - Dammon\3048 - Allen Road Fire Station 19\3048.dwg - Purshin Purosh - 07/25/22 11:04 AM

PLUMBING ABBREVIATIONS

LAV	LAVATORY	W	WASHER MACHINE
WC	WATER CLOSET	WH	WATER HEATER
CB	CATCH BASIN	SH	SHOWER

PLUMBING LEGEND

	CLEAN OUT		SEWAGE LINE		CATCH BASIN
	P-TRAP		VENT LINE		METER
	FLOOR DRAIN		GAS LINE		PLUG COCK
			WASTE LINE		COLD WATER
			HOT WATER		GATE VALVE

DAMMON ENGINEERING, INC.
 LOUISIANA & MISSISSIPPI
 Chief Engineer: Brian Misch, PE
 554 Old Spanish Trail
 Slidell, LA 70458
 www.dammonengineering.com
 info@dammonengineering.com
 PH: 985.649.8832


REVISIONS

#	DESCRIPTION	DATE
1	OWNER SHALL FURNISH WELL AND TREATMENT PLANT	07-25-22

SEAL:

ST. TAMMANY FIRE PROTECTION DISTRICT NO. 1
FIRE STATION 19
 57047 ALLEN ROAD
 SLIDELL, LOUISIANA 70461
 JOB No.: 2456
 DATE: 05-16-2022
 DRAWN BY: JMS
 CHECKED BY: KCD

SHEET TITLE:
 PLUMBING PLAN
 DRAWING NUMBER:
P101
 SHEET No.: 23 of 30

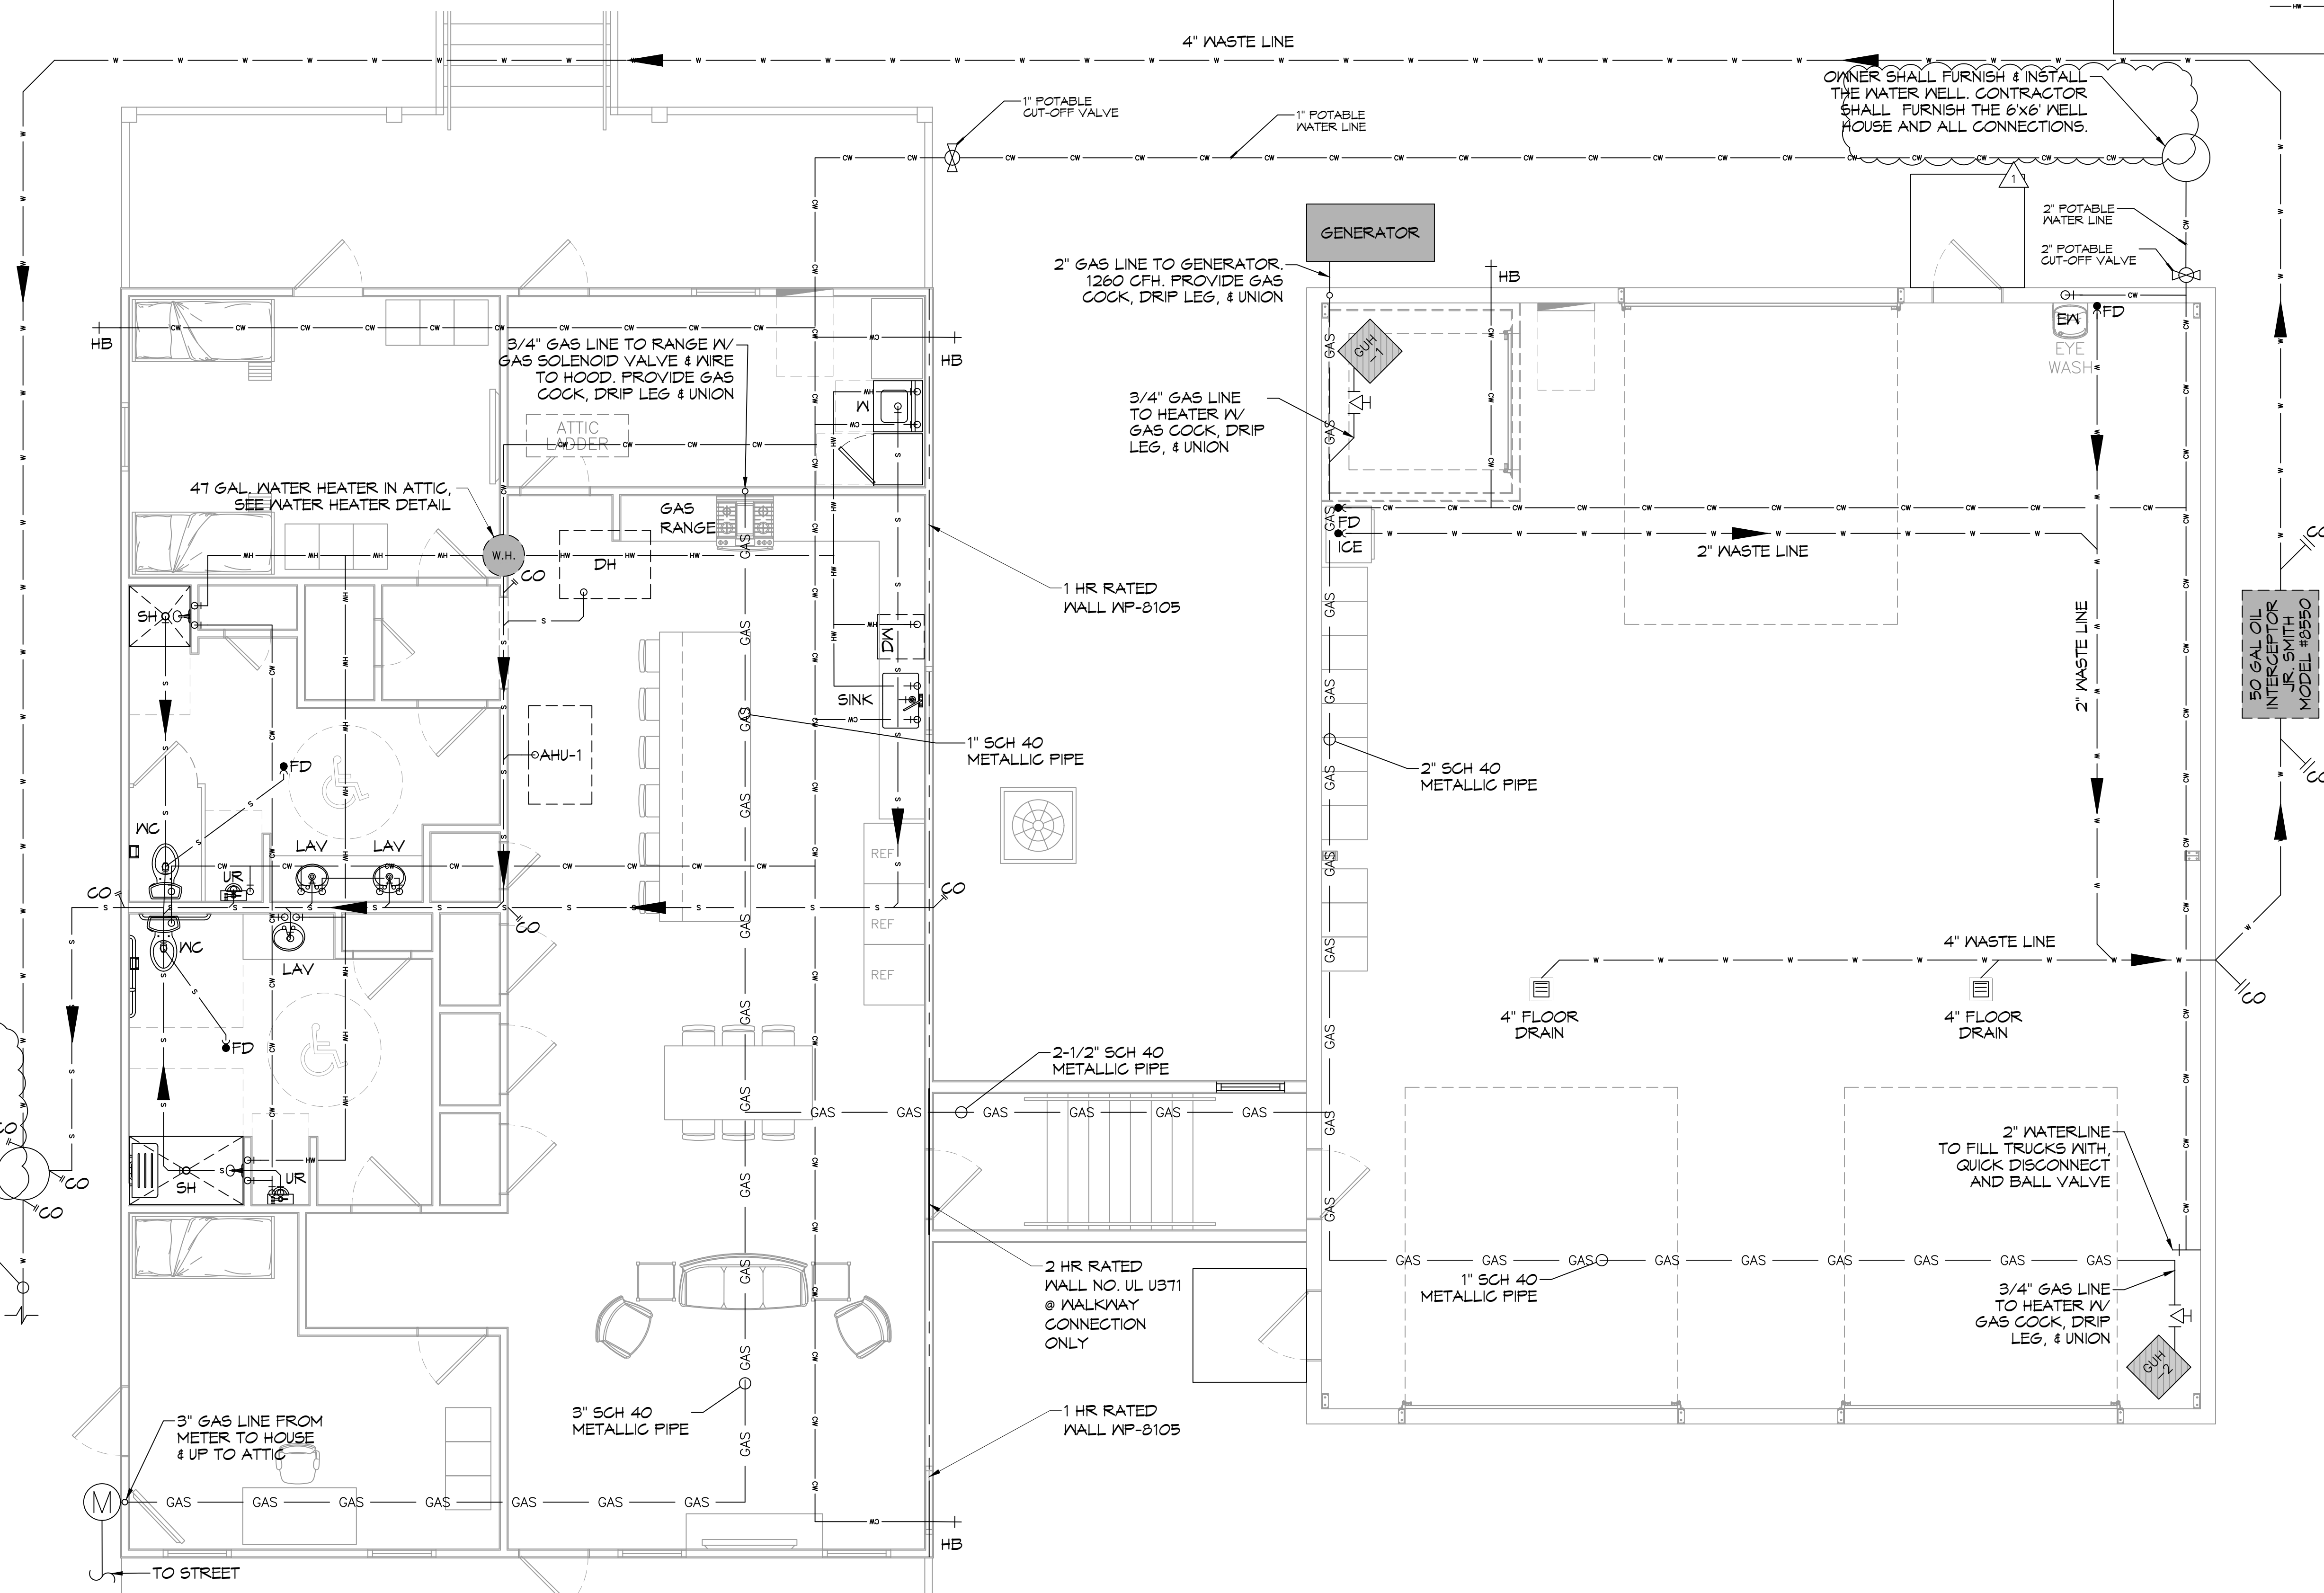

OWNER SHALL SUPPLY & INSTALL THE 600 GAL PER DAY CHLORINATED TREATMENT PLANT. CONTRACTOR SHALL MAKE ALL THE CONNECTIONS.

OWNER SHALL FURNISH & INSTALL THE WATER WELL. CONTRACTOR SHALL FURNISH THE 6'x6' WELL HOUSE AND ALL CONNECTIONS.

39 PLUMBING PLAN
 SCALE: 1/4" = 1'-0"