


BOAT STORAGE BLDG. 2442 FLOOR PLAN
SCALE: 1/8" = 1'-0"

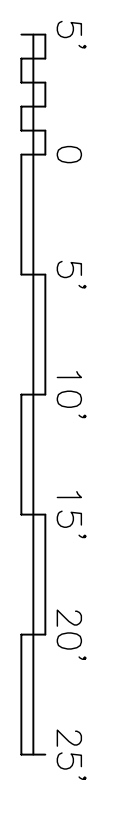

PLAN NORTH

- FIRE PROTECTION SYMBOLS**
- (WB) - FIRE EXTINGUISHER ON WALL BRACKET
 - (RC) - FIRE EXTINGUISHER IN RECESSED CABINET

<p>DEPARTMENT OF THE NAVY NAVAL FACILITIES ENGINEERING COMMAND SOUTHEAST NAVAL AIR STATION JACKSONVILLE JOHN C. STENNIS SPACE CENTER MISSISSIPPI SOF RIVERINE AND COMBATANT CRAFT OPERATIONS FACILITY - PRE-FINAL BOAT STORAGE BLDG. 2442 FLOOR PLAN</p>	<p>DESIGNER: R. WITSE ENGINEER: R. WITSE CHECKER: T. ARBIB SUPERVISOR: P. DAMMON</p>	<p>EMMETT B. DAMMON, JR. REGISTERED PROFESSIONAL ENGINEER NO. 9692 STATE OF MISSISSIPPI 1985 649-8312</p>	<p>DAMMON ENGINEERING, INC. 1000 W. WILSON BLVD. SUITE 200 DAMMON, LA 70508 (985) 649-8312</p>																						
<p>CODE ID NO. N4412 SIZE: 0 SCALE: AS SHOWN DRAWING NO. P-210 SHEET NO. 510247 CONSTR. CENTER NO. N62467-05-0-0096 NAVFAC DRAWING NO. 54 07 117</p>	<table border="1" style="width: 100%; border-collapse: collapse;"> <thead> <tr> <th style="width: 5%;">SYM</th> <th style="width: 75%;">DESCRIPTION</th> <th style="width: 10%;">DATE</th> <th style="width: 10%;">APPR</th> </tr> </thead> <tbody> <tr> <td> </td> <td> </td> <td> </td> <td> </td> </tr> <tr> <td> </td> <td> </td> <td> </td> <td> </td> </tr> <tr> <td> </td> <td> </td> <td> </td> <td> </td> </tr> <tr> <td> </td> <td> </td> <td> </td> <td> </td> </tr> </tbody> </table>					SYM	DESCRIPTION	DATE	APPR																
SYM	DESCRIPTION	DATE	APPR																						