

REVDATE:

A

B

C

D

1

2

3

4

5


1

2

3

4

5

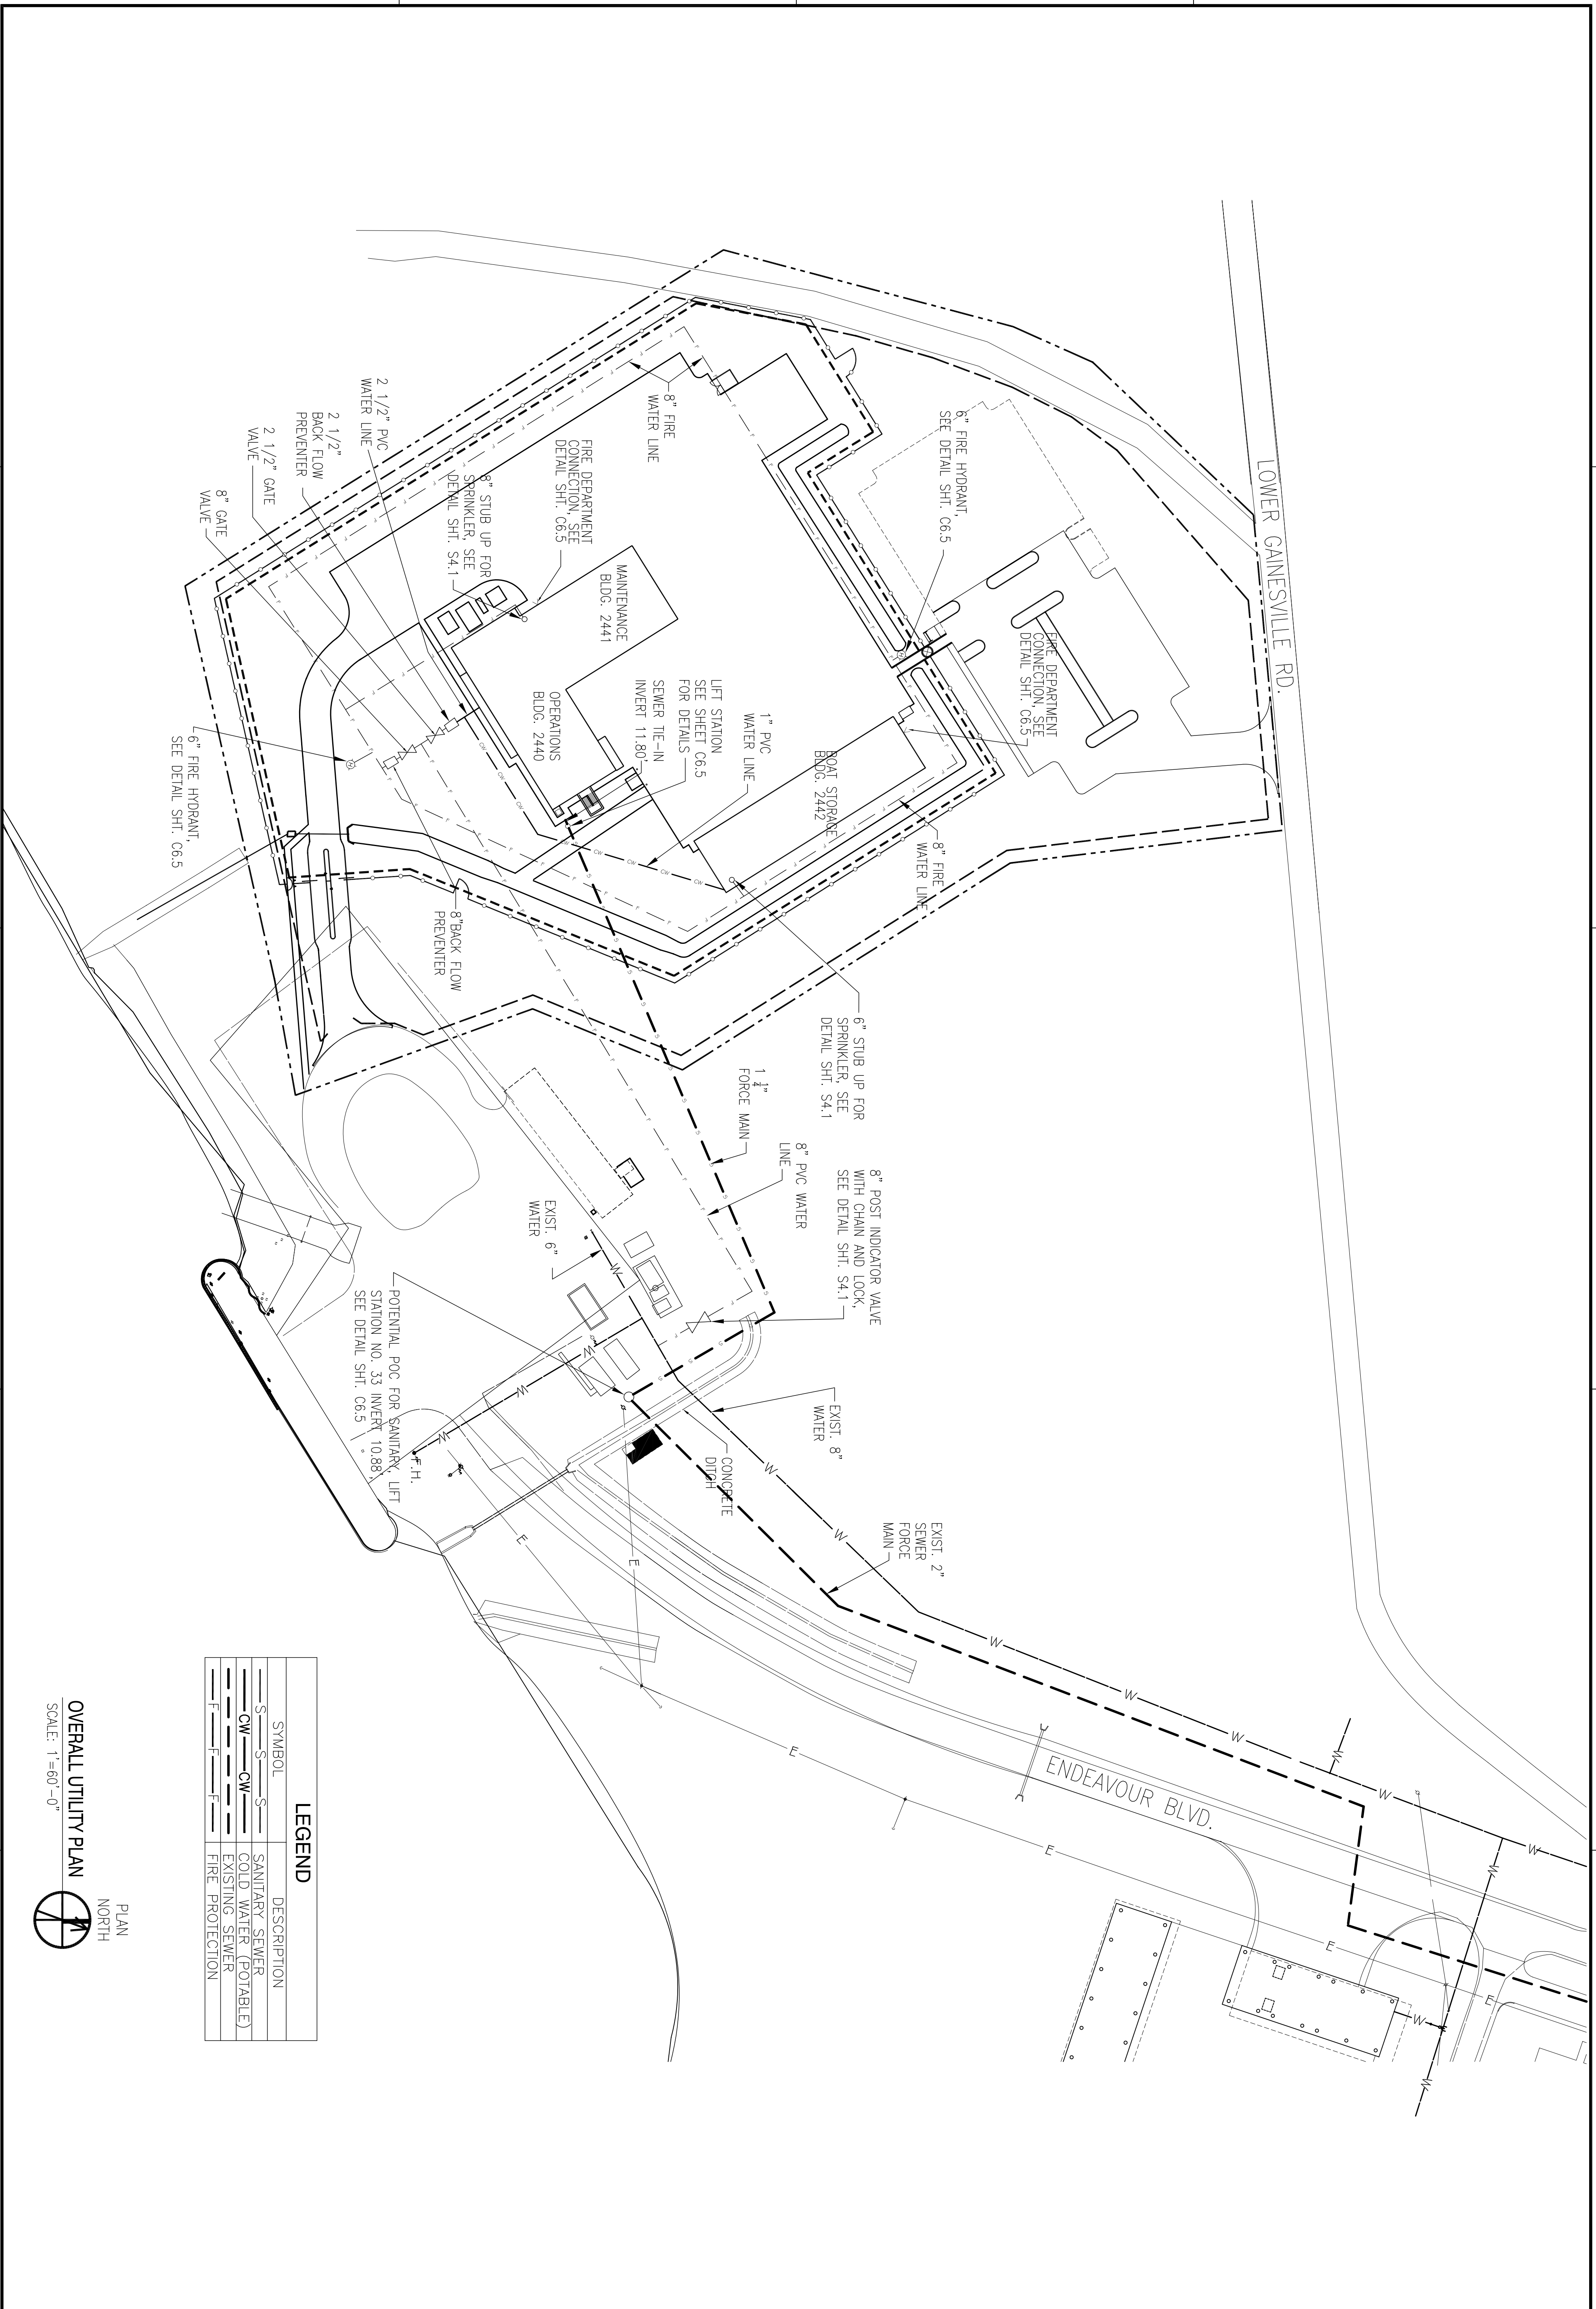


LEGEND	
SYMBOL	DESCRIPTION
—S—S—S—	SANITARY SEWER
—CW—CW—	COLD WATER (POTABLE)
—E—E—E—	EXISTING SEWER
—F—F—F—	FIRE PROTECTION

OVERALL UTILITY PLAN  
SCALE: 1"=60'-0"




DEPARTMENT OF THE NAVY  
NAVAL FACILITIES ENGINEERING COMMAND SOUTHEAST  
NAVAL AIR STATION JACKSONVILLE  
IPT SOUTH ATLANTIC  
MISSISSIPPI  
JOHN C. STENNIS SPACE CENTER  
SOF RIVERINE AND COMBATANT CRAFT OPERATIONS FACILITY - PRE-FINAL  
OVERALL UTILITY PLAN

DESIGNER: C. DAMMON, J. DEWE, C. DAMMON  
CHECKED BY: S. WILSON  
DRAWN BY: T. ARBIB  
DATE: 05/11/2009

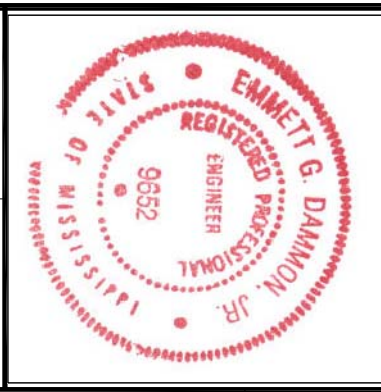

**DAMMON ENGINEERING, INC.**  
1000 W. GULF BLVD., SUITE 200  
DAMMON, LA 70802  
(985) 649-5832  
www.de.com

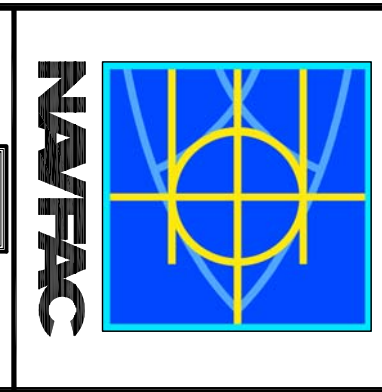

SYM	DESCRIPTION	DATE	APPR