

A

B

C

D

1

2

3

4

5


1

2

3

4

5

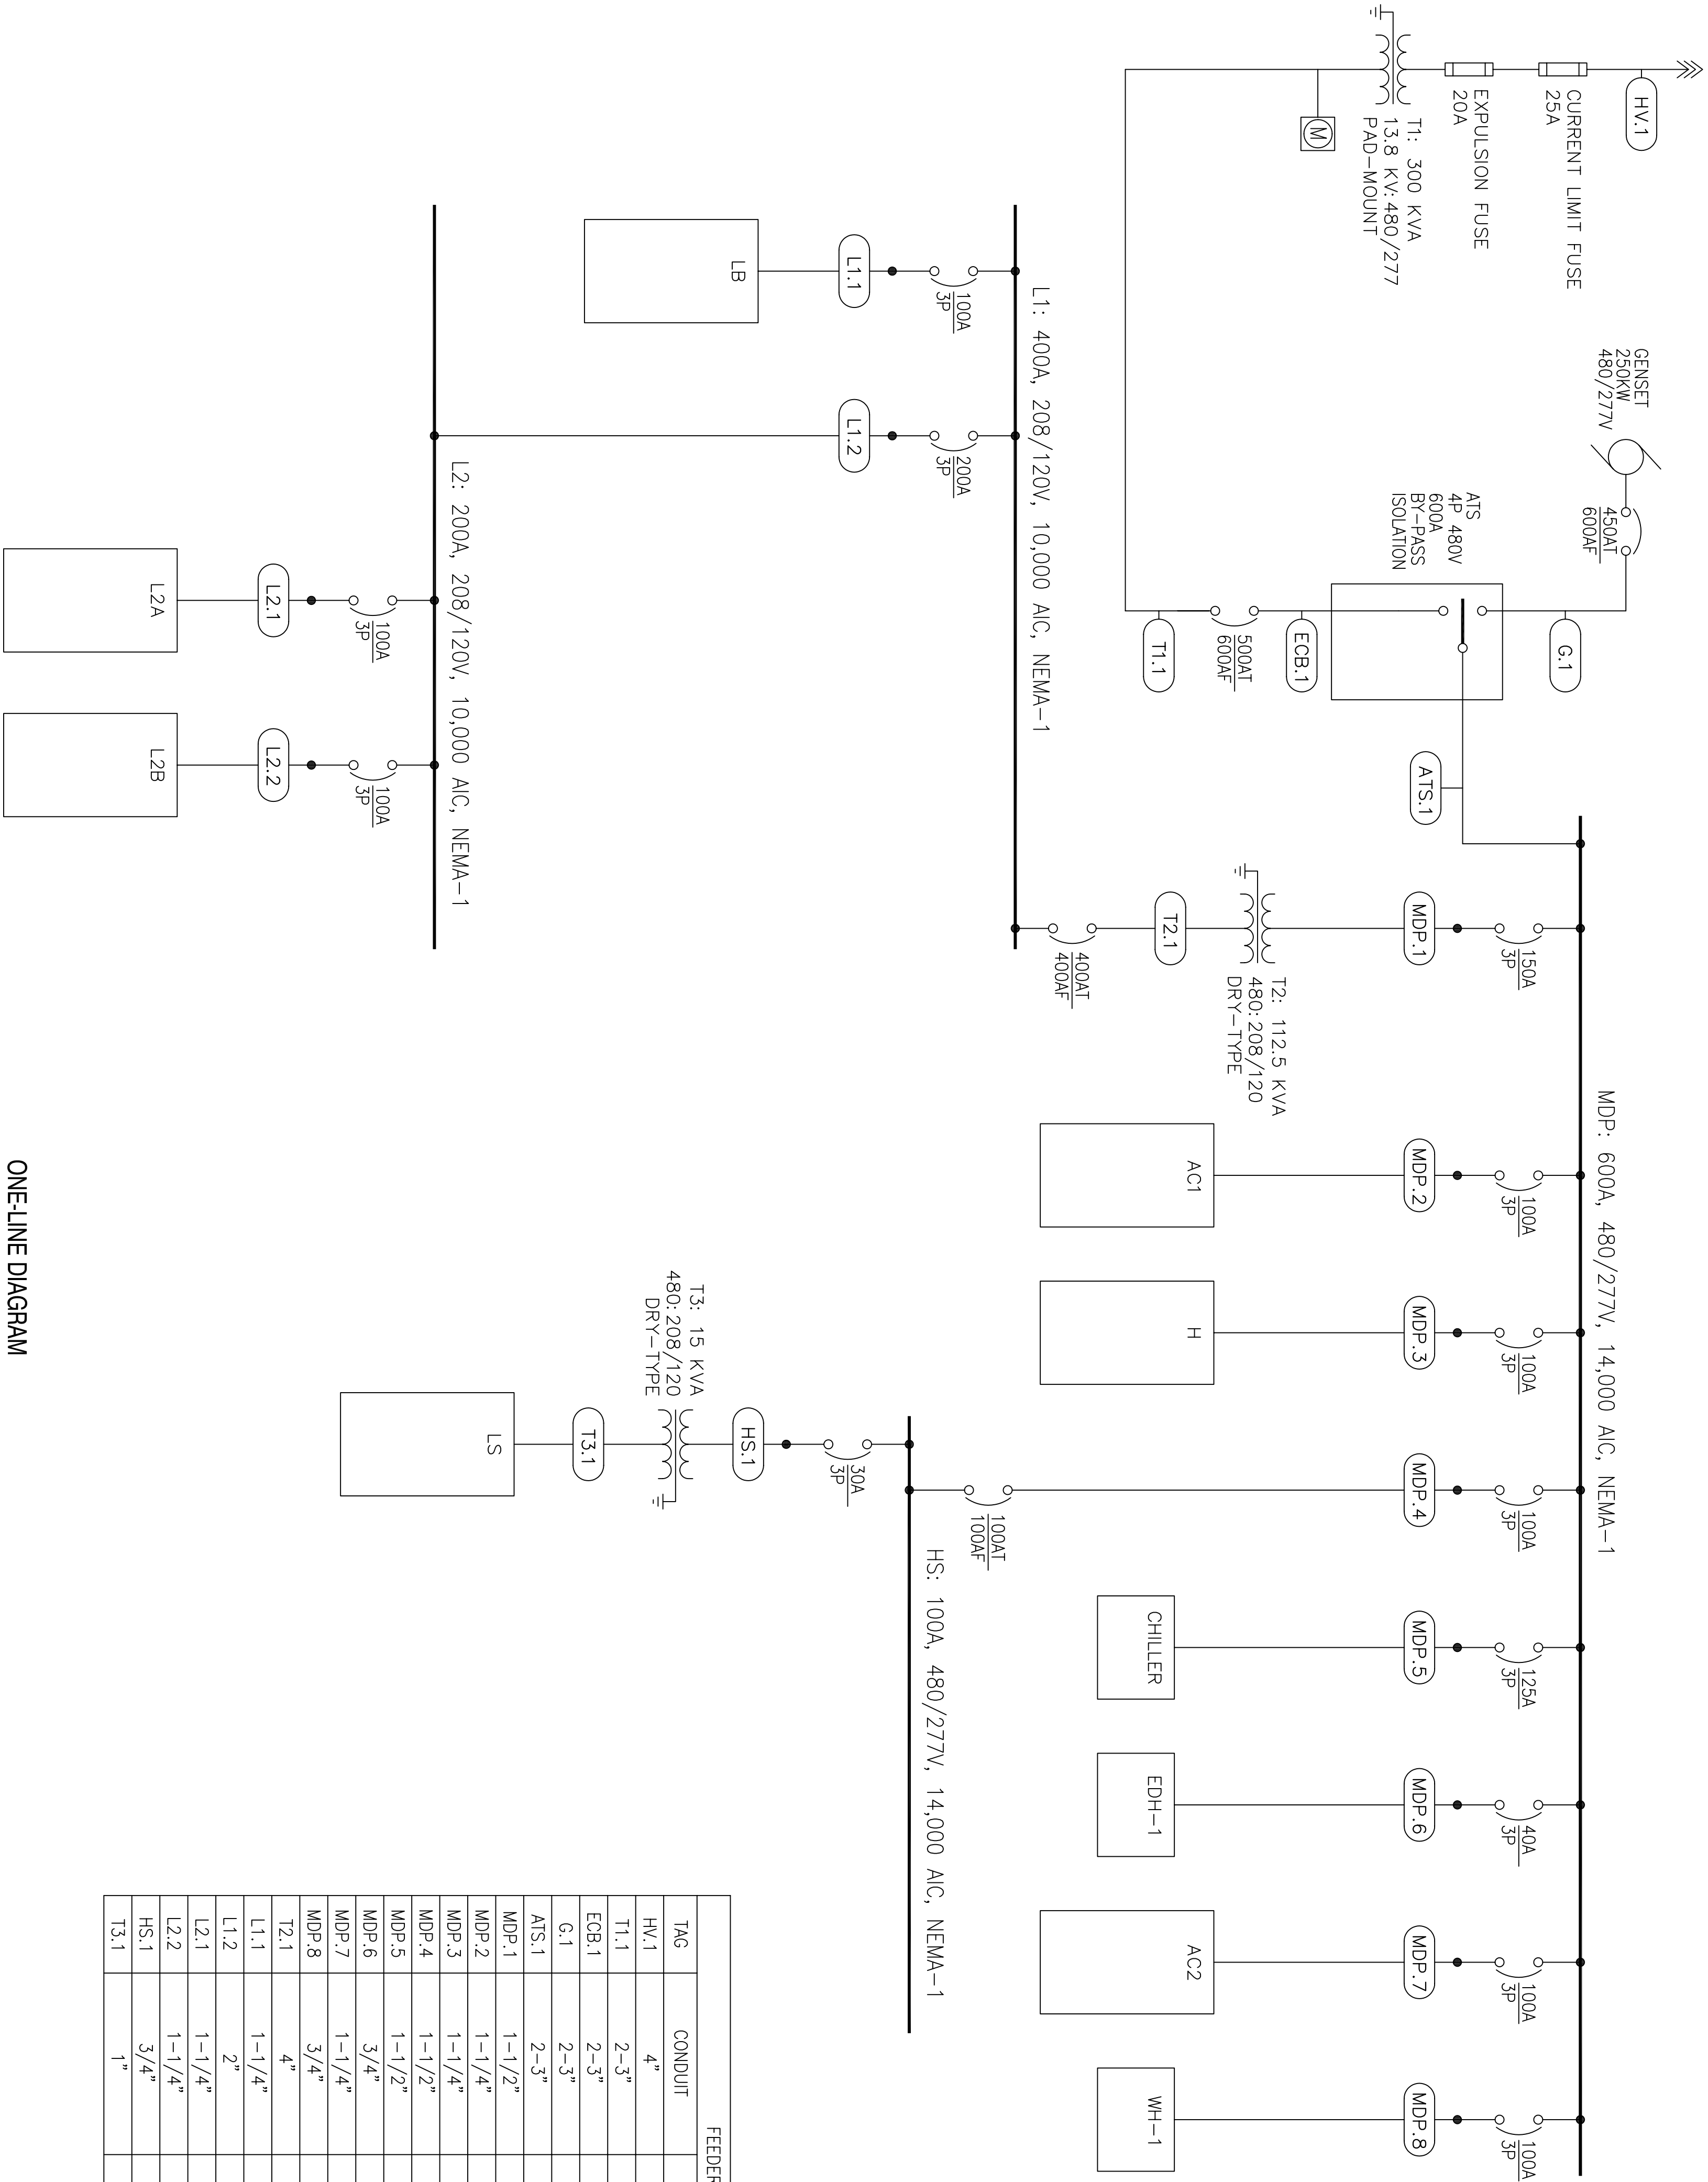

ONE-LINE DIAGRAM
NO SCALE

TAG	CONDUIT	WIRE
HV.1	4"	3-#1/0 AWG, TYPE MW-10S
T1.1	2-3"	4-250 KCMLL EACH
ECB.1	2-3"	4-250 KCMLL, #2 GRD EACH
G.1	2-3"	4-250 KCMLL, #2 GRD EACH
ATS.1	2-3"	4-250 KCMLL, #2 GRD EACH
MDP.1	1-1/2"	3-#1/0 AWG, 1-#6 GRD
MDP.2	1-1/4"	4-#2 AWG, 1-#8 GRD
MDP.3	1-1/4"	4-#2 AWG, 1-#8 GRD
MDP.4	1-1/2"	4-#2 AWG, 1-#8 GRD
MDP.5	1-1/2"	3-#1 AWG, 1-#6 GRD
MDP.6	3/4"	3-#8 AWG, 1-#10 GRD
MDP.7	1-1/4"	4-#2 AWG, 1-#8 GRD
MDP.8	3/4"	3-#8 AWG, 1-#10 GRD
T2.1	4"	4-500 KCMLL, 1-#1/0 GRD
L1.1	1-1/4"	4-#2 AWG, 1-#8 GRD
L1.2	2"	4-#3/0 AWG, 1-#6 GRD
L2.1	1-1/4"	4-#2 AWG, 1-#8 GRD
L2.2	1-1/4"	4-#2 AWG, 1-#8 GRD
HS.1	3/4"	3-#10 AWG, 1-#10 GRD
T3.1	1"	4-#6 AWG, 1-#8 GRD

FEEDER SCHEDULE

A

B

C

D

DEPARTMENT OF THE NAVY NAVAL FACILITIES ENGINEERING COMMAND SOUTHEAST IPT SOUTH ATLANTIC JOHN C. STENNIS SPACE CENTER MISSISSIPPI		NAVAL FACILITIES ENGINEERING COMMAND NAVAL AIR STATION JACKSONVILLE MISSISSIPPI	
SOF RIVERINE AND COMBATANT CRAFT OPERATIONS FACILITY			
ONE-LINE DIAGRAM			
SCALE: NONE DRAWING NO.: N62467-05-D-0096 CONSTR. CONTR. NO.: N62467-05-D-0096 NAFAC DRAWING NO.: N62467-05-D-0096 SHEET: XXX OF XXX	DES. K. SCHLAFLY (DRW. K. SCHLAFLY) REG. NO. 27699 PROFESSIONAL ENGINEER ELECTRICAL ENGINEERING IN THE STATE OF LOUISIANA M. KIMBALL SCHLAFLY REG. NO. 27699 PROFESSIONAL ENGINEER ELECTRICAL ENGINEERING IN THE STATE OF LOUISIANA P.M./O.M. T. ARMBR. CHIEF ENGR/ARCH. P. DAMON	SCHLAFLY ENGINEERING, LLC 121 SOUTH GENOIS STREET NEW ORLEANS, LA 70119 PHONE: 504-482-1347 FAX: 504-482-1980 M. KIMBALL SCHLAFLY, P.E. LA REG 27699	APPR: _____ DATE: _____ SYM: _____

PRE-FINAL SUBMISSION
MAY 15, 2009
NOT FOR CONSTRUCTION