
 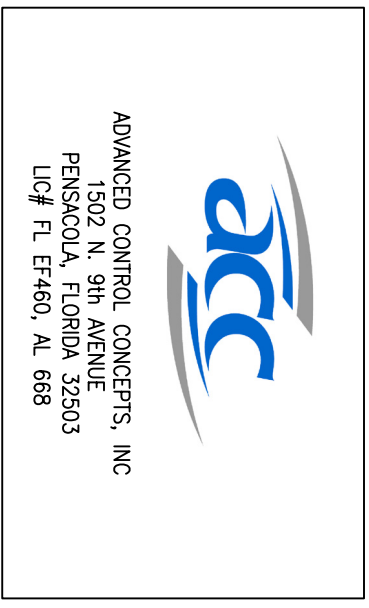


BOAT STORAGE BLDG. 2442  
 FLOOR PLAN - INTEGRATED SECURITY  
 SCALE: 1/8"=1'-0"  
 PLAN NORTH



**PRE-FINAL SUBMISSION**  
 MAY 15, 2009  
**NOT FOR CONSTRUCTION**

<p><b>SCHLAFLY ENGINEERING LLC</b>          121 SOUTH GENOIS STREET          NEW ORLEANS, LA 70119          PH: 504-482-1947          FX: 504-482-1983  <b>M. KIMBALL SCHLAFLY, P.E.</b>          LA REG 27699</p>	SYMBOL	DESCRIPTION	DATE	APPROVED
<p>RES: M. KIMBALL SCHLAFLY          REG. NO. 27699          PROFESSIONAL ENGINEER          ELECTRICAL ENGINEERING          IN THE STATE OF LOUISIANA</p>	DEPARTMENT OF THE NAVY NAVAL FACILITIES ENGINEERING COMMAND NAVAL FACILITIES ENGINEERING COMMAND SOUTHEAST NAVAL AIR STATION JACKSONVILLE MISSISSIPPI JOHN C. STENNIS SPACE CENTER <b>SOF RIVERINE AND COMBATANT CRAFT OPERATIONS FACILITY</b> BLDG. 2442 FLOOR PLAN - SECURITY			
DESIGNED BY: R. WILTS CHECKED BY: T. ARBER CHIEF ENGINEER: P. DAMON	DEPARTMENT OF THE NAVY NAVAL FACILITIES ENGINEERING COMMAND NAVAL FACILITIES ENGINEERING COMMAND SOUTHEAST NAVAL AIR STATION JACKSONVILLE MISSISSIPPI JOHN C. STENNIS SPACE CENTER <b>SOF RIVERINE AND COMBATANT CRAFT OPERATIONS FACILITY</b> BLDG. 2442 FLOOR PLAN - SECURITY			
SCALE: 1/8"=1'-0" CODE ID: NO. N4412 SIZE: D DRAWING NO. ##### STA. PROJ. NO. ##### WORK ORDER NO. ##### CONSTR. CONTR. NO. N62467-05-D-0096 NAVFAC DRAWING NO. ##### SHEET NO. E6.3 OF XXX	DEPARTMENT OF THE NAVY NAVAL FACILITIES ENGINEERING COMMAND NAVAL FACILITIES ENGINEERING COMMAND SOUTHEAST NAVAL AIR STATION JACKSONVILLE MISSISSIPPI JOHN C. STENNIS SPACE CENTER <b>SOF RIVERINE AND COMBATANT CRAFT OPERATIONS FACILITY</b> BLDG. 2442 FLOOR PLAN - SECURITY			

1 2 3 4 5

A B C D