


OPERATIONS BUILDING FIRST FLOOR PLUMBING PLAN
SCALE: 3/32" = 1'-0"
PLAN NORTH

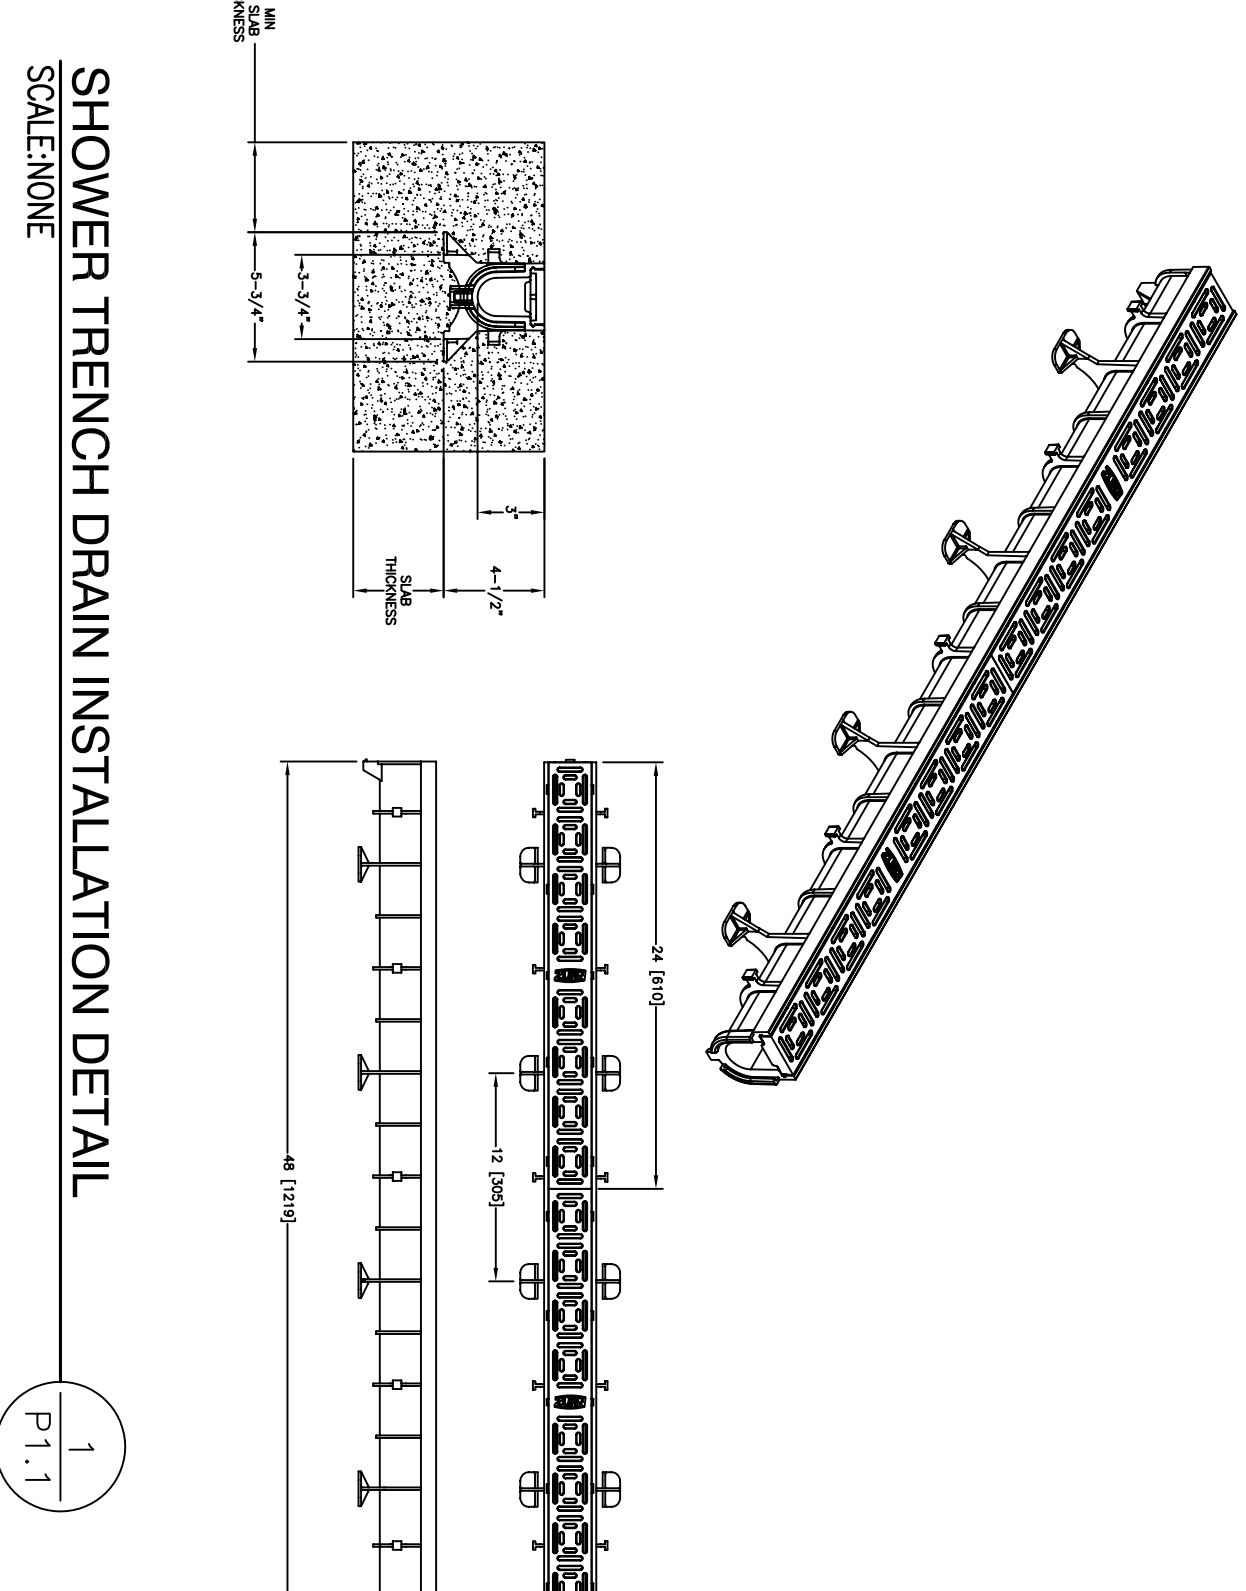

SHOWER TRENCH DRAIN INSTALLATION DETAIL
SCALE: NONE
1
P1.1

DAMIEN W. SERAUSKAS, P.E.
PROFESSIONAL ENGINEERING SERVICES
15 CYPRESS POINT LANE NEW ORLEANS, LA 70131
VOICE: (504) 966-2600 FAX: (504) 218-9480

	<p>DAMIEN W. SERAUSKAS, P.E. ENGINEER, INC. CHIEF ARCHITECT DAMIEN W. SERAUSKAS 15 CYPRESS POINT LANE NEW ORLEANS, LA 70131 (504) 966-2600</p>		<p>ENGINEER BY: D. SERAUSKAS DATE: 5/14/09</p>	<p>CHIEF ENGINEER: D. SERAUSKAS</p>
			<p>DEPARTMENT OF THE NAVY NAVAL FACILITIES ENGINEERING COMMAND NAVAL FACILITIES ENGINEERING COMMAND SOUTHEAST 1ST SOUTH ATLANTIC NAVAL AIR STATION JACKSONVILLE</p>	<p>JOHN C. STENNIS SPACE CENTER MISSISSIPPI SOF RIVERINE AND COMBATANT CRAFT OPERATIONS FACILITY</p>
<p>PROJECT NO. 14442 SIZE: D SCALE: AS NOTED</p>			<p>DATE: 05/14/09</p>	
<p>WORK ORDER NO. 0000000000</p>			<p>CONTRACT NO. N62447-05-D-0096</p>	
<p>DATE: 05/14/09</p>			<p>PROJECT: 14442</p>	
<p>SHEET: 11 OF 11</p>			<p>P1.1</p>	