



REVDATE: FILE NAME: C:\Schlafly\ENGR 08010 SOF Riverine Drawings Elec-5-Ag--buils-E6.1.dwg LAYOUT NAME: E6.1 PLOTTED: Friday, May 28, 2010 - 3:31pm

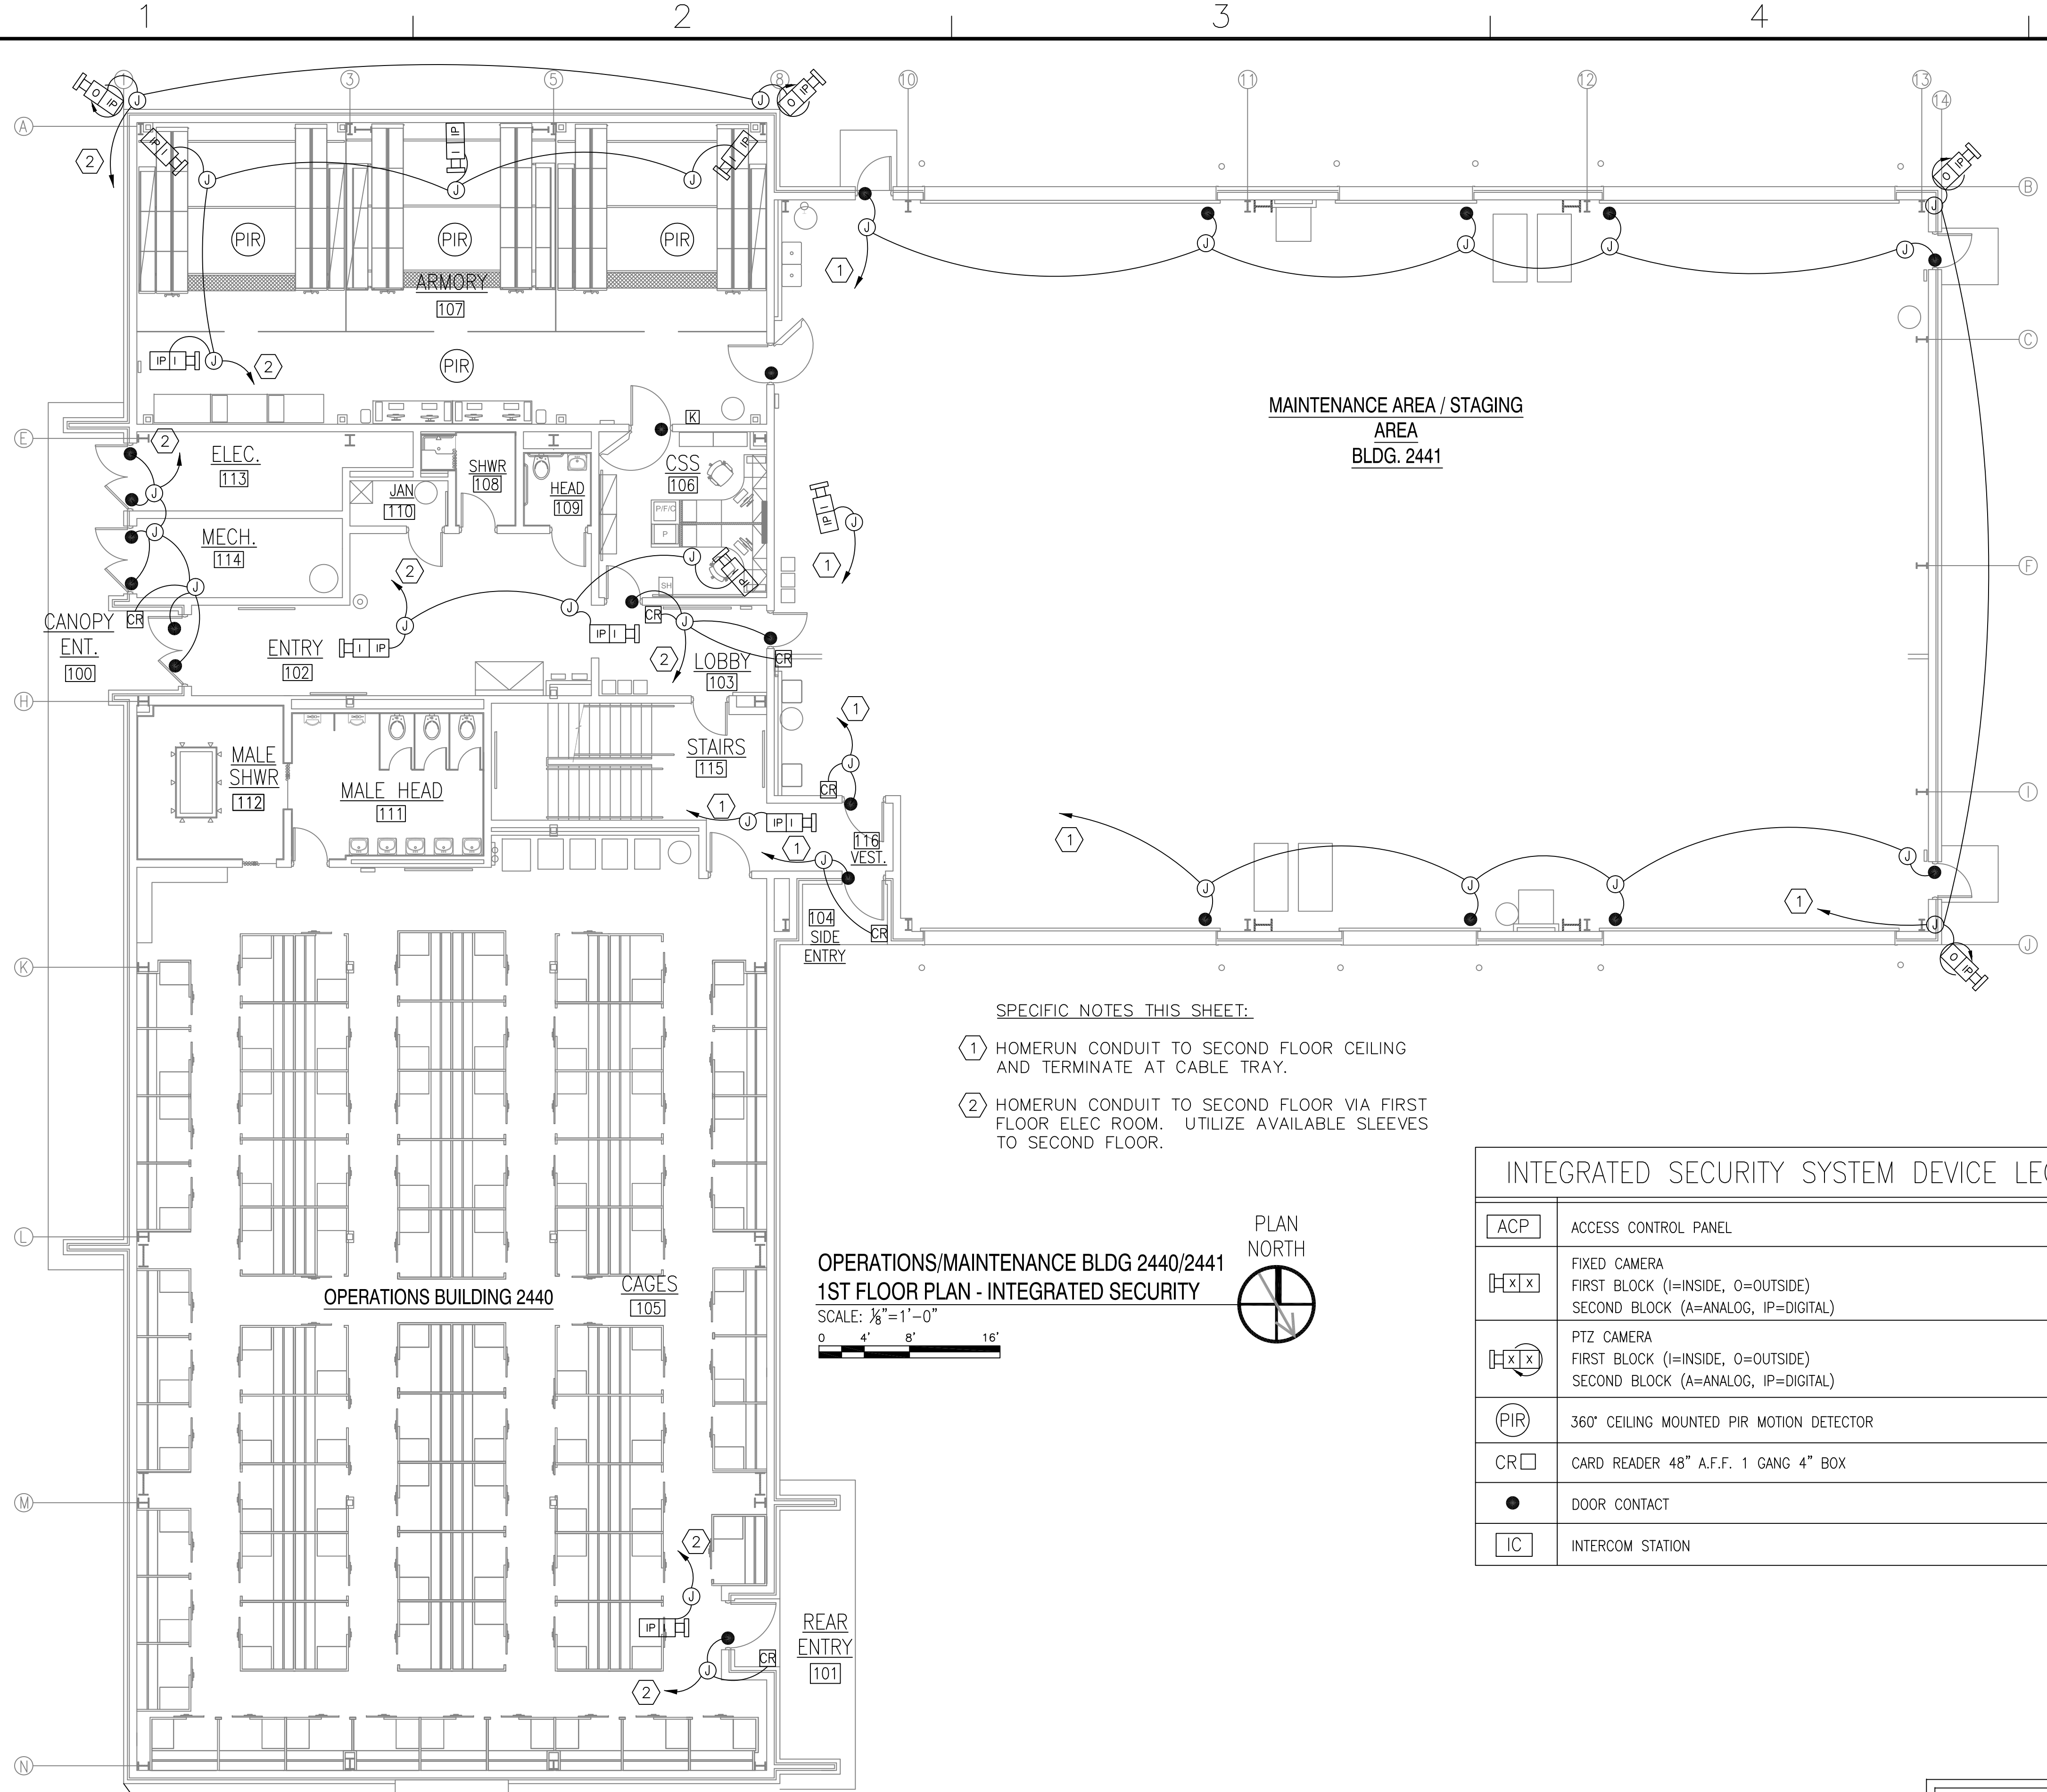


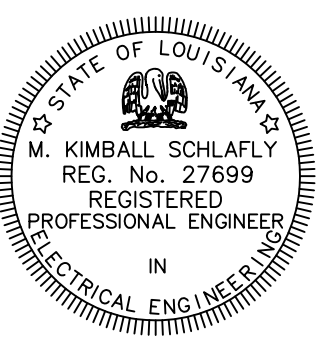
- SPECIFIC NOTES THIS SHEET:**
- ① HOMERUN CONDUIT TO SECOND FLOOR CEILING AND TERMINATE AT CABLE TRAY.
  - ② HOMERUN CONDUIT TO SECOND FLOOR VIA FIRST FLOOR ELEC ROOM. UTILIZE AVAILABLE SLEEVES TO SECOND FLOOR.

**OPERATIONS/MAINTENANCE BLDG 2440/2441**  
**1ST FLOOR PLAN - INTEGRATED SECURITY**  
 SCALE: 1/8" = 1'-0"  
 0 4' 8' 16'

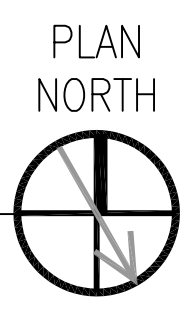

INTEGRATED SECURITY SYSTEM DEVICE LEGEND	
ACP	ACCESS CONTROL PANEL
[H x]	FIXED CAMERA FIRST BLOCK (I=INSIDE, O=OUTSIDE) SECOND BLOCK (A=ANALOG, IP=DIGITAL)
[H x]	PTZ CAMERA FIRST BLOCK (I=INSIDE, O=OUTSIDE) SECOND BLOCK (A=ANALOG, IP=DIGITAL)
PIR	360° CEILING MOUNTED PIR MOTION DETECTOR
CR	CARD READER 48" A.F.F. 1 GANG 4" BOX
●	DOOR CONTACT
IC	INTERCOM STATION

**RECORD DRAWING**  
**LETTER DATED**  
**5-27-10**

AS-BUILT REVISIONS	5-27-10	DATE	APPR
DESCRIPTION			
 <b>NAVFAC</b> SCHLAFLY ENGINEERING LLC 121 SOUTH GENOIS STREET NEW ORLEANS LA 70119 PHONE 504-415-3347 FAX 504-482-7943 M. KIMBALL SCHLAFLY, P.E. LA REG 27699 SEPTEMBER 4, 2009			
 M. KIMBALL SCHLAFLY REG. No. 27699 REGISTERED PROFESSIONAL ENGINEER IN ELECTRICAL ENGINEERING			
DES: K. SCHLAFLY   DRW: K. SCHLAFLY REVIEWED BY: R. WILTSE PM/DM: T. ARTRIP CHIEF ENG/ARCH: P. DAMMON			
DEPARTMENT OF THE NAVY NAVAL FACILITIES ENGINEERING COMMAND SOUTHEAST NAVAL AIR STATION JACKSONVILLE MISSISSIPPI JOHN C. STENNIS SPACE CENTER SOF RIVERINE AND COMBATANT CRAFT OPERATIONS FACILITY BLDG 2440/2441 1ST FLOOR - SECURITY			
CODE ID. NO. N4412		SIZE D	
SCALE: 1/8" = 1'-0"			
MAXIMO NO. #####			
STA. PROJ. NO. P-210			
WORK ORDER NO. 510247			
CONSTR. CONTR. NO. N62467-05-D-0096			
NAVFAC DRAWING NO. 15026767			
SHEET 120 OF 132			
<b>E6.1</b>			
DRAWING REVISION: 01 JAN 2009			