



OPERATIONS BUILDING SECOND FLOOR PLUMBING PLAN
SCALE: 3/32"=1'-0"

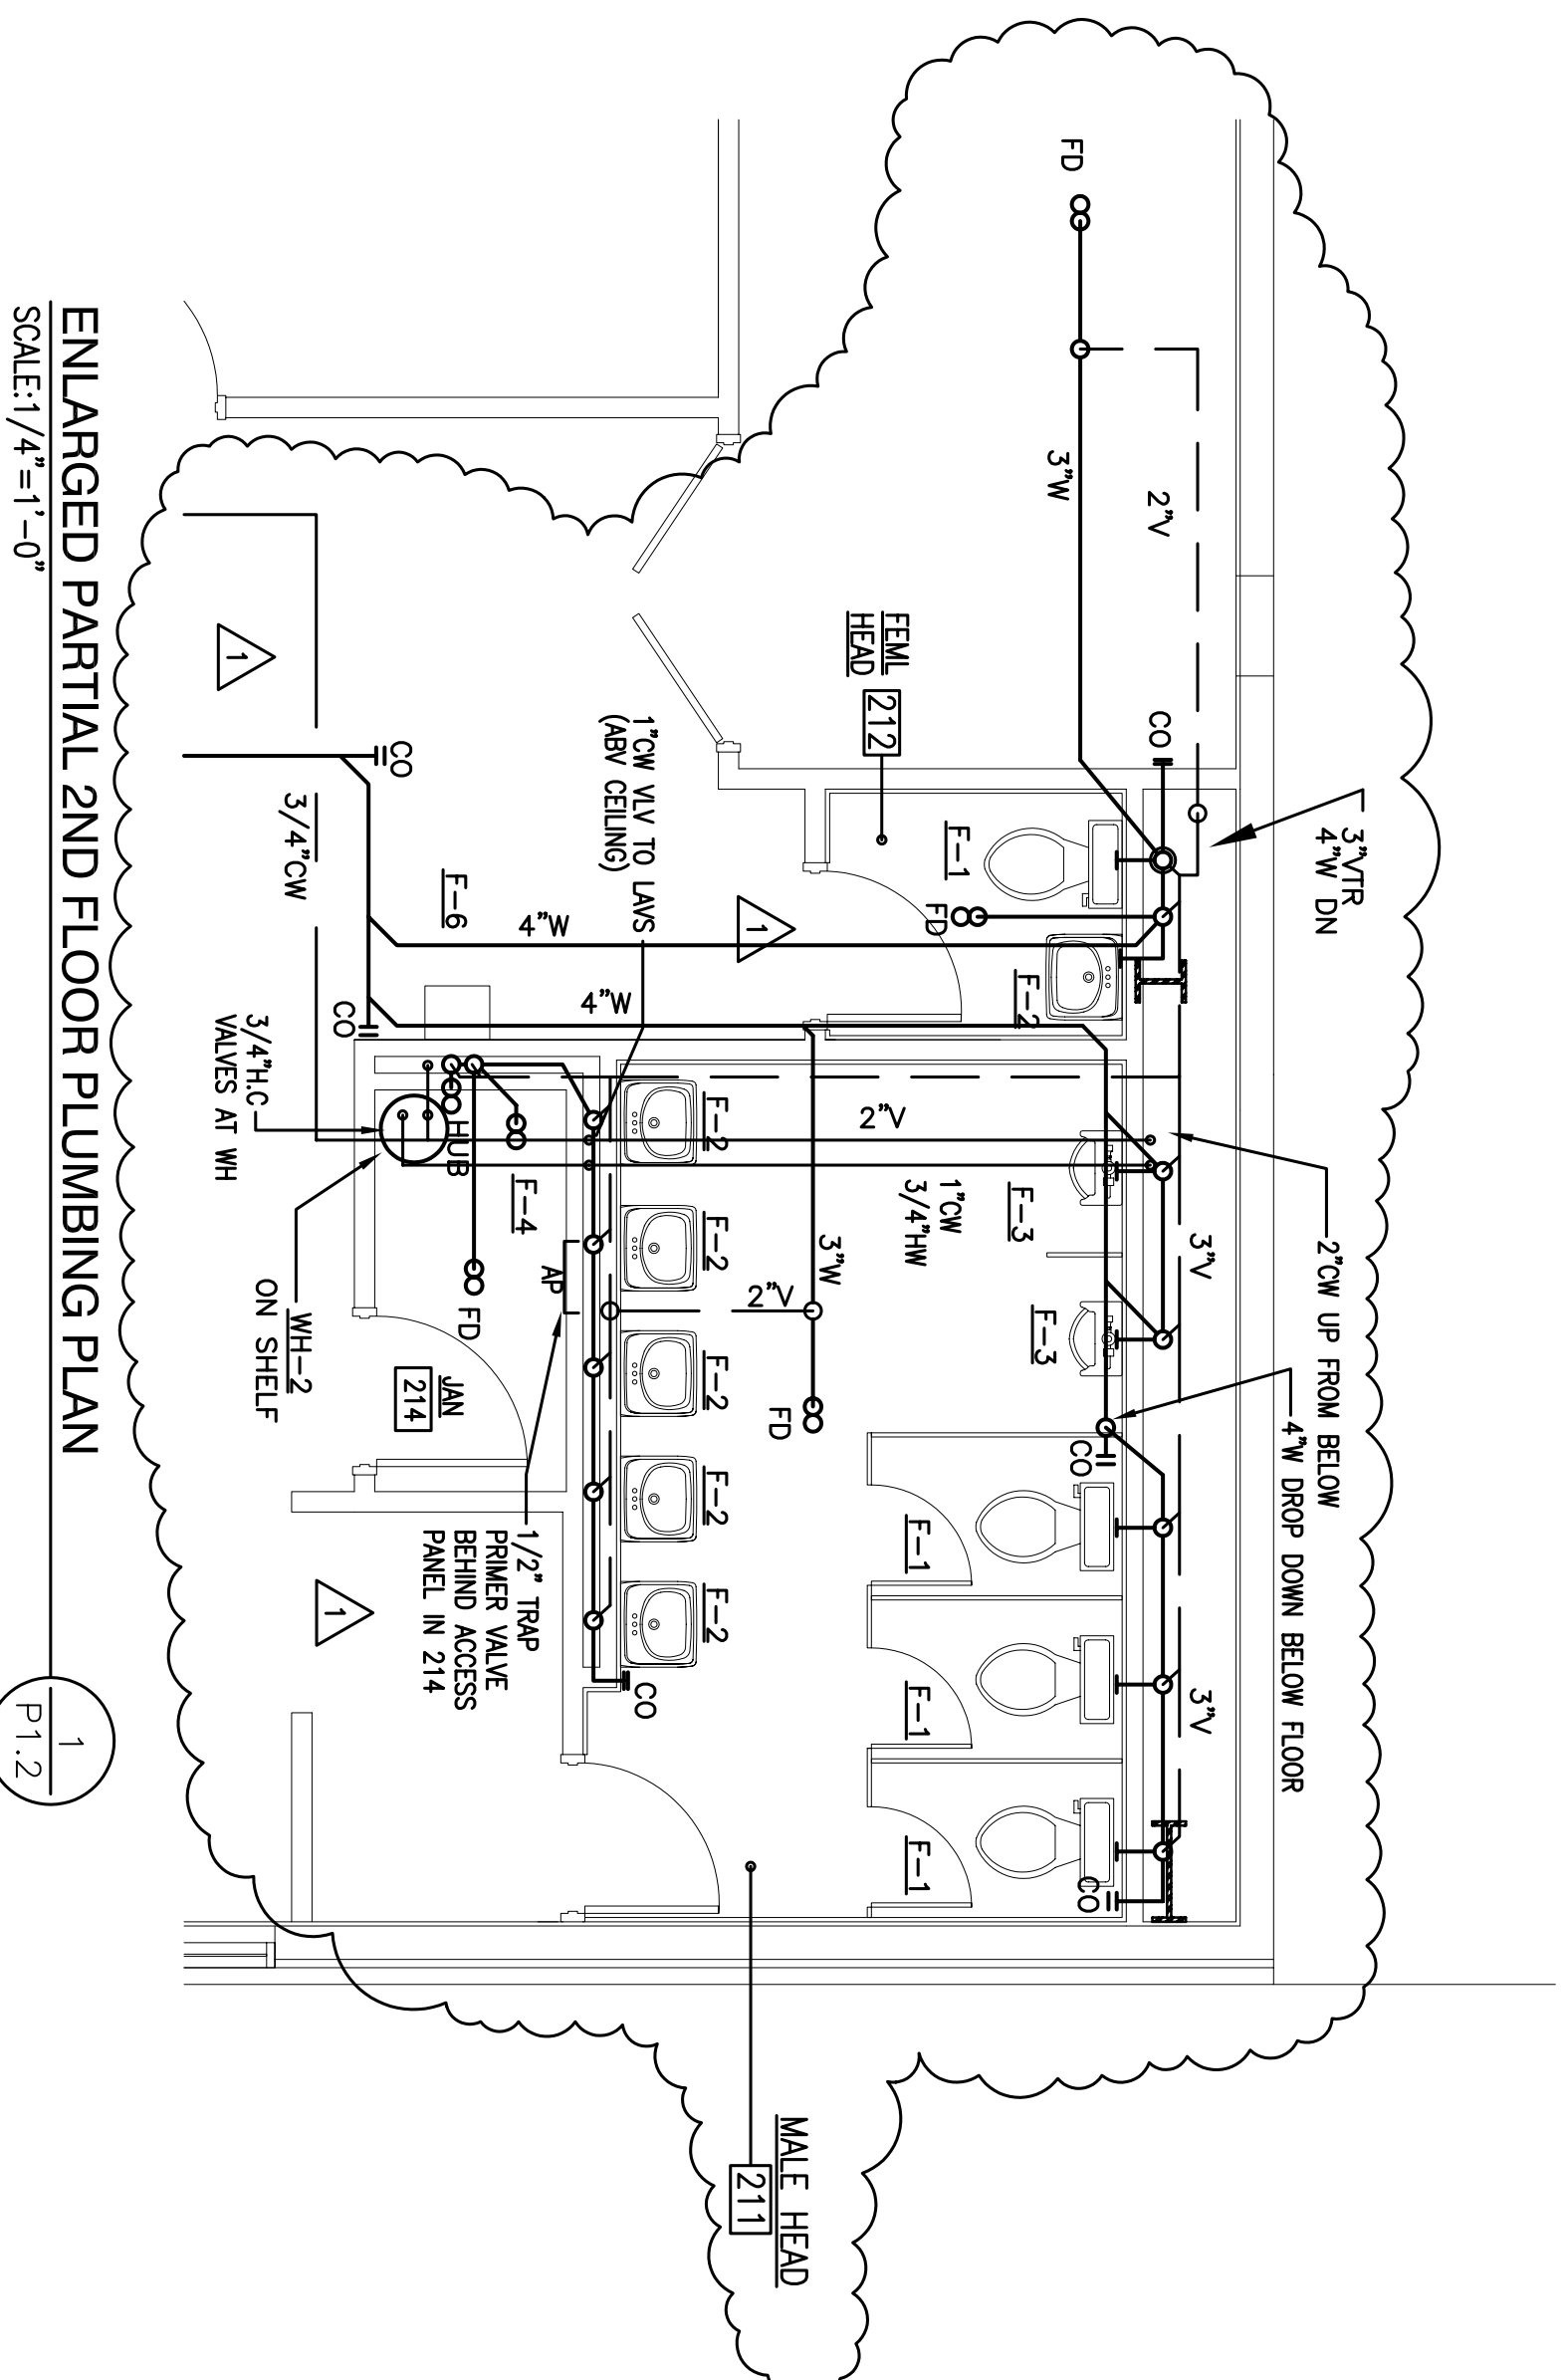

ENLARGED PARTIAL 2ND FLOOR PLUMBING PLAN
SCALE: 1/4"=1'-0"

DAMIEN W. SERAUSKAS, P.E.
PROFESSIONAL ENGINEERING SERVICES
15 CYPRESS POINT LANE NEW ORLEANS, LA 70131
VOICE: (504)866-2600 FAX: (504)2188480

SYMBOL	DESCRIPTION	DATE	APPROVED
1	RECORD DRAWING	06/10/2010	DWS
	AS-BUILT CONDITIONS SHOWN	06/10/2010	DWS

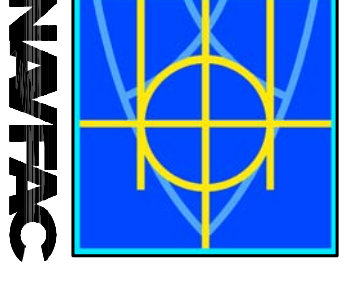

DAMMON
ENGINEERING, INC.
CHIEF ENGINEER, CHIEF ARCHITECT
DAMIEN W. SERAUSKAS, P.E.
1095 FLORIDA AVENUE
SUITE 111, LA 70008
(850) 649-3832

REVIEWED BY: R. WILFSE
IN/CHIEF: T. ARTHUR
CHIEF ENGINEER/ARCHITECT: DAMMON

DEPARTMENT OF THE NAVY
NAVAL FACILITIES ENGINEERING COMMAND
NAVAL FACILITIES ENGINEERING COMMAND SOUTHEAST
IPT GULF COAST
JOHN C. STENNIS SPACE CENTER
MISSISSIPPI
SOF RIVERINE AND COMBATANT
CRAFT OPERATIONS FACILITY - PRE-FINAL
OPS BLDG SECOND FLOOR PLUMBING PLAN

CODE ID NO. N4412 SIZE: D
SCALE: AS SHOWN
DRAWING NO. #####
SHEET NO. P-210
WORK ORDER NO. 510247
CONTRACT NO. N62467-05-D-0096
NAVFAC DRAWING NO. 15026743
SHEET 96 OF 132
P1.2