

PLUMBING FIXTURE SCHEDULE


TAG	DESCRIPTION	RANGE-IN			MODEL
		WASTE	CM	HM	
F-1	WATER CLOSET, WHITE VIT CHINA, FLUSH VALVE, WALLHNG, SIPHON JET	3"	1"	--	KOHLER K-4330-O KINGSTON TOP SPRD W/ OPEN-FRT SEAT LESS CVR 1/6 GPF SENSOR FLUSH VLV
F-1A	WATER CLOSET, WHITE VIT CHINA, FLUSH VALVE, WALLHNG, SIPHON JET ADA/AFAS HEIGHT	3"	1"	--	KOHLER K-4330-O KINGSTON TOP SPRD W/ OPEN-FRT SEAT LESS CVR 1/6 GPF SENSOR FLUSH VLV (MOUNTED AT ADA-HEIGHT)
F-2	WALL HNG LAV, WHITE VIT CHINA 18x17 RECT, 4" CENTERS, OPEN GRID STRAINER	1 1/2"	1/2"	1/2"	KOHLER CHESAPEAKE K-1128 WITH SLOAN OPTIMA SENSOR-OP FAUCET W/ AERATOR
F-2A	WALL HNG LAV, WHITE VIT CHINA 18x17 RECT, 4" CENTERS, OPEN GRID STRAINER, OFFSET TAILFIDE, ADA/AFAS HEIGHT	1 1/2"	1/2"	1/2"	KOHLER CHESAPEAKE K-1128 WITH SLOAN OPTIMA SENSOR-OP FAUCET W/ AERATOR
F-3	FLUSH-VALVE URINAL	2"	3/4"	--	KOHLER DEXTER K-5016-ET ELONGATED URINAL, TOP SPRD, WITH STRAINER AND SLOAN 1/2 GPF SENSOR-OP FLUSH VALVE
F-3A	ADA/AFAS FLUSH-VALVE URINAL	2"	3/4"	--	KOHLER DEXTER K-5016-ET ELONGATED URINAL, TOP SPRD, WITH STRAINER AND SLOAN 1/2 GPF SENSOR-OP FLUSH VALVE, ADA HEIGHT
F-4	CAST TERRAZZO HOP SINK 24x24x12 WITH 6" DROP FRONT, HOP HANGER, SVC FAUCET, HOSE, & HOOK	1 1/2"	1/2"	1/2"	FLAT TERRAZZO WITH STAINLESS BAMPER GAURD, HANGER, SERVICE FAUCET
F-5	ALL-PURPOSE SERVICE SINK WITH PTRAP STAND AND WALL HANGER	3"	3/4"	3/4"	AN STD 4061193 WITH 24S192 FAUCET, 376030 GRID DRAIN, P-TRAP STAND, TRIM
F-6	SINGLE STATION WALL MOUNTED WATER COOLER	1 1/2"	1/2"	--	ELKAY EFF210C WALL MNTD SINGLE WATER BEATTIN WITH FRONT DISTRIBUTION
F-6A	BARRIER-FREE DIAL STATION WATER COOLER	1 1/2"	1/2"	--	ELKAY EFF210C WALL MNTD SINGLE WATER BEATTIN WITH FRONT DISTRIBUTION, ADA HEIGHT

INSULATE ALL WASTE AND SUPPLY PIPING FOR ADA-COMPLIANT FIXTURES, OR PROVIDE TRIE-BRO LAV-GUARD(TM) SYSTEM.

AIR COMPRESSOR SCHEDULE


TAG	CAP (CFM)	PSI	5/655 FUSE	VOLT	PH	TYPE	REMARKS
AIR-1	28.0	125.0	15.0	460	3Ø	AIR-COOLED ROTARY	I-R UP6-TTAS-125 PACKAGED AIR SYSTEM

PACKAGE CONES COMPLETE WITH COMPRESSOR, INLET AIR FILTER, REFRIGERATED AIR DRYER, AND 120-GALLON RECEIVER, WITH SINGLE POINT POWER CONNECTION.

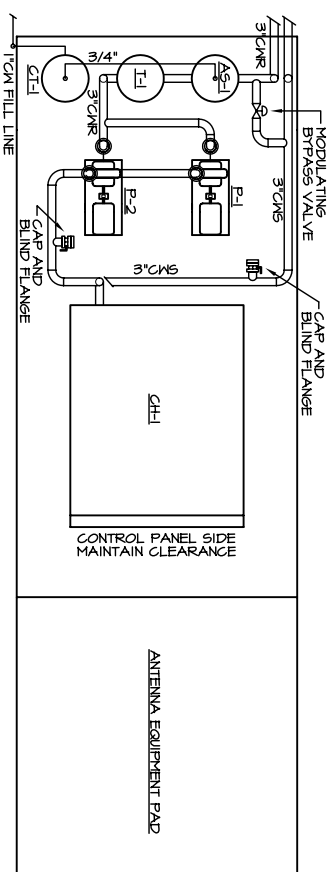


ENLARGED MECHANICAL EQUIPMENT YARD

SCALE: 1/4"=1'-0"

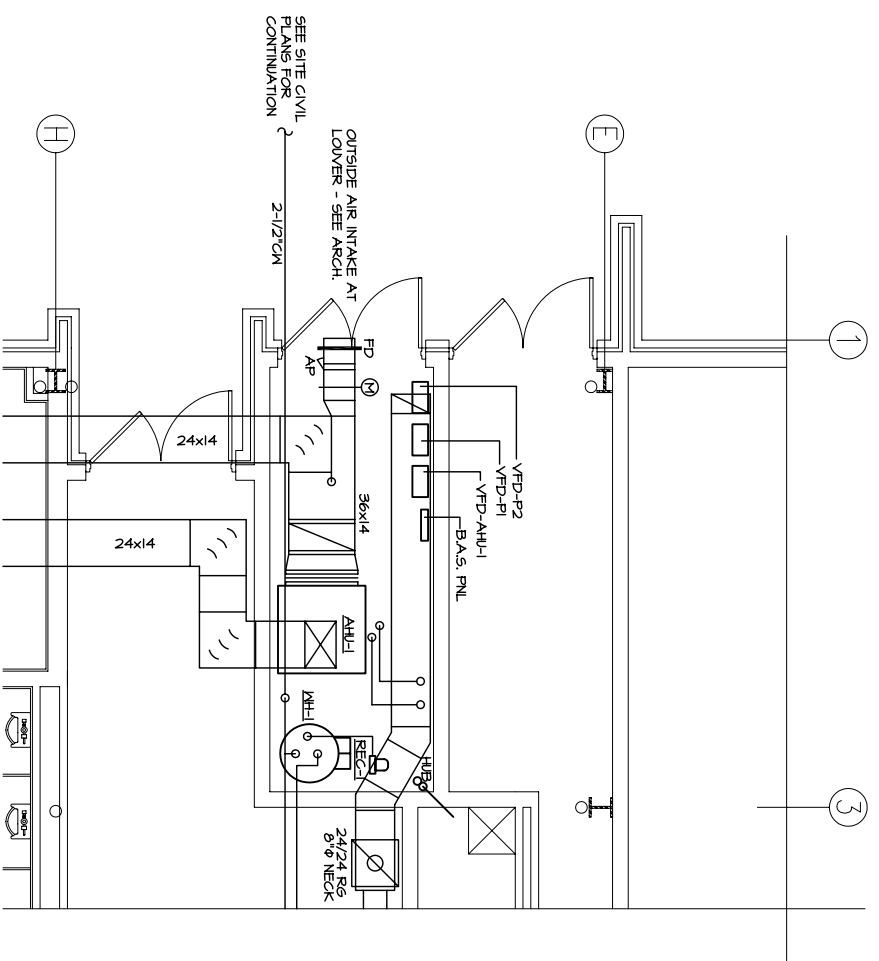

ENLARGED MECHANICAL ROOM PLAN - FIRST FLOOR

SCALE: 1/4"=1'-0"

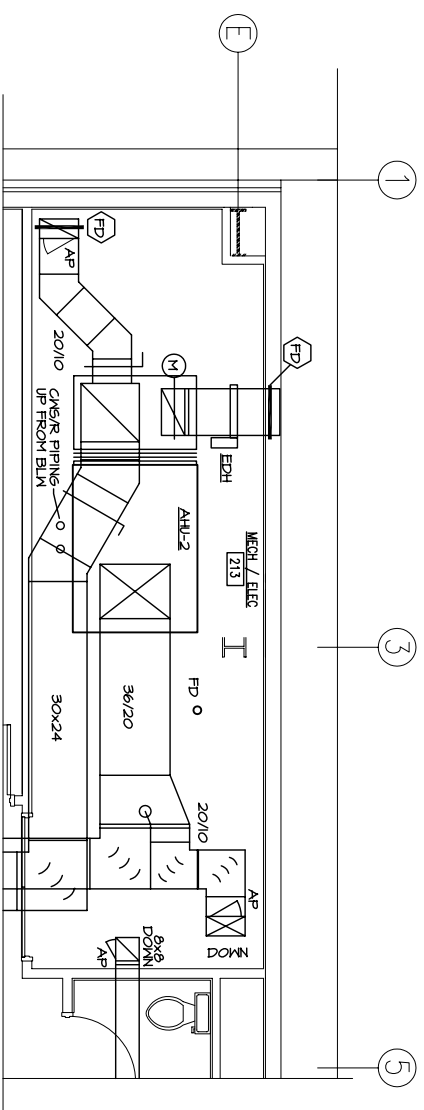

ENLARGED MECHANICAL ROOM PLAN - SECOND FLOOR

SCALE: 1/4"=1'-0"

**DAMIEN W. SERAUSKAS, P.E.**  
 PROFESSIONAL ENGINEERING SERVICES  
 115 CYPRESS POINT LANE NEW ORLEANS, LA 70131  
 VOICE: (504)866-2500 FAX: (504)219-8480

**DAMMON**  
 ENGINEERING, INC.  
 1005 FLORIDA AVENUE  
 SUITE 1000  
 SHREVEPORT, LA 70568  
 (985) 649-5832  
 www.dammon.com

REVIEWED BY: D. SERAUSKAS  
 P/W/DR: T. ARTHUR  
 CHIEF ENG/ARCH: P. DAMON

DEPARTMENT OF THE NAVY  
 NAVAL FACILITIES ENGINEERING COMMAND  
 NAVAL FACILITIES ENGINEERING COMMAND SOUTHEAST  
 RPT SOUTH ATLANTIC NAVAL AIR STATION JACKSONVILLE  
 JOHN C. STENNIS SPACE CENTER MISSISSIPPI  
**SOF RIVERINE AND COMBATANT CRAFT OPERATIONS FACILITY**

CODE 01, NO. 14412, SET 0  
 SCALE: \_\_\_\_\_  
 DRAWING NO. #####  
 TRK PROJ. NO. #####  
 WORK ORDER NO. #####  
 CONDR. CONTRACT NO. N02507-05-0-0096  
 NAVFAC DRAWING NO. \_\_\_\_\_  
 SHEET \_\_\_\_\_ OF \_\_\_\_\_  
**M3.1**