


OPERATIONS BUILDING FIRST FLOOR PLUMBING PLAN  
SCALE: 3/32" = 1'-0"  
PLAN NORTH

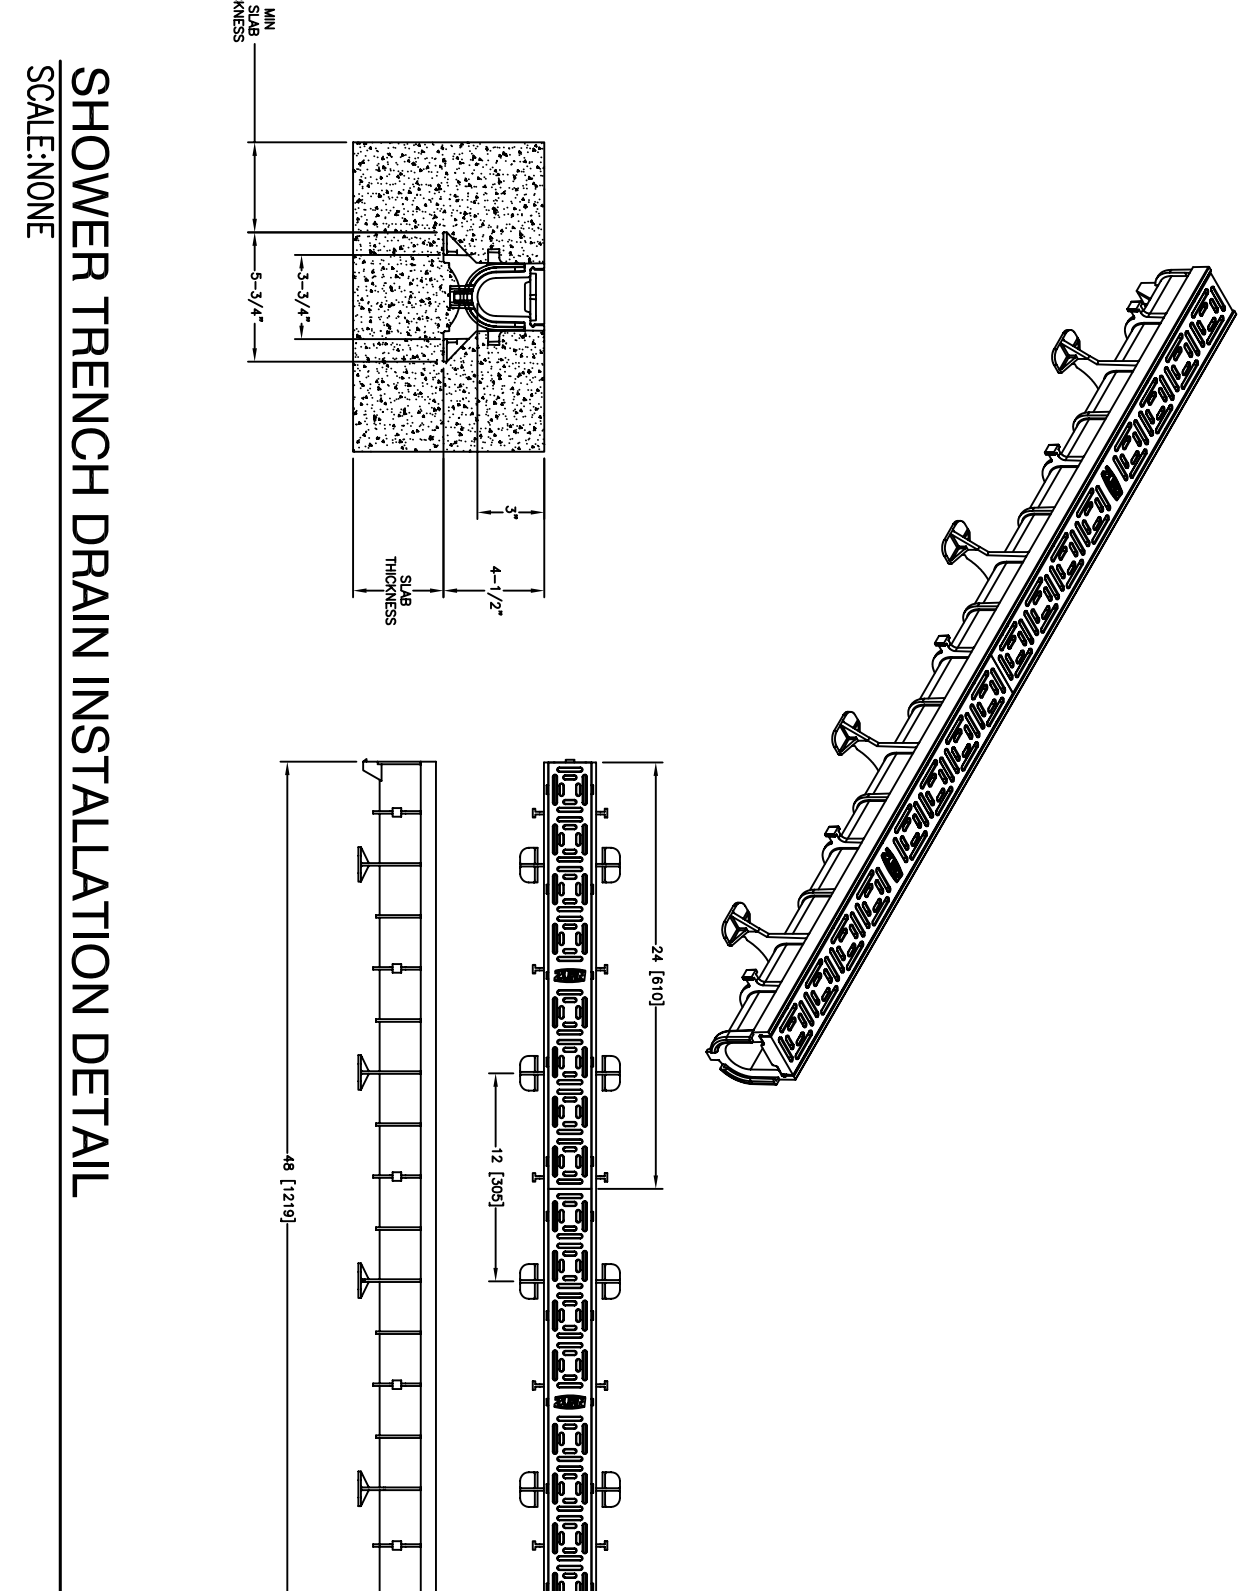

SHOWER TRENCH DRAIN INSTALLATION DETAIL  
SCALE: NONE

1  
P1.1

**DAMIEN W. SERAUSKAS, P.E.**  
PROFESSIONAL ENGINEERING SERVICES  
15 CYPRESS POINT LANE NEW ORLEANS, LA 70131  
VOICE: (504) 966-2600 FAX: (504) 218-9480

		DAMIEN W. SERAUSKAS ENGINEER, INC. 15 CYPRESS POINT LANE NEW ORLEANS, LA 70131 (504) 966-2600	DEPARTMENT OF THE NAVY NAVAL FACILITIES ENGINEERING COMMAND NAVAL FACILITIES ENGINEERING COMMAND SOUTHEAST IPT SOUTH ATLANTIC NAVAL AIR STATION JACKSONVILLE MISSISSIPPI
		JOHN C. STENNIS SPACE CENTER <b>SOF RIVERINE AND COMBATANT                  CRAFT OPERATIONS FACILITY</b> 1ST FLOOR PLUMBING PLAN AND DETAILS	ENGINEER BY: D. SERAUSKAS CHECKED BY: T. AMBER CHIEF ENGINEER: D. SERAUSKAS