


OPERATIONS BUILDING FIRST FLOOR PLUMBING PLAN  
SCALE: 3/32" = 1'-0"  
PLAN NORTH

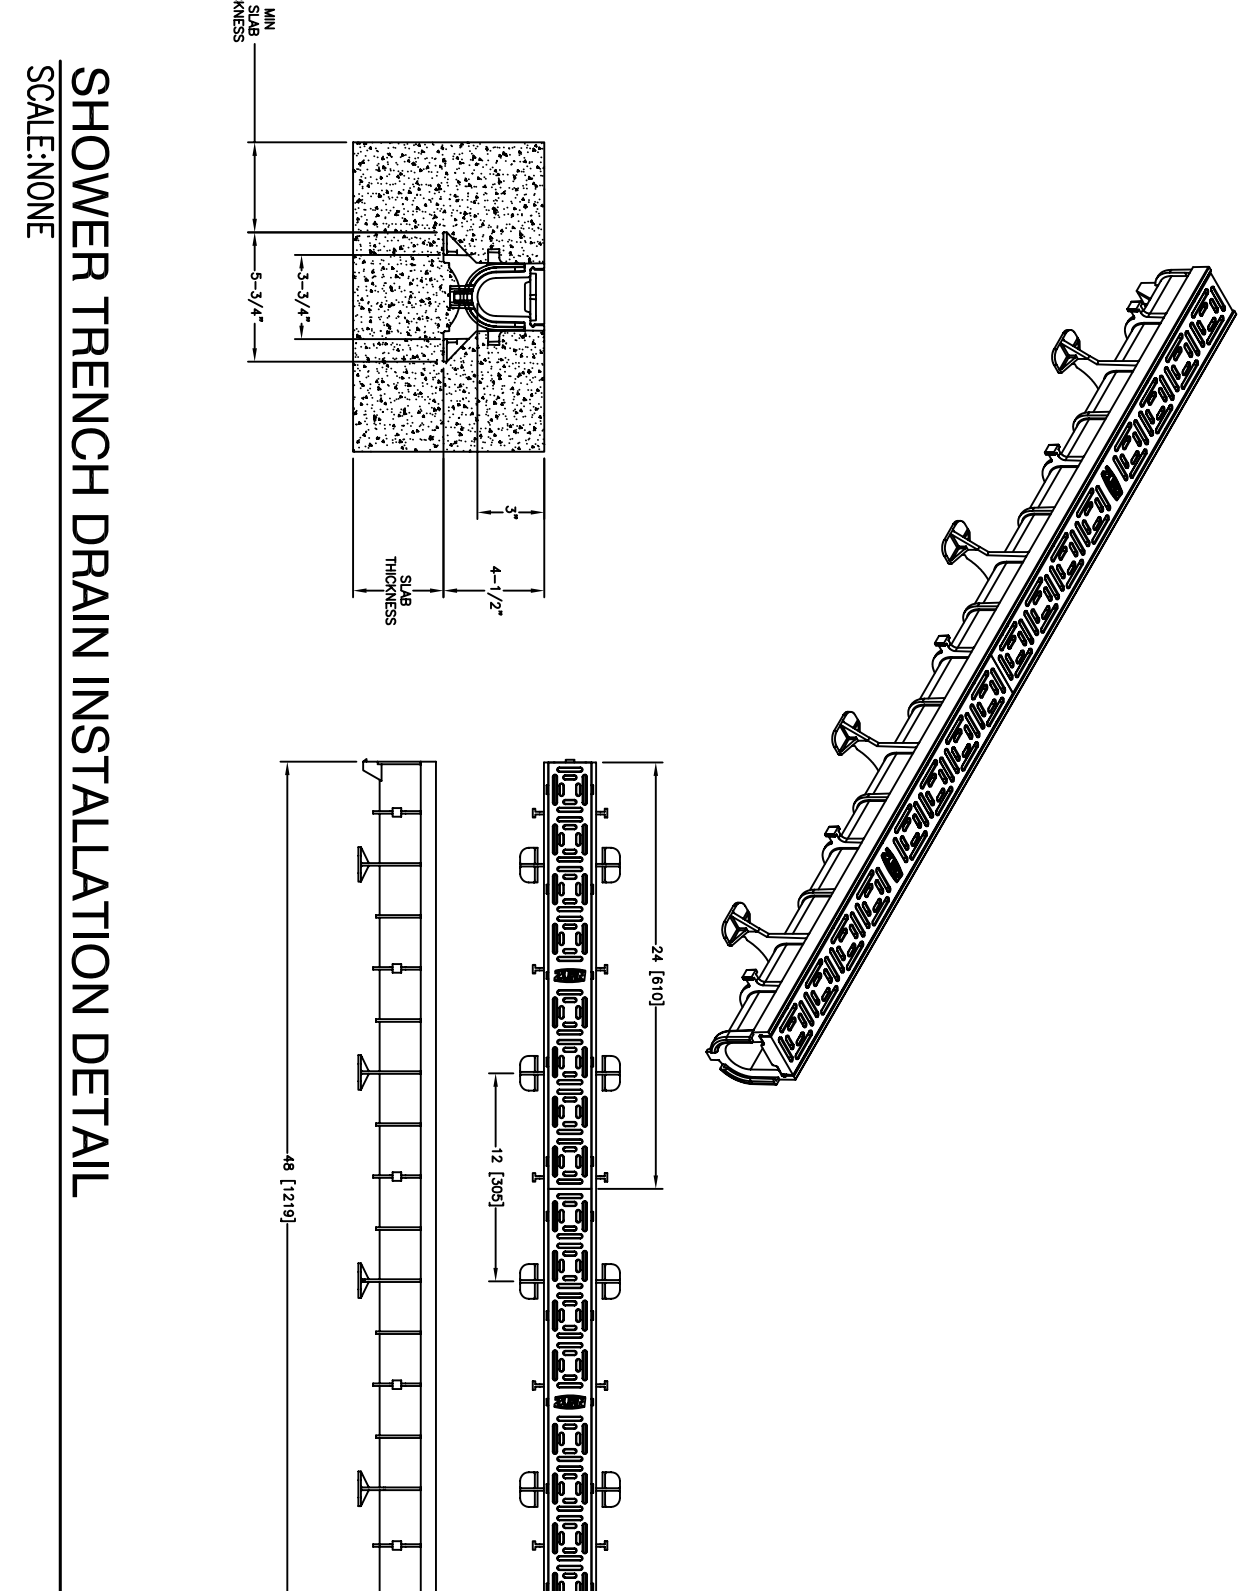

SHOWER TRENCH DRAIN INSTALLATION DETAIL  
SCALE: NONE

1  
P1.1

**DAMIEN W. SERAUSKAS, P.E.**  
PROFESSIONAL ENGINEERING SERVICES  
15 CYPRESS POINT LANE NEW ORLEANS, LA 70131  
VOICE: (504) 966-2600 FAX: (504) 218-9480

|  |  |  |  |
|--|--|--|--|
|  |  | <b>DAMIEN W. SERAUSKAS, P.E.</b><br>ENGINEER, INC.<br>15 CYPRESS POINT LANE<br>NEW ORLEANS, LA 70131<br>(504) 966-2600   | DATE: _____<br>APPR: _____   |
|  |  | DEPARTMENT OF THE NAVY<br>NAVAL FACILITIES ENGINEERING COMMAND<br>NAVAL FACILITIES ENGINEERING COMMAND SOUTHEAST<br>IPT SOUTH ATLANTIC<br>JOHN C. STENNIS SPACE CENTER<br>MISSISSIPPI<br><b>SOF RIVERINE AND COMBATANT<br/>                 CRAFT OPERATIONS FACILITY</b><br>1ST FLOOR PLUMBING PLAN AND DETAILS | ENGINEER: D. SERAUSKAS<br>ARCHITECT: T. ARMBR<br>CHECKED: D. SERAUSKAS<br>SCALE: AS NOTED<br>DATE: 05/06/09<br>DRAWING NO.: 05-D-0096<br>SHEET: 1 OF 1<br>P1.1 |