

**KEY NOTES:**


- 1 COLUMN BY METAL BLDG. MFGR.
- 2 SEE ENLARGED FLOOR PLANS OF MALE AND FEMALE HEADS ON SHT. A1.12.
- 3 SEE ENLARGED DETAIL OF STAIR 115 AND VESTIBULE 116 ON SHT. A1.13.
- 4 PASSAGE LOCKS FOR SHOWER AND HEADS. PROVIDE PRIVACY LOCKS FOR ROOMS 108, 109 AND 212.

**FIRE PROTECTION SYMBOLS**

- (WB) - FIRE EXTINGUISHER ON WALL BRACKET
- (FC) - FIRE EXTINGUISHER IN RECESSED CABINET
- (---) - ONE-HOUR WALL RATING DESIGNATION

**NOTE:**  
SEE TYP. INT. WALL SECTIONS, SHT. A1.6

**OPS. / MAINT. BLDG.  
2440/2441 FIRST FLOOR PLAN**  
SCALE: 3/32" = 1'-0"  
PLAN NORTH

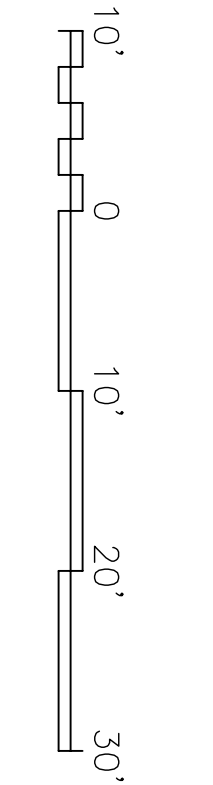


| ROOM # | ROOM NAME                  | SQ. FT.      |
|--------|----------------------------|--------------|
| 100    | CANOPY ENTRANCE            | REC'D./PRVD. |
| 101    | REAR ENTRY                 | NA/44'       |
| 102    | ENTRY                      | NA/20'       |
| 103    | LOBBY                      | 1207/114'    |
| 104    | SIDE ENTRY                 | NA/315'      |
| 105    | AGENTS                     | NA/45'       |
| 106    | CSS                        | 3825/4516'   |
| 107    | ARMORY                     | 1207/220'    |
| 108    | SHOWER                     | 1500/1484'   |
| 109    | HEAD                       | 51/77'       |
| 110    | JANITOR                    | 37/66'       |
| 111    | MALE HEAD                  | 32/100'      |
| 112    | MALE SHOWER                | 2707/204'    |
| 113    | ELECTRICAL                 | 1807/191'    |
| 114    | MECHANICAL                 | 1497/158'    |
| 115    | STAIRS                     | 1207/130'    |
| 116    | VESTIBULE                  | 4007/267'    |
| 116    | VESTIBULE                  | NA/66'       |
| 200    | CORRIDOR                   | NA/983'      |
| 201    | TEL. COMM.                 | 1207/148'    |
| 202    | RADIO ROOM                 | 2007/197'    |
| 203    | BRIEFING                   | 9787/1025'   |
| 204    | RUOC                       | 3607/395'    |
| 205    | RUOC                       | 6607/339'    |
| 206    | RUOC                       | 6607/339'    |
| 207    | RUOC OPS CONTROL WATCH     | 3007/205'    |
| 208    | SITUCO                     | 3607/389'    |
| 209    | RUOC                       | 4807/855'    |
| 210    | RUOC                       | 3607/399'    |
| 210    | RUOC                       | 6607/324'    |
| 211    | MALE HEAD                  | 2707/197'    |
| 212    | FEMALE HEAD                | 367/327'     |
| 213    | MECHANICAL/ELECTRICAL ROOM | 1207/327'    |
| 214    | JANITOR                    | 357/311'     |
| 215    | STAIRS                     | 4007/267'    |
| 216    | COPY AREA                  | NA/74'       |
| 217    | CHART ROOM                 | NA/122'      |

DEPARTMENT OF THE NAVY  
NAVAL FACILITIES ENGINEERING COMMAND SOUTHEAST  
NAVAL AIR STATION JACKSONVILLE  
MISSISSIPPI  
JOHN C. STENNIS SPACE CENTER  
**SOF RIVERINE AND COMBATANT CRAFT OPERATIONS FACILITY - PRE-FINAL**  
OPS./MAINT. BLDG. 2440/2441 1ST FLR. PLAN

DESIGNED BY: R. WITSE  
DRAWN BY: J. HERRMAN  
CHECKED BY: T. ARBIB  
CHIEF ENGINEER: P. DAMON

**DAMMON ENGINEERING, INC.**  
REGISTERED PROFESSIONAL ENGINEER  
STATE OF MISSISSIPPI  
SIBDILL, LA 39352  
(980) 649-8332  
September 4, 2009

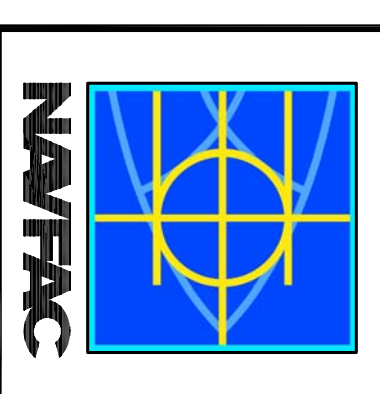

| SYM | DESCRIPTION                                | DATE    | APPR |
|-----|--|---------|------|
|     | REVISED AS PER URS COMMENTS 9 OCTOBER 2009 | 11-6-09 | RW   |



PROJECT NO. N62467-05-0-0096  
WORK ORDER NO. 510247  
DRAWING NO. 15006678  
SHEET 31 OF 132