


A


 
B

C

D

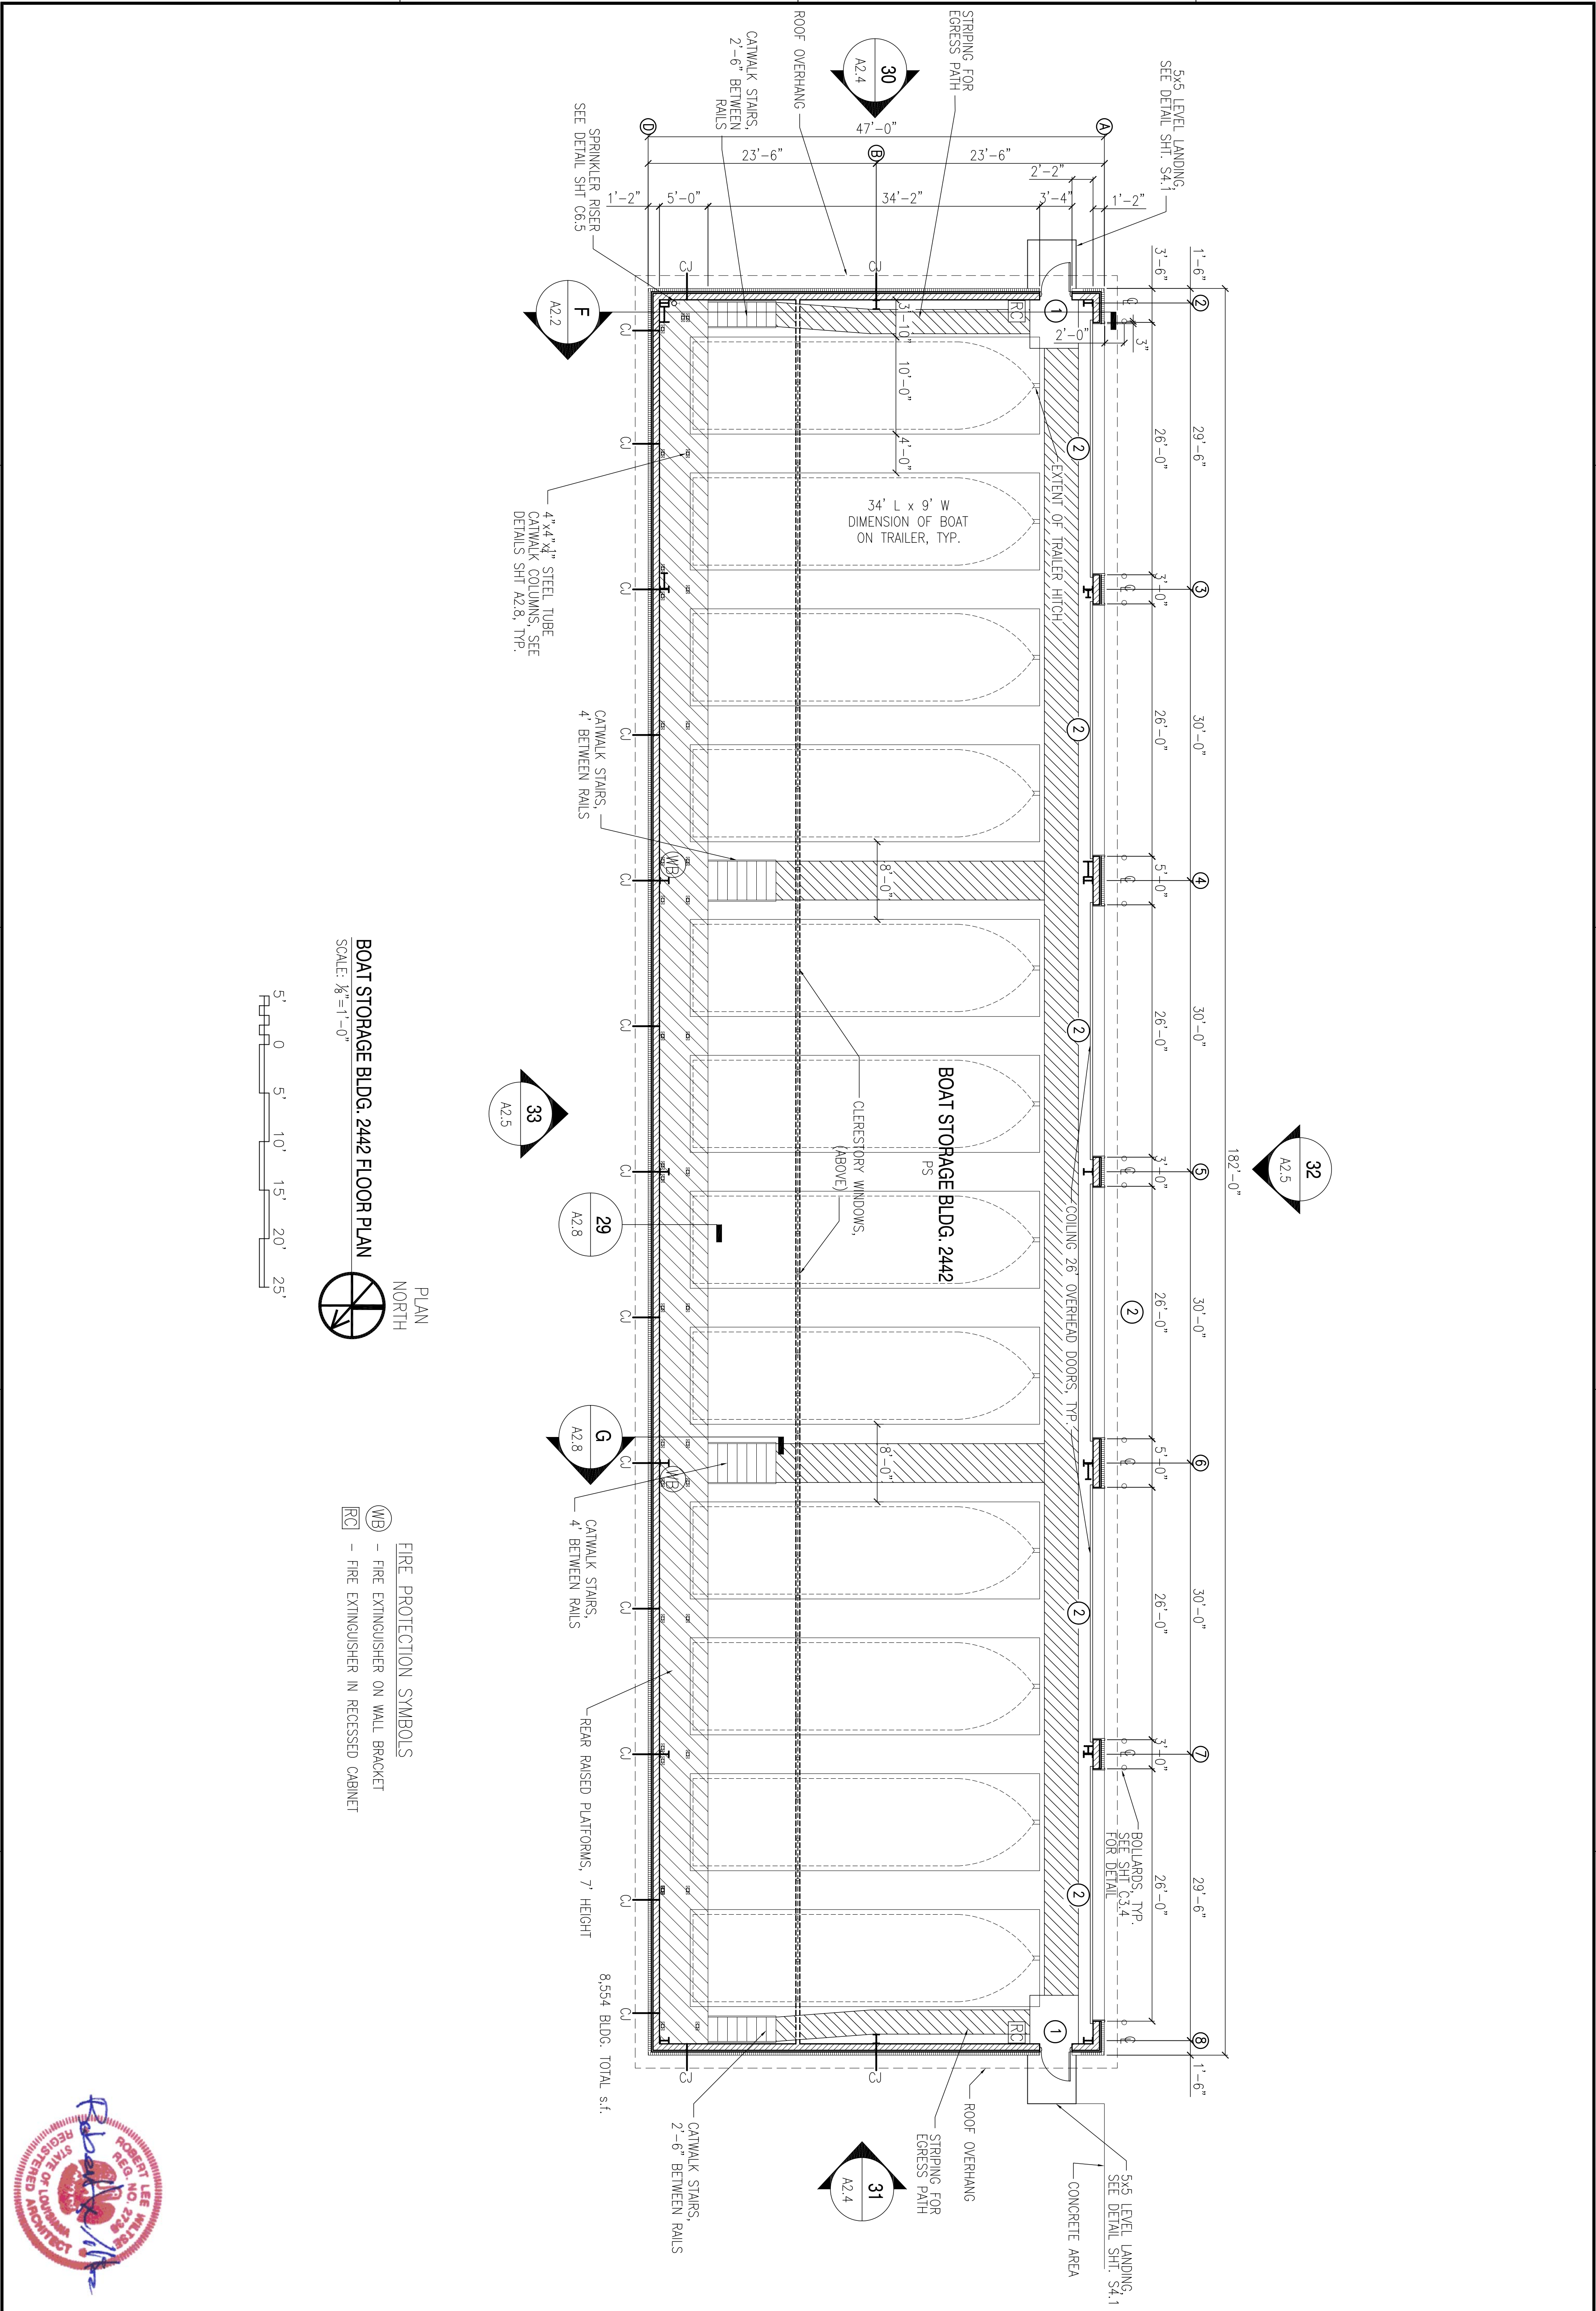

BOAT STORAGE BLDG. 2442 FLOOR PLAN
SCALE: 1/8" = 1'-0"

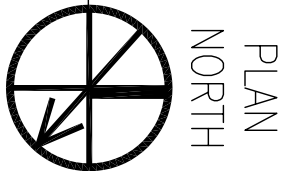

- FIRE PROTECTION SYMBOLS**
- (WB) - FIRE EXTINGUISHER ON WALL BRACKET
 - (RC) - FIRE EXTINGUISHER IN RECESSED CABINET



DEPARTMENT OF THE NAVY NAVAL FACILITIES ENGINEERING COMMAND SOUTHEAST NAVAL AIR STATION JACKSONVILLE MISSISSIPPI JOHN C. STENNIS SPACE CENTER SOF RIVERINE AND COMBATANT CRAFT OPERATIONS FACILITY - PRE-FINAL BOAT STORAGE BLDG. 2442 FLOOR PLAN		DAMMON ENGINEERING, INC. ENGINEER CHEF ARCHITECT DAMMON, P. E. & ASSOCIATES SIOUX FALLS, SD 57105 (605) 649-3312 ESTABLISHED 1962	EMMETT B. DAMMON LICENSED PROFESSIONAL ARCHITECT STATE OF MISSISSIPPI 9662	REVISIONS AS PER URS COMMENTS 9 OCTOBER 2009 DATE: 11-6-09 APPR: RW
DESIGNED BY: R. WITSE DRAWN BY: J. JEFFREY CHECKED BY: R. WITSE IN CHARGE: P. DAMMON	CODE ID NO. N4412 SCALE: AS SHOWN STA. PROJ. NO. P-210 WORK ORDER NO. S10247 CONSTR. CONTR. NO. N62467-05-0-0096 NAFAC DRAWING NO. 15026701 SHEET 54 OF 132	DEPARTMENT OF THE NAVY NAVAL FACILITIES ENGINEERING COMMAND SOUTHEAST NAVAL AIR STATION JACKSONVILLE MISSISSIPPI JOHN C. STENNIS SPACE CENTER SOF RIVERINE AND COMBATANT CRAFT OPERATIONS FACILITY - PRE-FINAL BOAT STORAGE BLDG. 2442 FLOOR PLAN	REVISED AS PER URS COMMENTS 9 OCTOBER 2009 DATE: 11-6-09 APPR: RW	

A

B

C

D

1

2

3

4

5

1

2

3

4

5