



NOTE: WATER DISTRIBUTION MAINS TO BE PVC PRESSURE PIPE. PROVIDE DUCTILE IRON PIPE FOR DIAMETERS GREATER THAN 12" DEPTHS GREATER THAN 10' AND FLANGED DUCTILE IRON PIPE FOR ALL ABOVE GROUND LOCATIONS.

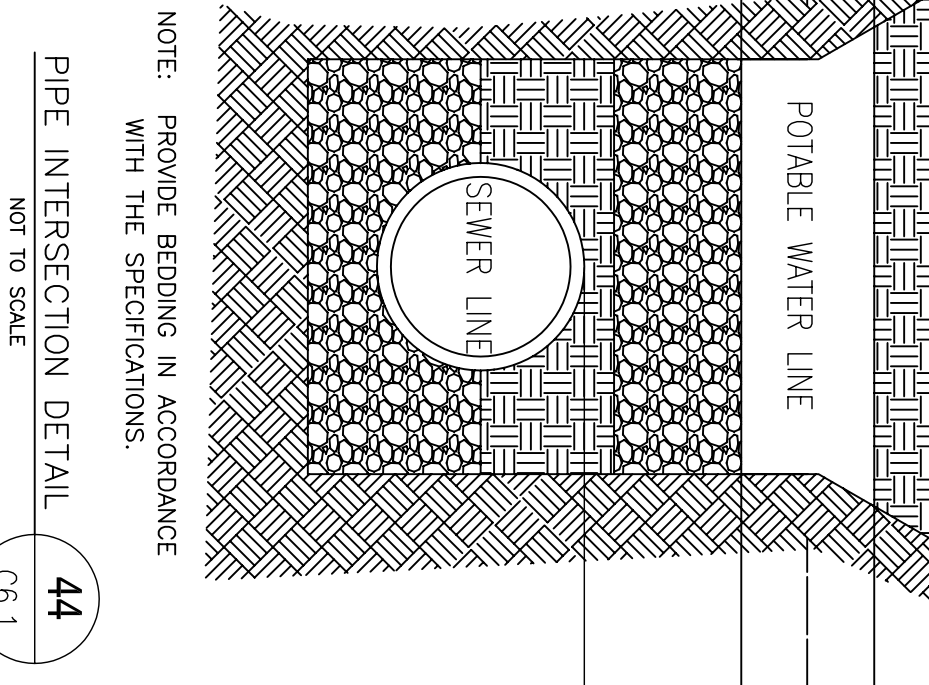

SYMBOL	DESCRIPTION
S	SANITARY SEWER
PW	COLD WATER (POTABLE)
F	EXISTING SEWER
F	FIRE PROTECTION

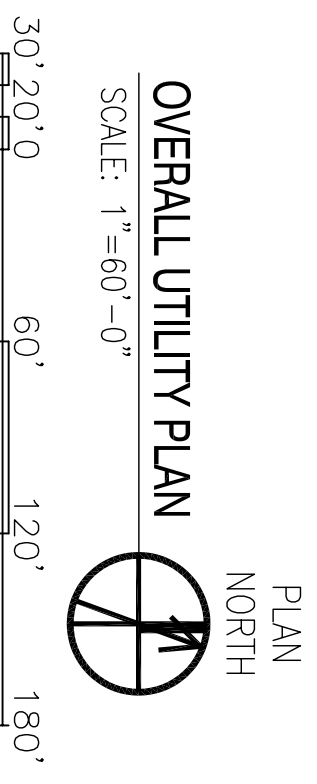

DEPARTMENT OF THE NAVY NAVAL FACILITIES ENGINEERING COMMAND SOUTHEAST IPT GULF COAST JOHN C. STENNIS SPACE CENTER MISSISSIPPI <b>SOF RIVERINE AND COMBATANT CRAFT OPERATIONS FACILITY - PRE-FINAL</b> OVERALL UTILITY PLAN		NAVAL FACILITIES ENGINEERING COMMAND SOUTHEAST NAVAL AIR STATION JACKSONVILLE MISSISSIPPI JOHN C. STENNIS SPACE CENTER MISSISSIPPI	RES: C. DAMMON, I. DEWE, C. DAMMON REGISTERED BY: R. WILSEY P/W/INK: T. ARBIB CHIEF ENGINEER: P. DAMMON	EMMETT B. DAMMON LICENSED PROFESSIONAL ENGINEER STATE OF MISSISSIPPI 9682	DAMMON ENGINEERING, INC. 1000 PINE BLVD., SUITE 200 DARMON, LA 70017 SIOULL, LA 70362 (985) 649-4312 SEPTEMBER 9, 2009		REVISED AS PER URS COMMENTS 9 OCTOBER 2009 11-6-09 RW APPR
CODE ID: NO. N4412 SCALE: AS SHOWN SHEET NO.: P-210 WORK ORDER NO.: 510247 CONSTR. CONTR. NO.: N62467-05-0-0096 NAVFAC DRAWING NO.: 15026/672 SHEET: 23 OF 132	SHEET NO. 23 OF 132 06.1						