



REVDATE:

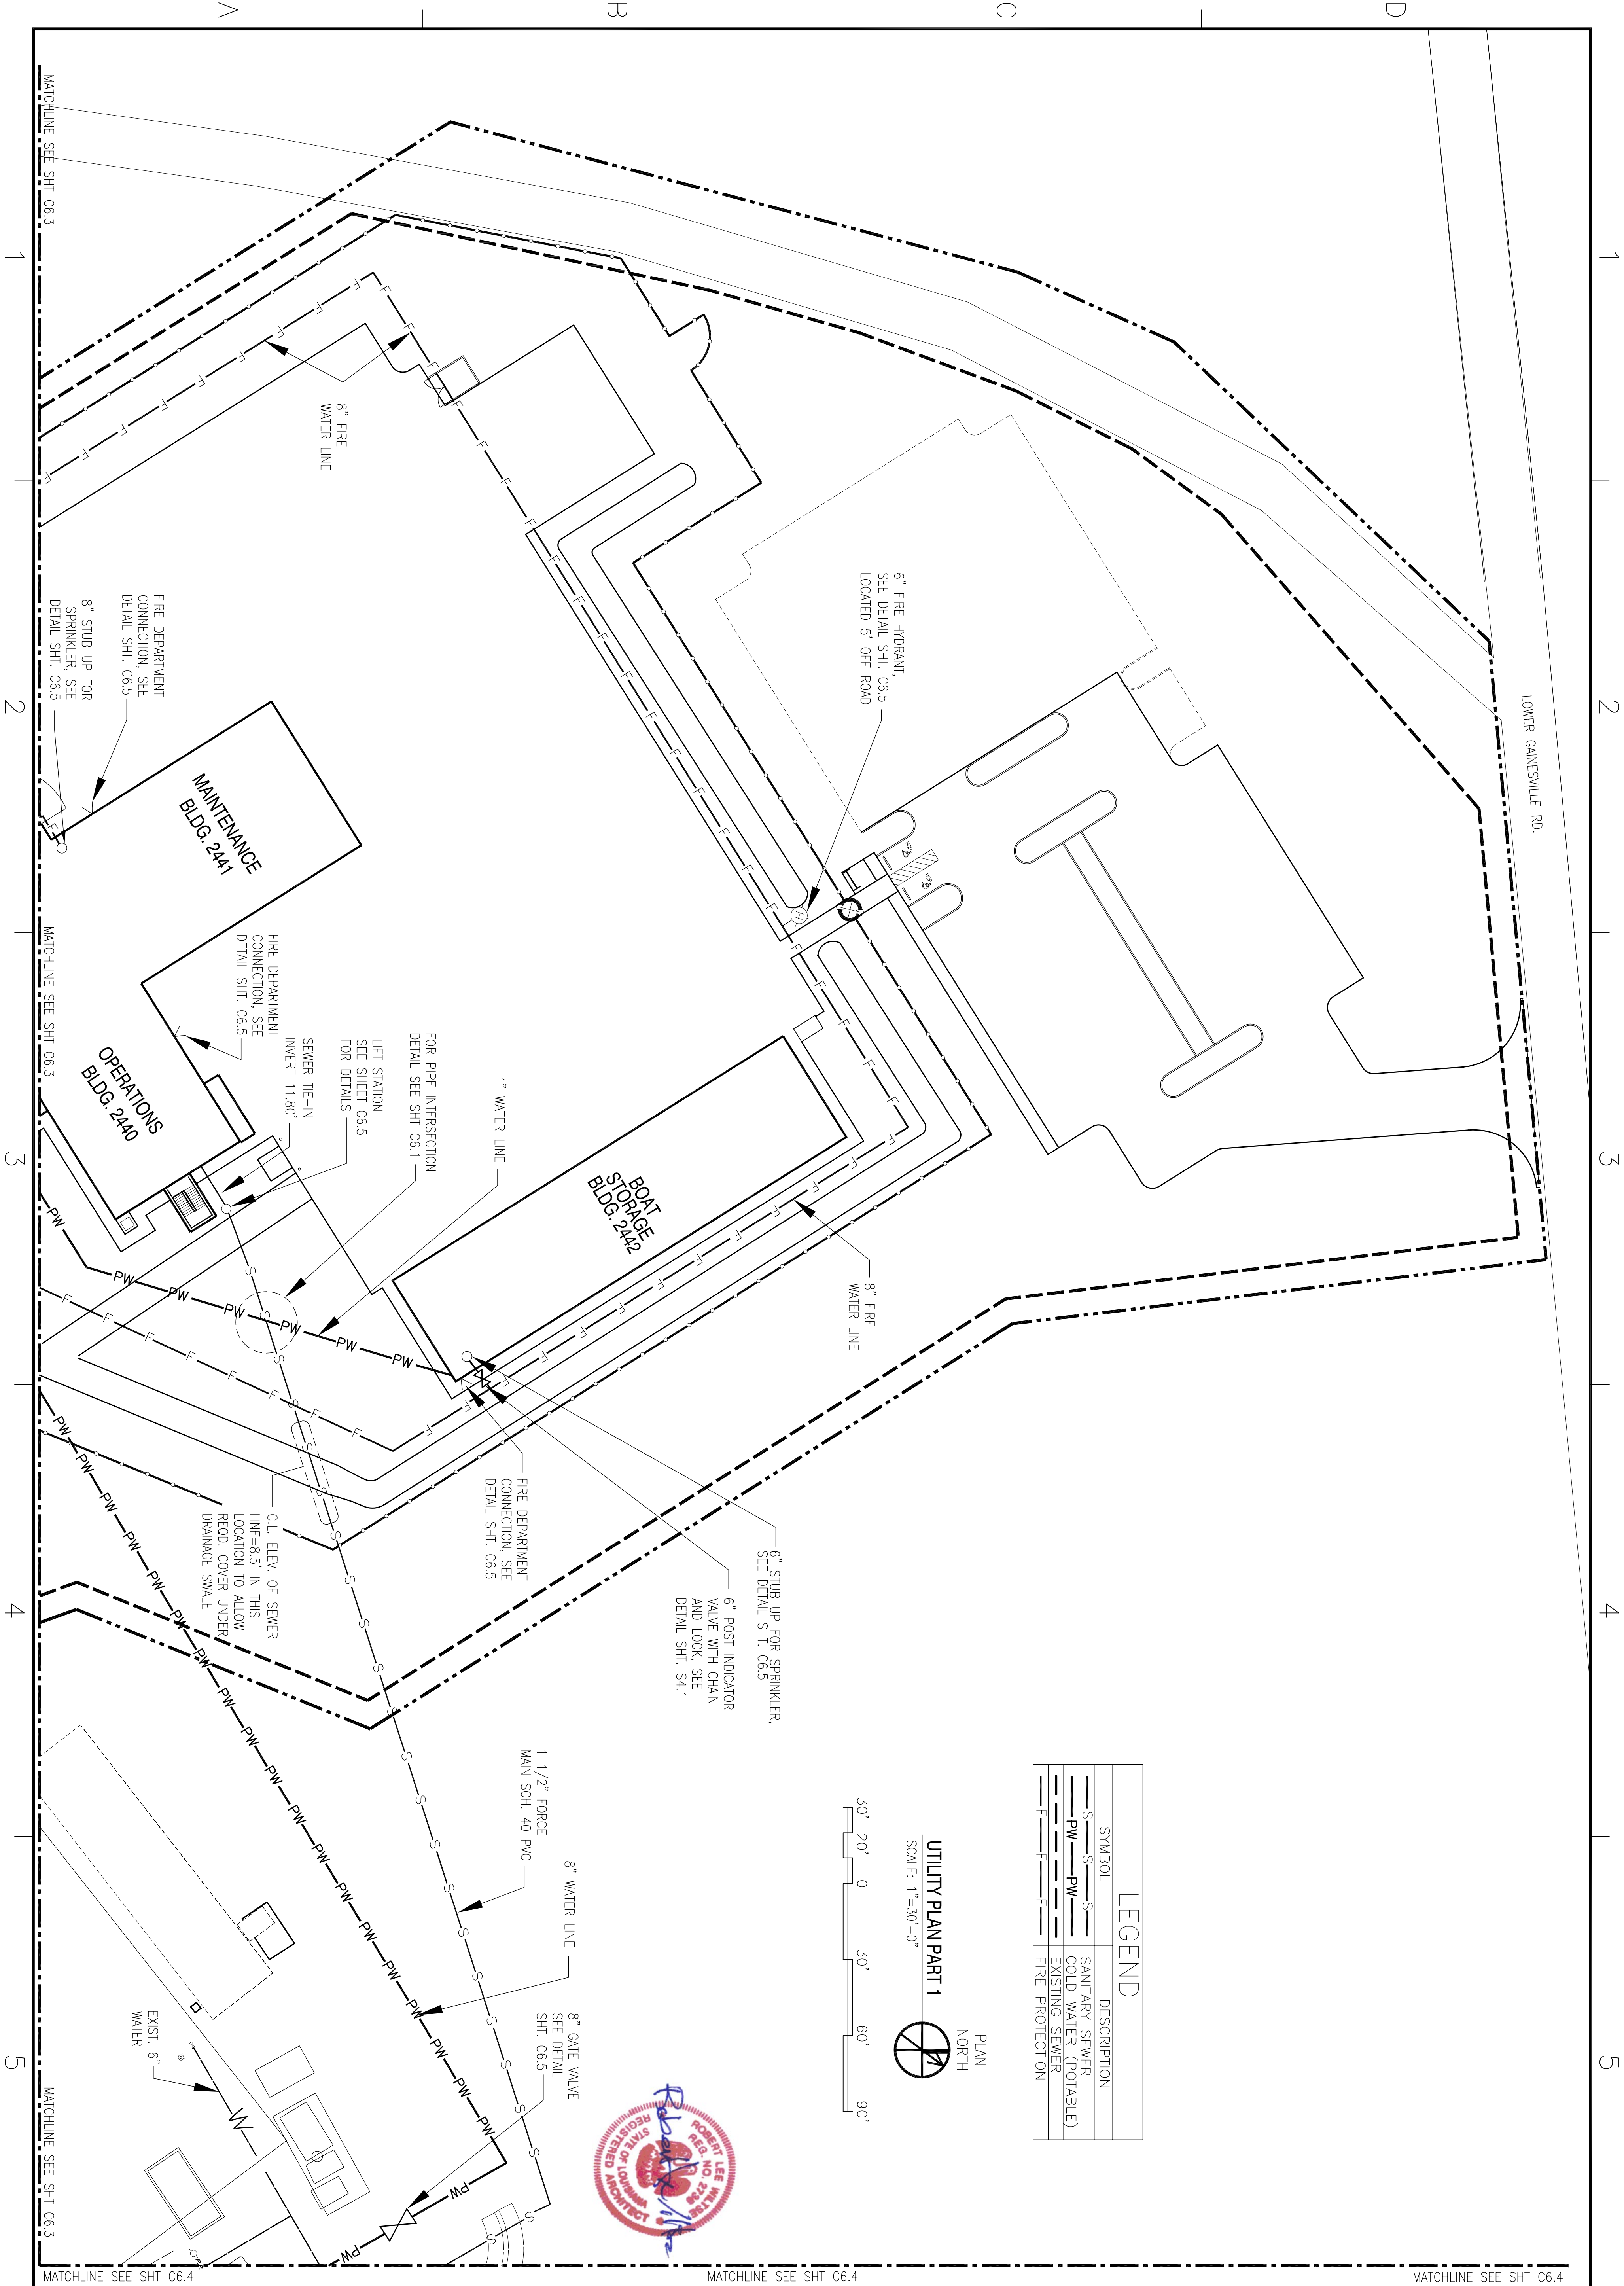

LEGEND	
SYMBOL	DESCRIPTION
S	SANITARY SEWER
PW	COLD WATER (POTABLE)
—	EXISTING SEWER
F	FIRE PROTECTION

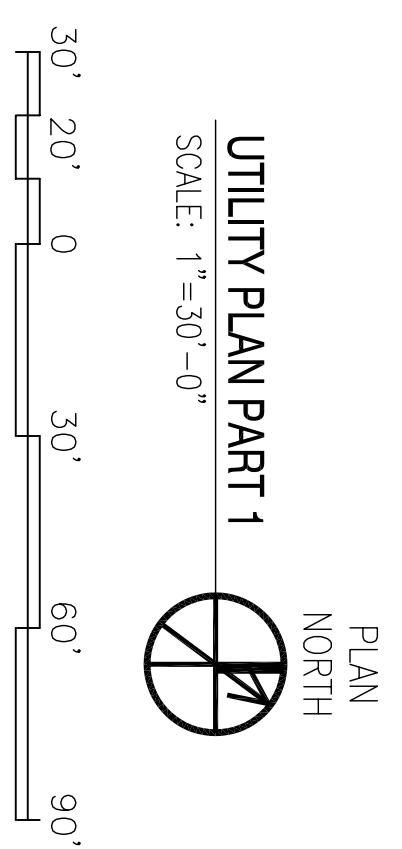

DEPARTMENT OF THE NAVY NAVAL FACILITIES ENGINEERING COMMAND SOUTHEAST NAVAL AIR STATION JACKSONVILLE IPT GULF COAST		NAVAL FACILITIES ENGINEERING COMMAND MISSISSIPPI SOF RIVERINE AND COMBATANT CRAFT OPERATIONS FACILITY - PRE-FINAL		UTILITY PLAN PART 1	
JOHN C. STENNIS SPACE CENTER		MISSISSIPPI		DAMMON ENGINEERING, INC. ENGINEER CHEF ENGINEER DAMMON, P. O. BOX 4432 SIBOLLA, LA 70582 (985) 649-4312 <small>September 4, 2009</small>	
CODE ID NO. N4412 SIZE: D SCALE: AS SHOWN DRAWING NO. ##### STA. PROJ. NO. P-210 WORK ORDER NO. 510247 CONSTR. CONTR. NO. N62467-05-D-0096 NAFAC DRAWING NO. 15026673 SHEET 26 OF 132					
REVISIONS: DESIGNED BY: R. WILSON DRAWN BY: T. ARBERG CHECKED BY: P. DAMMON		REVISED AS PER URS COMMENTS 9 OCTOBER 2009		11-6-09 RW DATE APPR	