


A



B

C

D

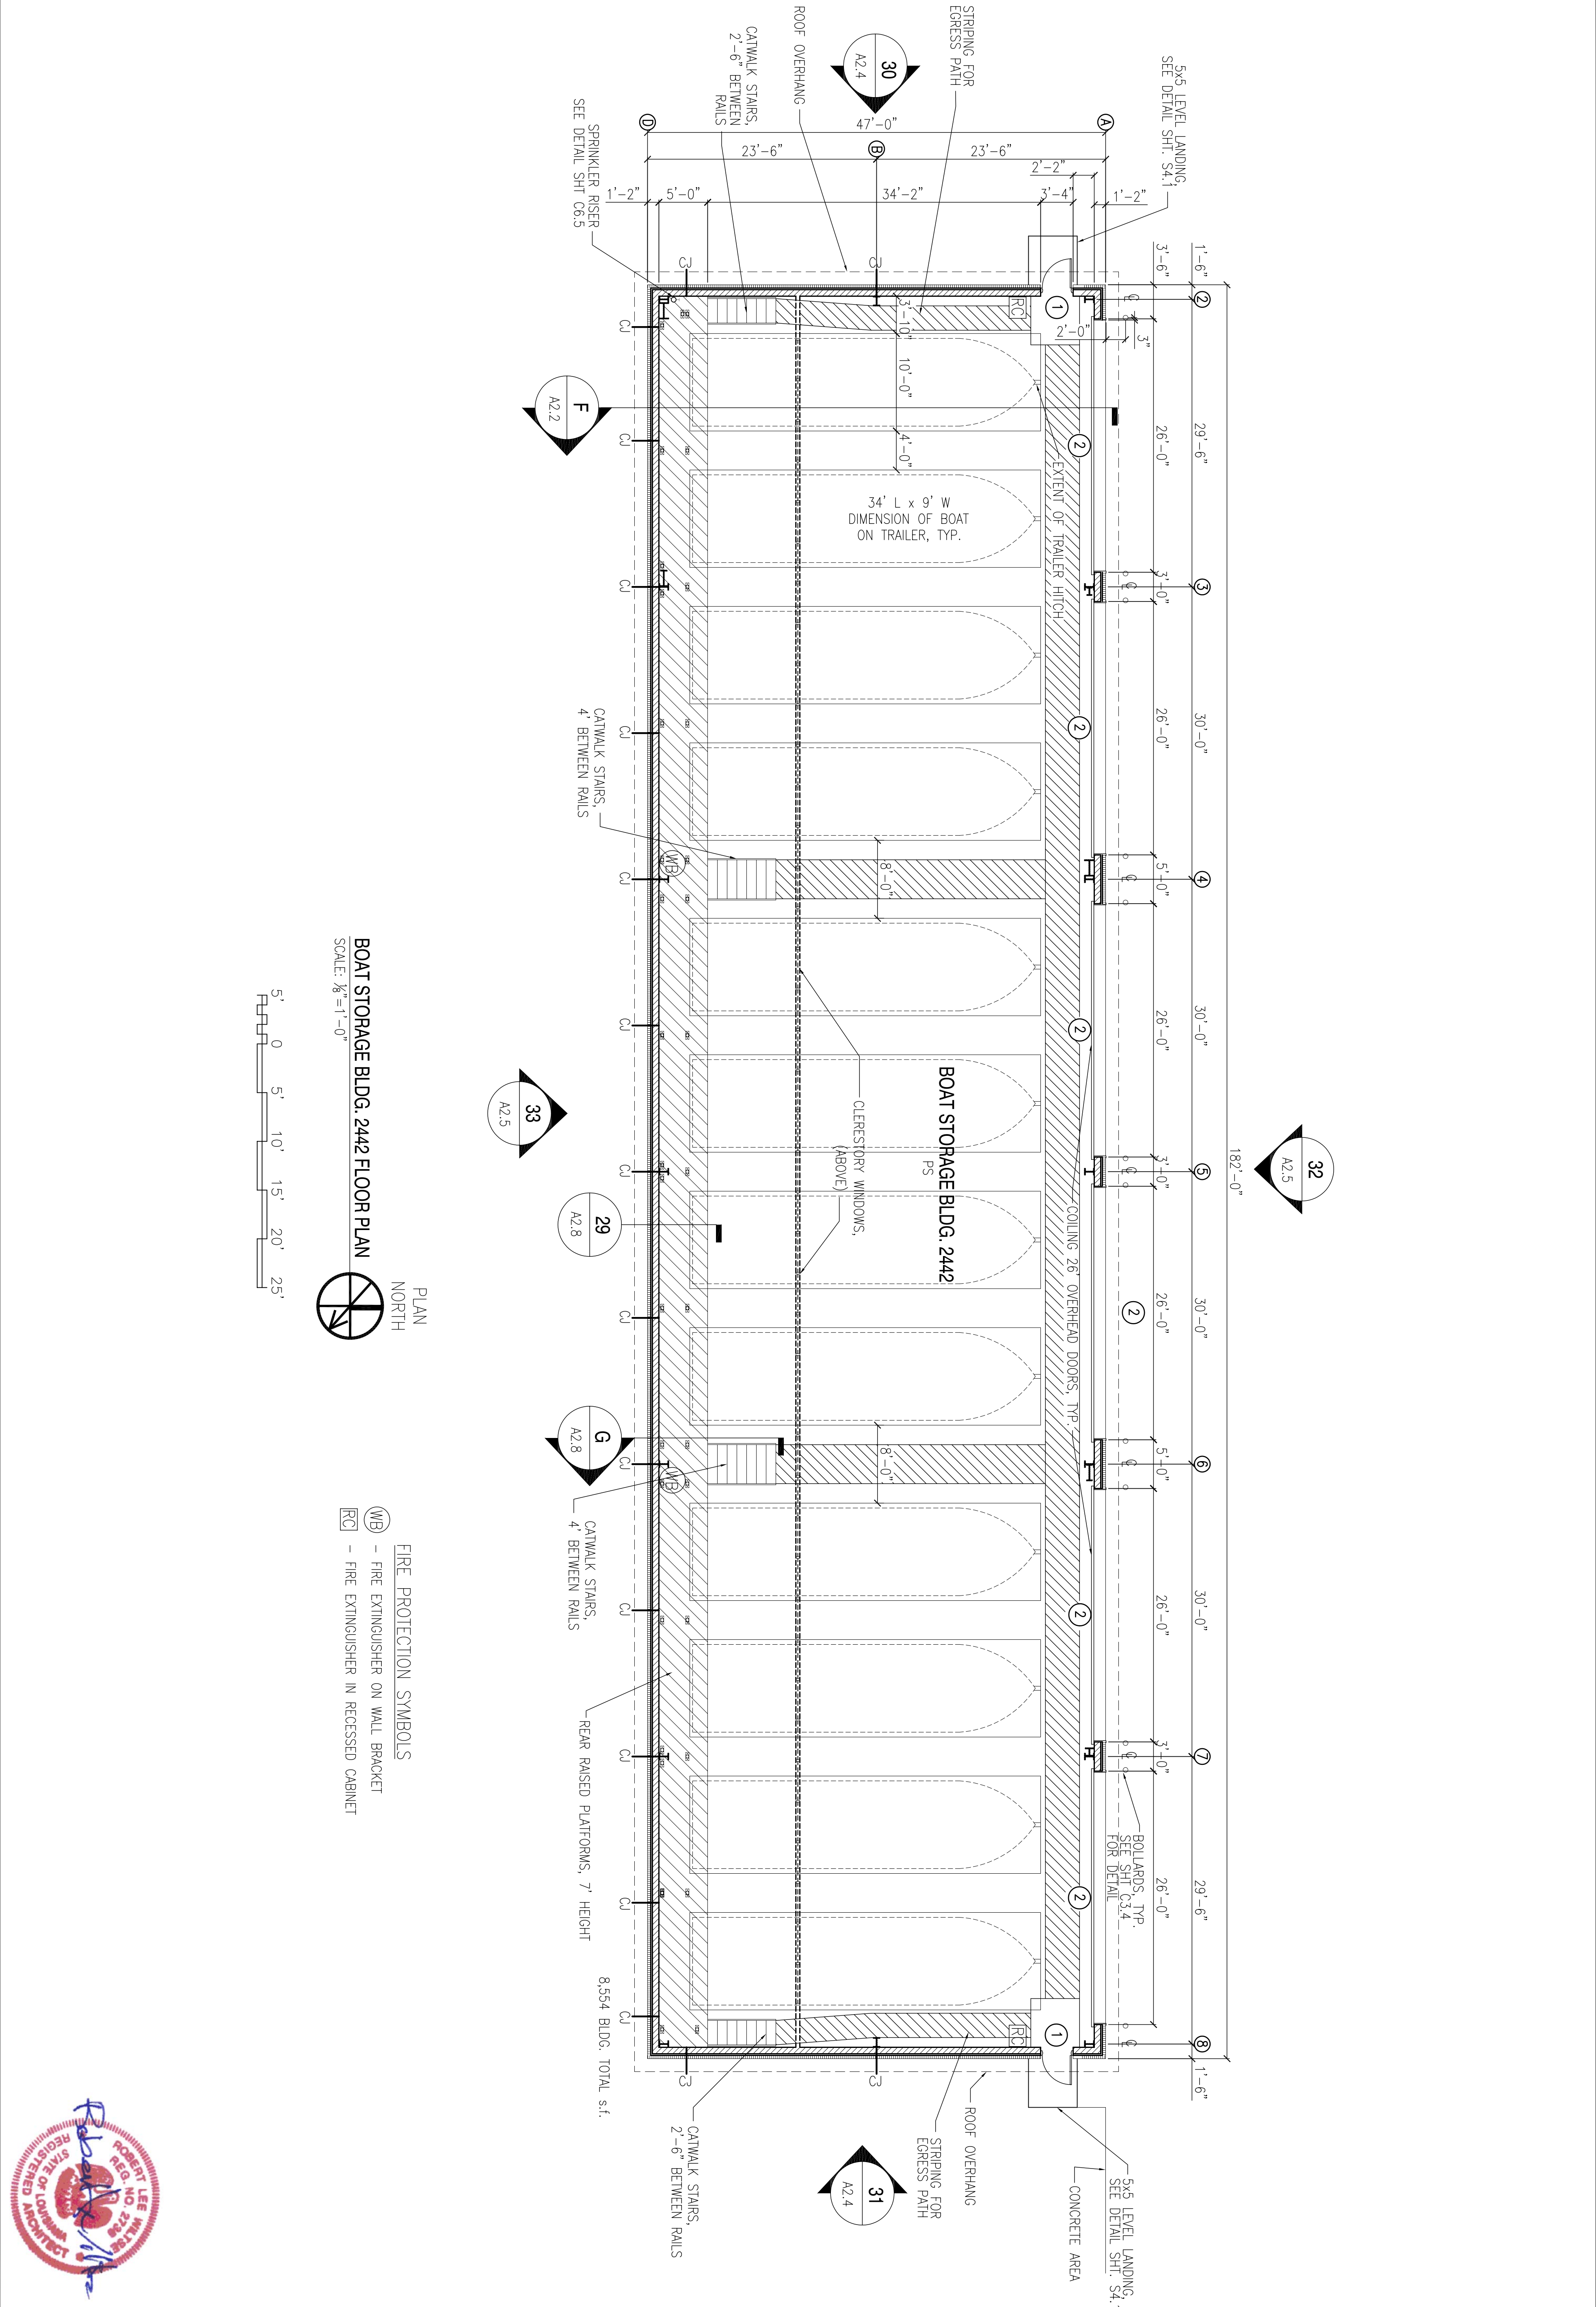

BOAT STORAGE BLDG. 2442 FLOOR PLAN
SCALE: 1/8" = 1'-0"

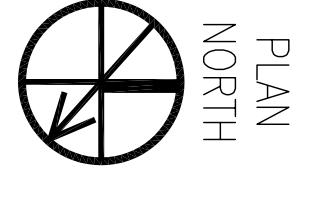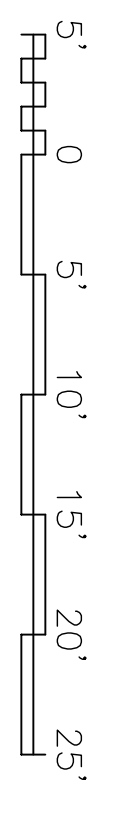

- FIRE PROTECTION SYMBOLS**
- (WB) - FIRE EXTINGUISHER ON WALL BRACKET
 - (RC) - FIRE EXTINGUISHER IN RECESSED CABINET



<p>DEPARTMENT OF THE NAVY NAVAL FACILITIES ENGINEERING COMMAND SOUTHEAST NAVAL AIR STATION JACKSONVILLE MISSISSIPPI</p> <p>JOHN C. STENNIS SPACE CENTER SOF RIVERINE AND COMBATANT CRAFT OPERATIONS FACILITY - PRE-FINAL BOAT STORAGE BLDG. 2442 FLOOR PLAN</p>	<p>DESIGNER: R. WITSE DRAWN: J. JEFFREY ENGINEERED BY: R. WITSE CHECKED BY: T. ARBUSH PROJECT MANAGER: P. DAMMON</p>	<p>EMMETT B. DAMMON REGISTERED PROFESSIONAL ENGINEER STATE OF MISSISSIPPI LICENSE NO. 9662</p>	<p>DAMMON ENGINEERING, INC. CORPORATE OFFICE DAMMON, P. O. BOX 4432 SODDLE LA PINE, LA 70089 (985) 649-8312</p>	<p>NAVFAC</p>	<table border="1"> <thead> <tr> <th>SYM</th> <th>DESCRIPTION</th> <th>DATE</th> <th>APPR</th> </tr> </thead> <tbody> <tr> <td> </td> <td> </td> <td> </td> <td> </td> </tr> <tr> <td> </td> <td> </td> <td> </td> <td> </td> </tr> <tr> <td> </td> <td> </td> <td> </td> <td> </td> </tr> <tr> <td> </td> <td> </td> <td> </td> <td> </td> </tr> </tbody> </table>	SYM	DESCRIPTION	DATE	APPR																
SYM	DESCRIPTION	DATE	APPR																						

A

B

C

D

1

2

3

4

5

1

2

3

4

5