

A

B

C

D

1

2

3

4

5


MATCHLINE SEE SHIT. C1.2

MATCHLINE SEE SHIT. C1.2

MATCHLINE SEE SHIT. C1.2

ANTENNA PAD 12'x12'
CHILLER PAD 12'x24'
GENERATOR PAD 13'2"x22'8"

GOVERNMENT PARKING SPACES
50 GOVERNMENT VEHICLES

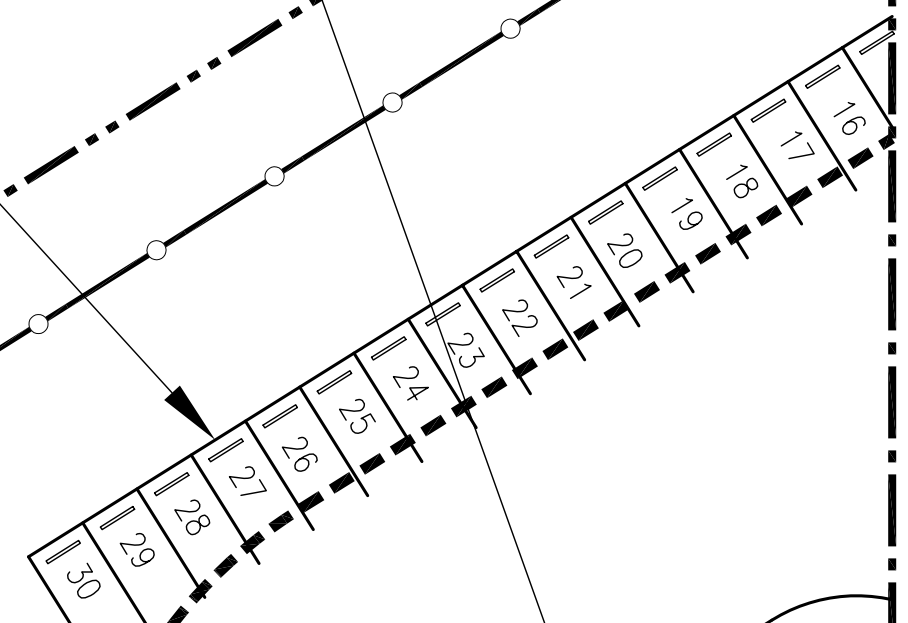

SECURITY FENCE, TYP.
SEE DETAIL SHIT. C1.4

PRIMARY GATHERING BUILDING

OPERATIONS BLDG. 2440

SEE ENLARGED DETAIL ACCESS RD. WITH CARD READERS ON SHIT. C3.3

EXISTING CONCRETE DITCH

FOR CURB DETAIL, SEE SHIT. C3.2

LOCKABLE SINGLE LEAF 12' SWING GATE, SEE DETAIL SHIT. C1.6

 
4' PERSONNEL GATE ACCESS W/ CARD READERS ON EACH SIDE, SEE DETAIL SHIT. C1.5

ELECTRIC VEHICULAR GATE, SINGLE ROLLING CANTILEVER GATE W/ CARD READERS ON EACH SIDE, SEE DETAIL SHIT. C1.5

4' WIDE CHANNELIZATION ISLAND W/ CARD READERS ON BOTH SIDES 15' FROM FENCE

5' WIDE SIDEWALK, SEE DETAIL SHIT. C3.2

STOP SIGN



SITE PLAN PART 2
SCALE: 1"=30'-0"



SYM	DESCRIPTION	DATE	APPR

DAMMON ENGINEERING, INC.
 1000 PINEAPPLE CHAMP DRIVE
 DAMMON, LA 70038
 (985) 649-5832
 ESTABLISHED 1978

EMMETT G. DAMMON
 LICENSED PROFESSIONAL ENGINEER
 STATE OF MISSISSIPPI
 9662

DEPARTMENT OF THE NAVY
NAVAL FACILITIES ENGINEERING COMMAND SOUTHEAST
 IPT GULF COAST
 NAVAL AIR STATION JACKSONVILLE
 MISSISSIPPI
JOHN C. STENNIS SPACE CENTER
SOF RIVERINE AND COMBATANT CRAFT OPERATIONS FACILITY - PRE-FINAL
SITE PLAN PART 2

DESIGNER: R. WITSE
 CHECKED BY: R. WITSE
 DRAWN BY: T. ARBIB
 PROJECT: CHIEF ENGINEER, P. DAMMON

CODE ID. NO. N4412 | SIZE: D
 SCALE: AS SHOWN
 DRAWING NO. #####
 STA. PROJ. NO. P-210
 WORK ORDER NO. 510247
 CONSTR. CONTR. NO. N62467-05-0-0096
 NAVFAC DRAWING NO. 15026556
 SHEET 9 OF 132

A

B

C

D