


REVDATE:

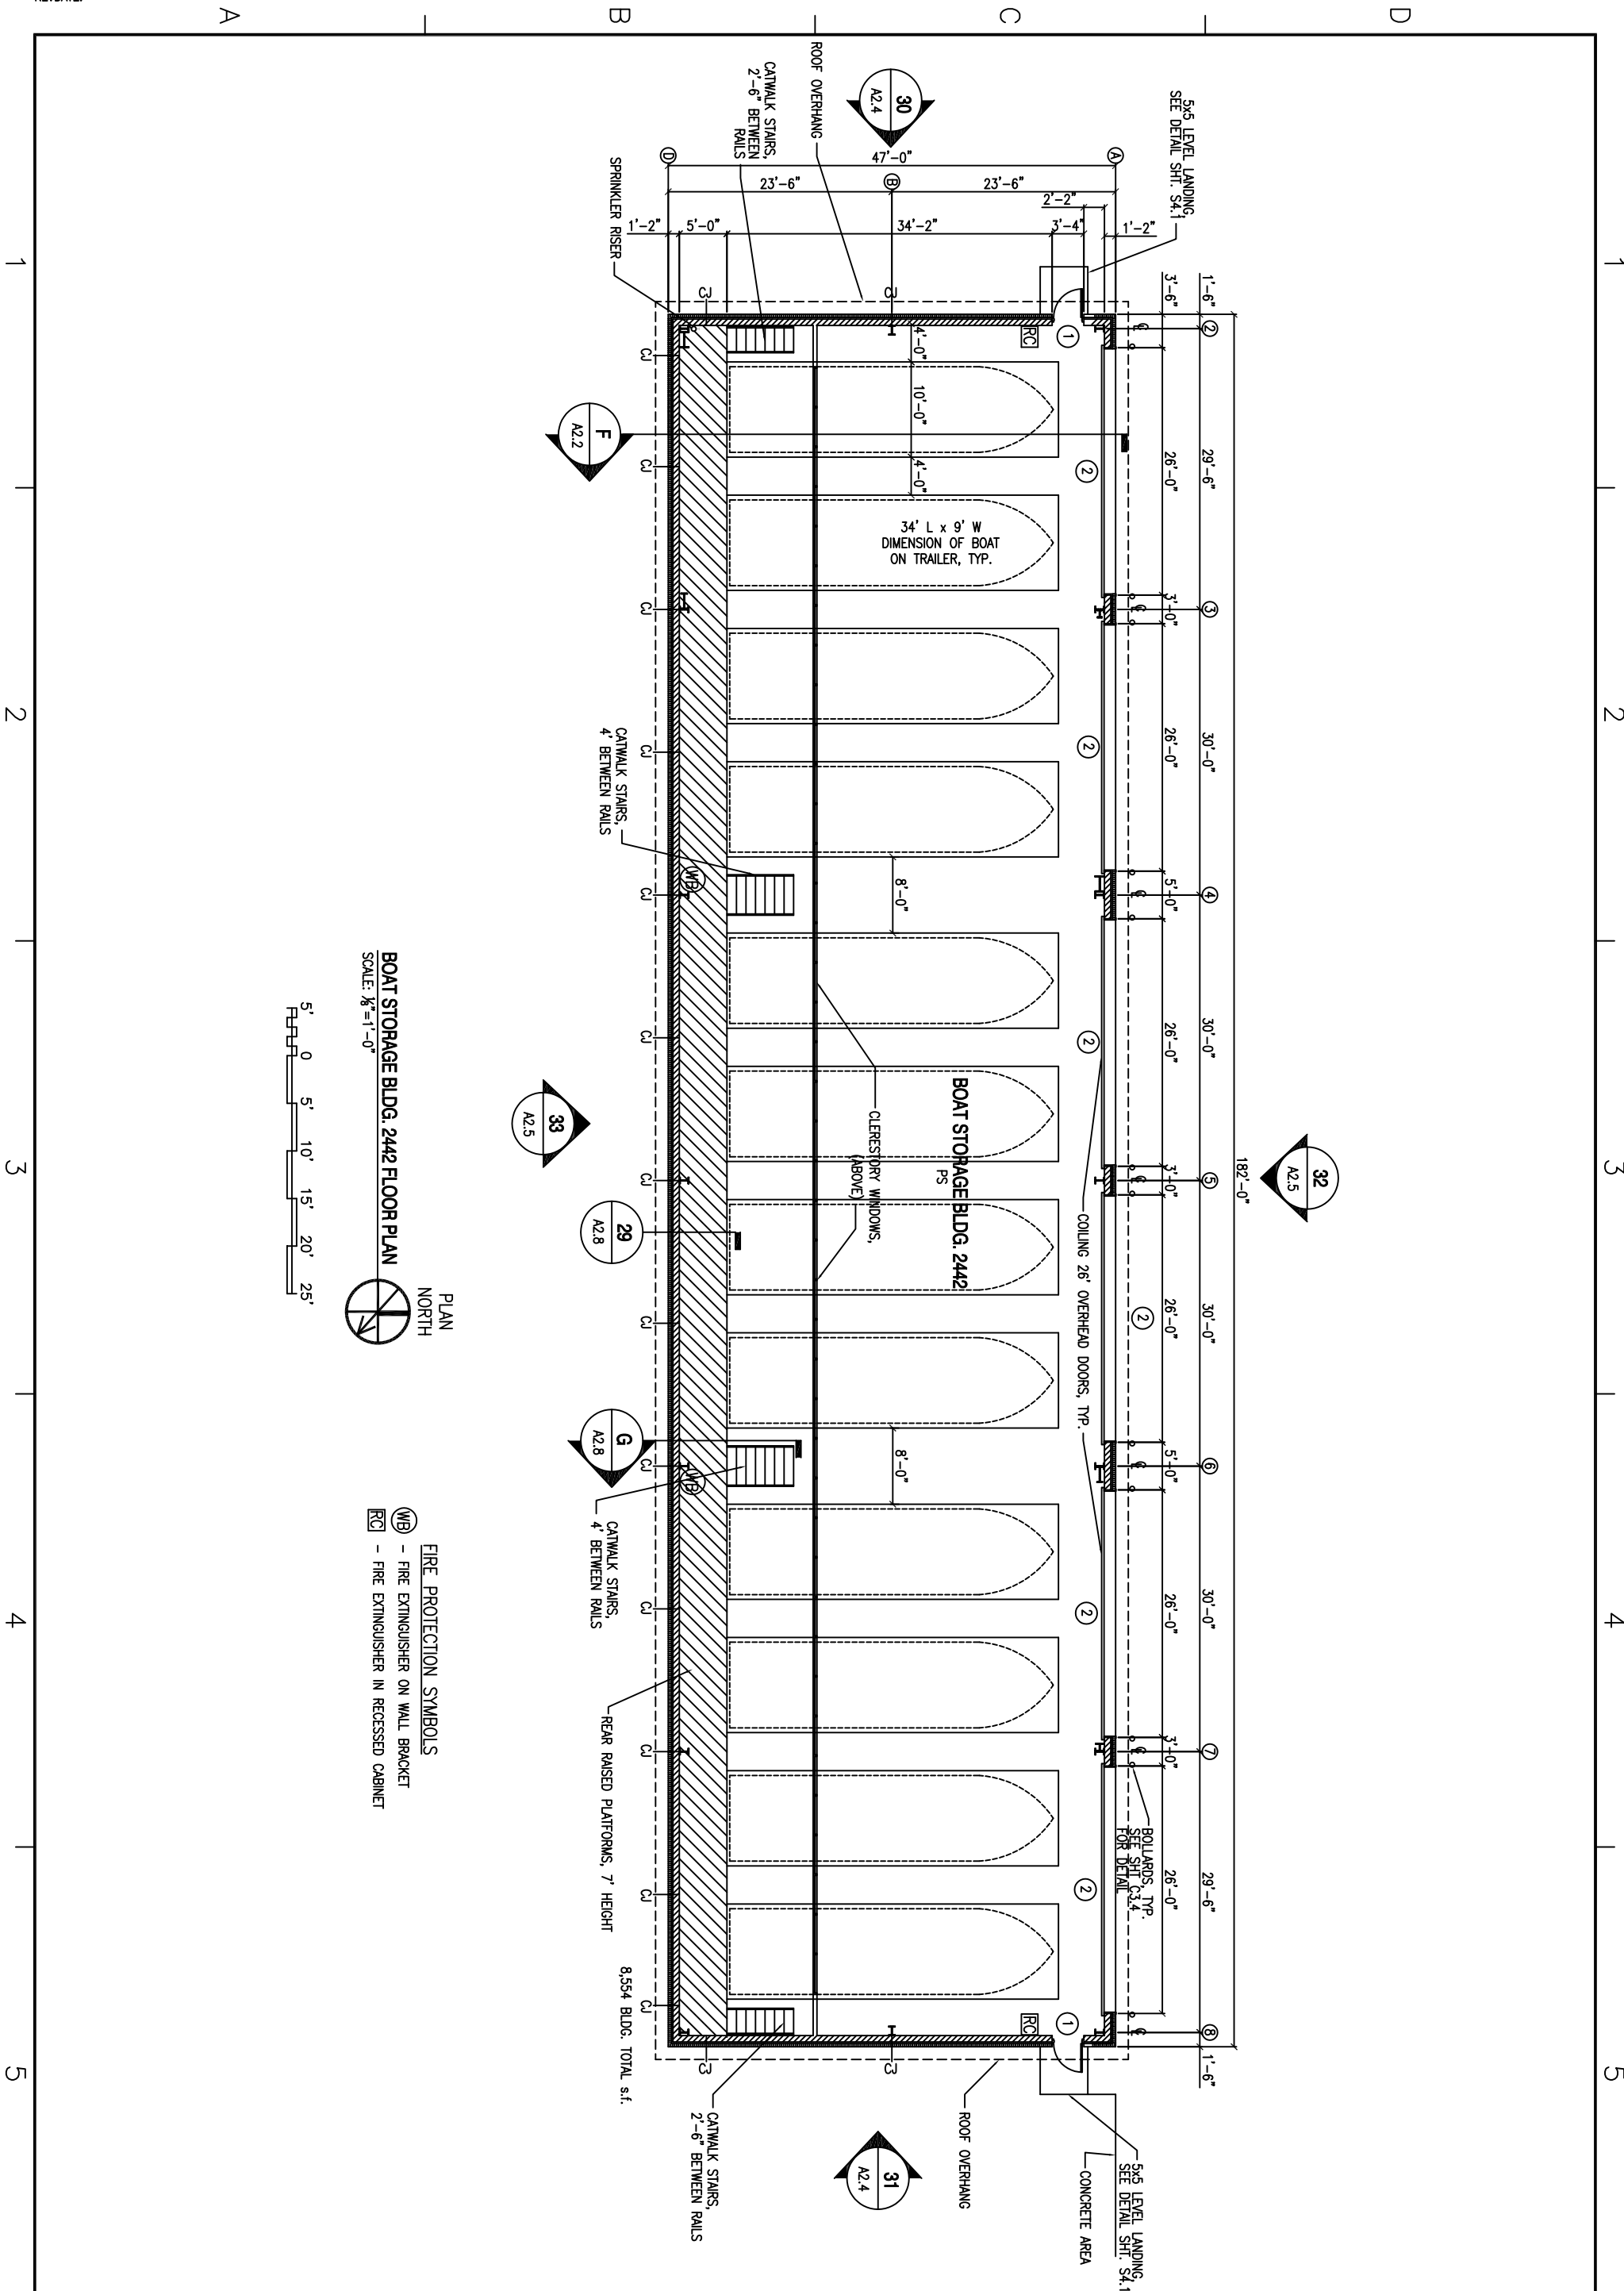

PLAN NORTH

BOAT STORAGE BLDG. 2442 FLOOR PLAN

SCALE: $\frac{1}{8}'' = 1'-0''$

FIRE PROTECTION SYMBOLS

(WB) - FIRE EXTINGUISHER ON WALL BRACKET

(RC) - FIRE EXTINGUISHER IN RECESSED CABINET

| | | | | | | |
|---|--|--|--|---|-------------|--------------------|
| <p>DEPARTMENT OF THE NAVY</p> <p>NAVAL FACILITIES ENGINEERING COMMAND</p> <p>NAVAL FACILITIES ENGINEERING COMMAND SOUTHEAST</p> <p>IPT SOUTH ATLANTIC</p> <p>NAVAL AIR STATION JACKSONVILLE</p> <p>MISSISSIPPI</p> <p>JOHN C. STENNIS SPACE CENTER</p> <p>SOF RIVERINE AND COMBATANT CRAFT OPERATIONS FACILITY - PRE-FINAL</p> <p>BOAT STORAGE BLDG. 2442 FLOOR PLAN</p> | <p>NAVFAC ENGINEERING INC.</p> <p>ENGINEER</p> <p>CHIEF ARCHITECT</p> <p>DAMON R. PE</p> <p>1098 FLORIDA AVENUE</p> <p>STUART, FL 34986</p> <p>(888) 646-6332</p> <p>REV. 10, 2009</p> | | <p>DES. R. WILTZ</p> <p>REVIEWED BY: R. WILTZ</p> <p>PA/DATE: T. AMORH</p> <p>CHIEF ENG./ARCH. R. DAMMON</p> | <p>CODE: 01, NO. 144112, SIZE: 0</p> <p>SCALE: AS SHOWN</p> <p>ISSUED NO. 111111</p> <p>SPL. PROJ. NO. P-210</p> <p>WORK ORDER NO. 510247</p> <p>CONTR. COMM. NO. NS2467-05-D-0096</p> <p>NAVFAC DRAWING NO. ###-1-1-###</p> <p>SHEET 54 OF 117</p> <p>A2.1</p> | <p>DATE</p> | <p>APPR</p> |
| | | | | | <p>SYN</p> | <p>DESCRIPTION</p> |