


KEY PLAN
NTS


SOUTHEAST
LOUISIANA
VETERANS
HEALTH CARE
SYSTEM
SUITE D

- LEGEND**
- ===== INSULATED WALLS
 - UNINSULATED WALLS
 - zzzzzzz EXISTING FIRE WALLS

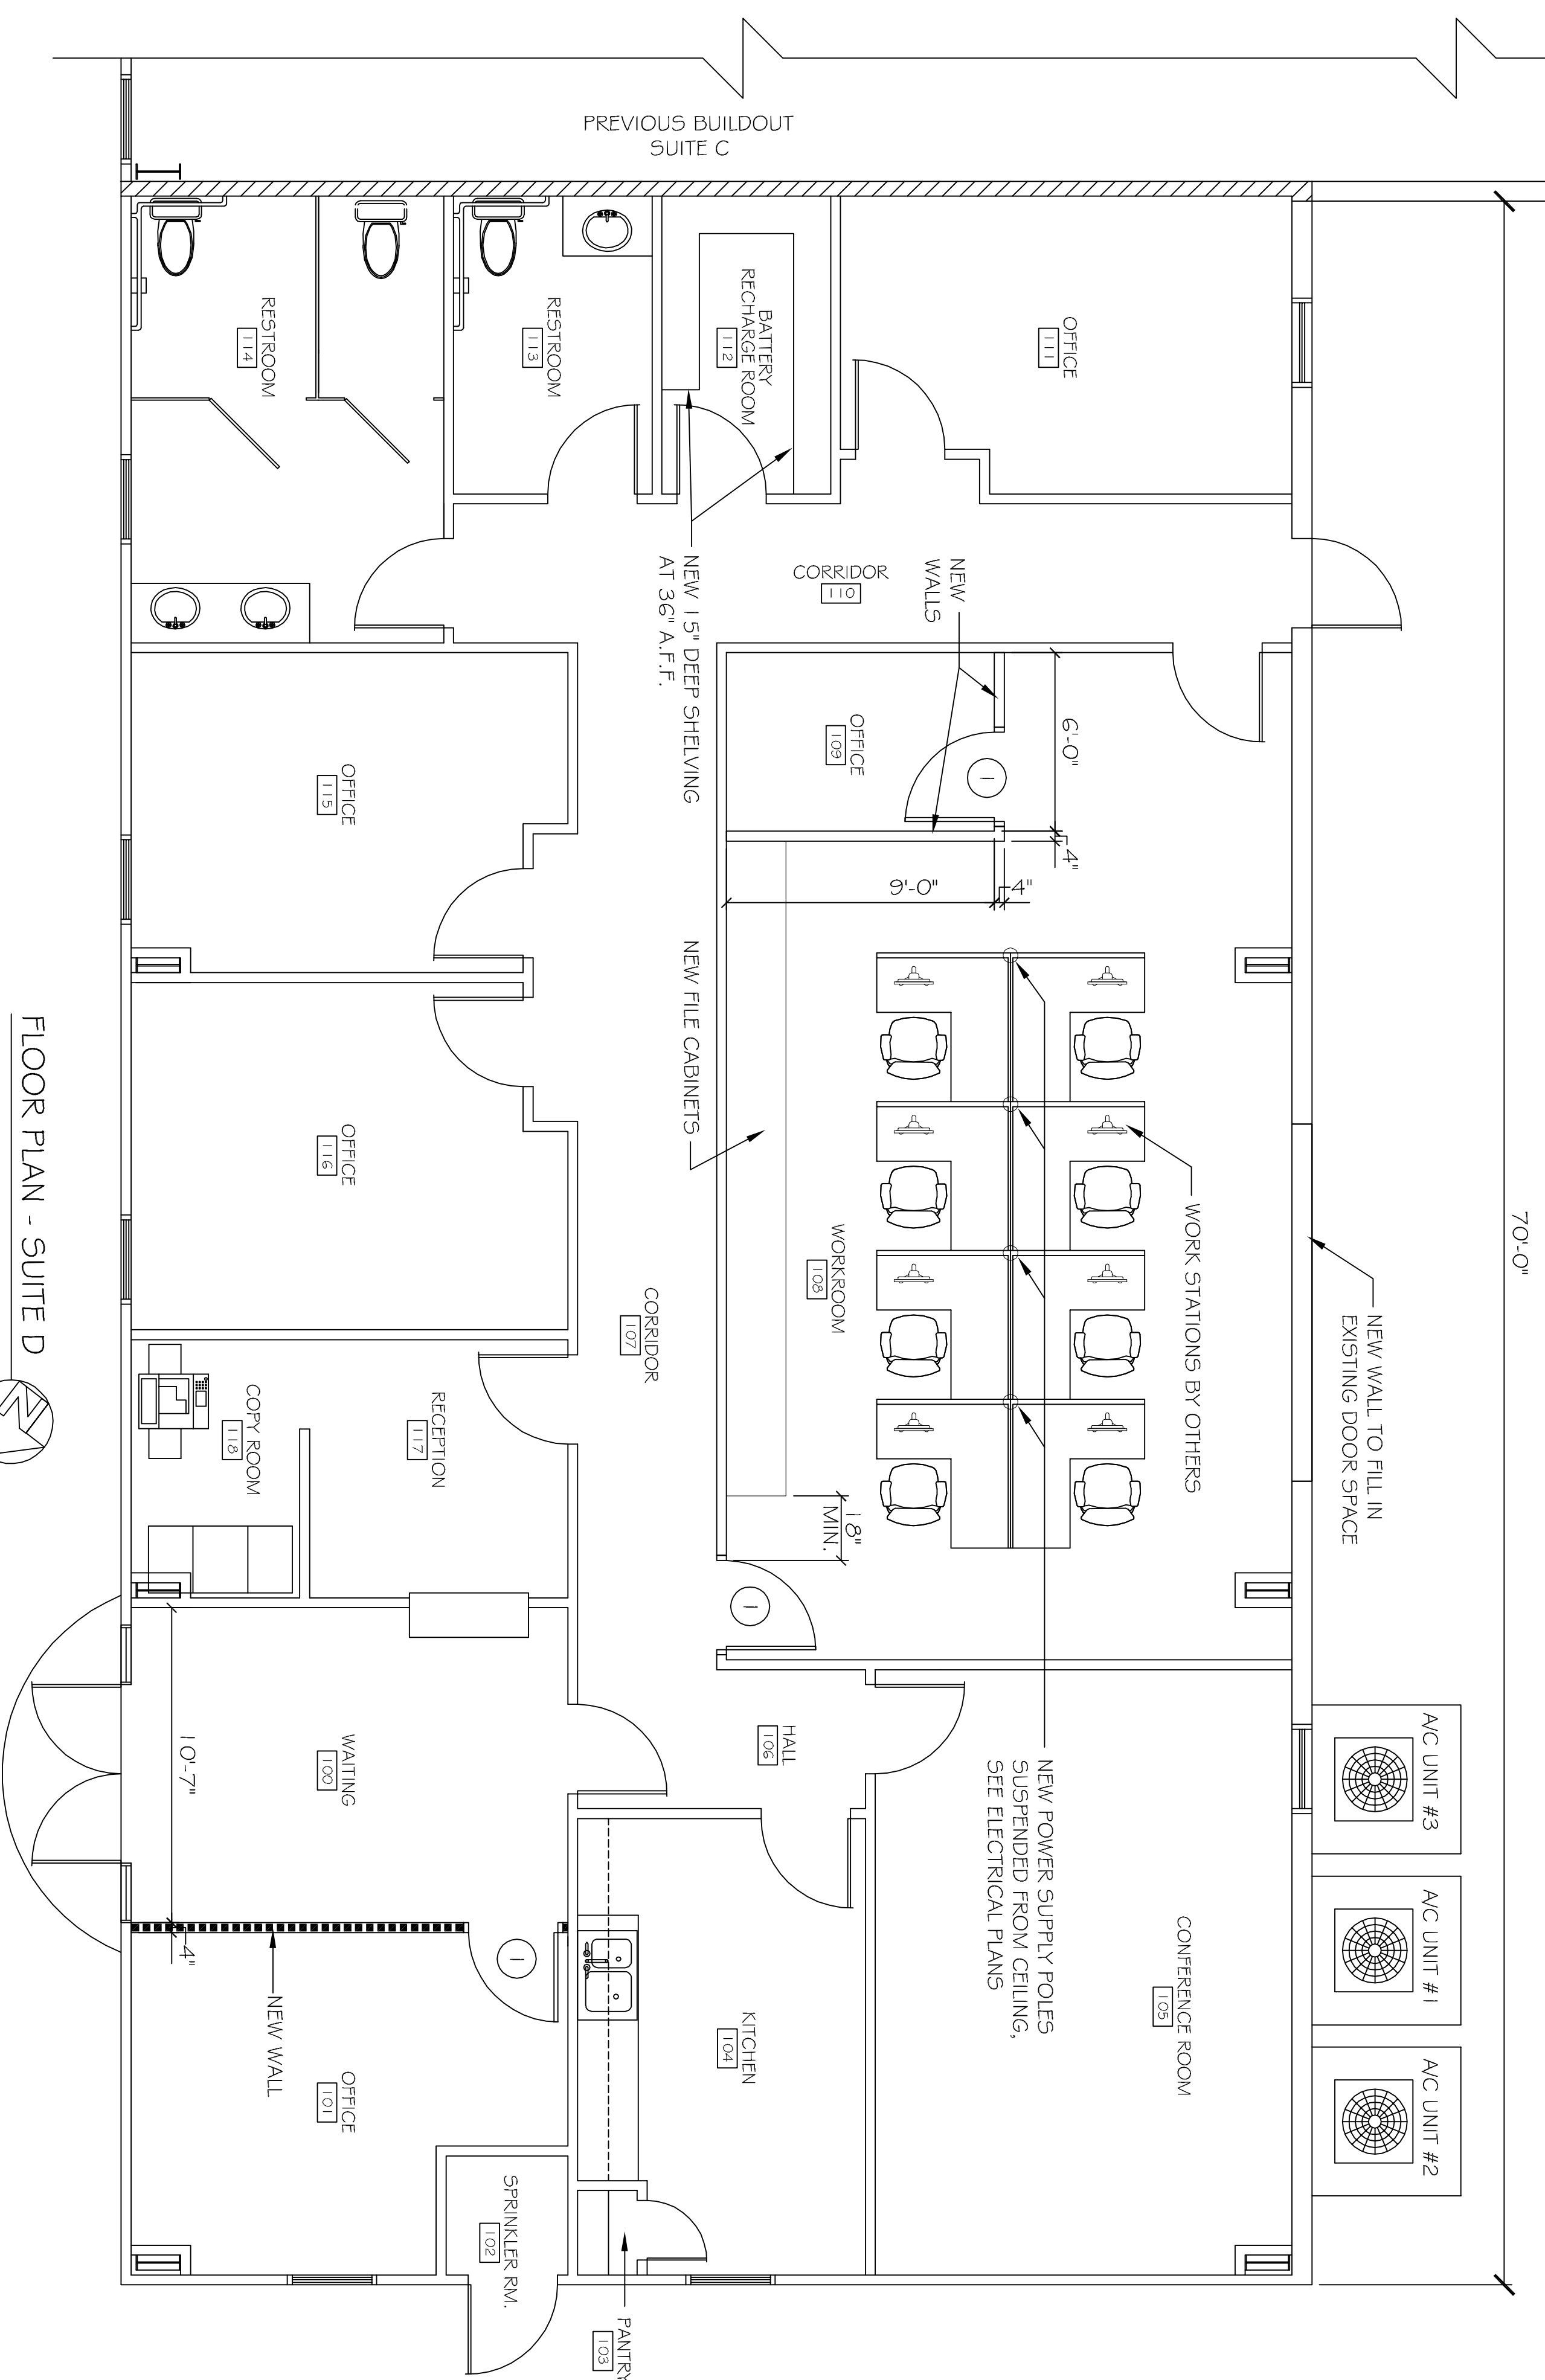

70'-0"

FLOOR PLAN - SUITE D
SCALE: 1/4" = 1'

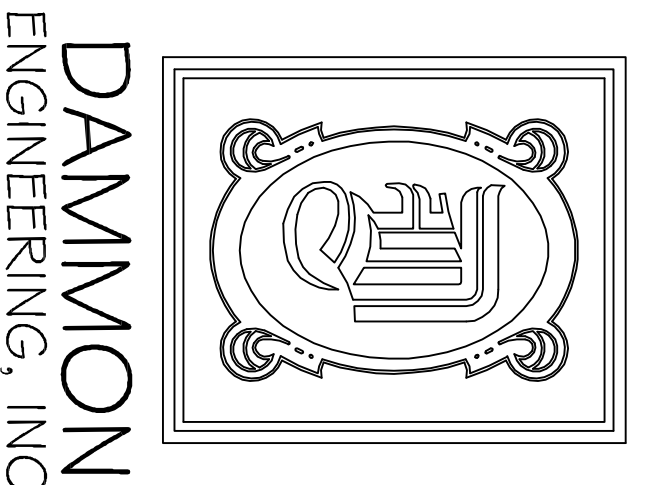

DAMMON
ENGINEERING, INC.
CHIEF ENGINEER
EMMETT
DAMMON, P.E.
CHIEF ARCHITECT
ROBERT
WILTSE

1095 FLORIDA AVENUE
SLIDELL, LA. 70458
OFFICE: 985-649-5632
FAX: 985-641-5950

WEBSITE:
WWW.DAMMONENGINEERING.COM
EMAIL:
DAMMONENGIN@BLSOUTH.NET

- ARCHITECTURE
- ENGINEERING
- STUDIES
- PLANNING
- INVESTIGATION
- EXPERT WITNESS

SOUTHEAST
LOUISIANA
VETERANS
HEALTH CARE
SYSTEM

SUITE D
FLOOR PLAN

REV:

SCALE: AS NOTED
JOB#: 2012
DATE: 03-11-09
SHEET 3