


FUTURE TENANT AREA NOT SHOWN

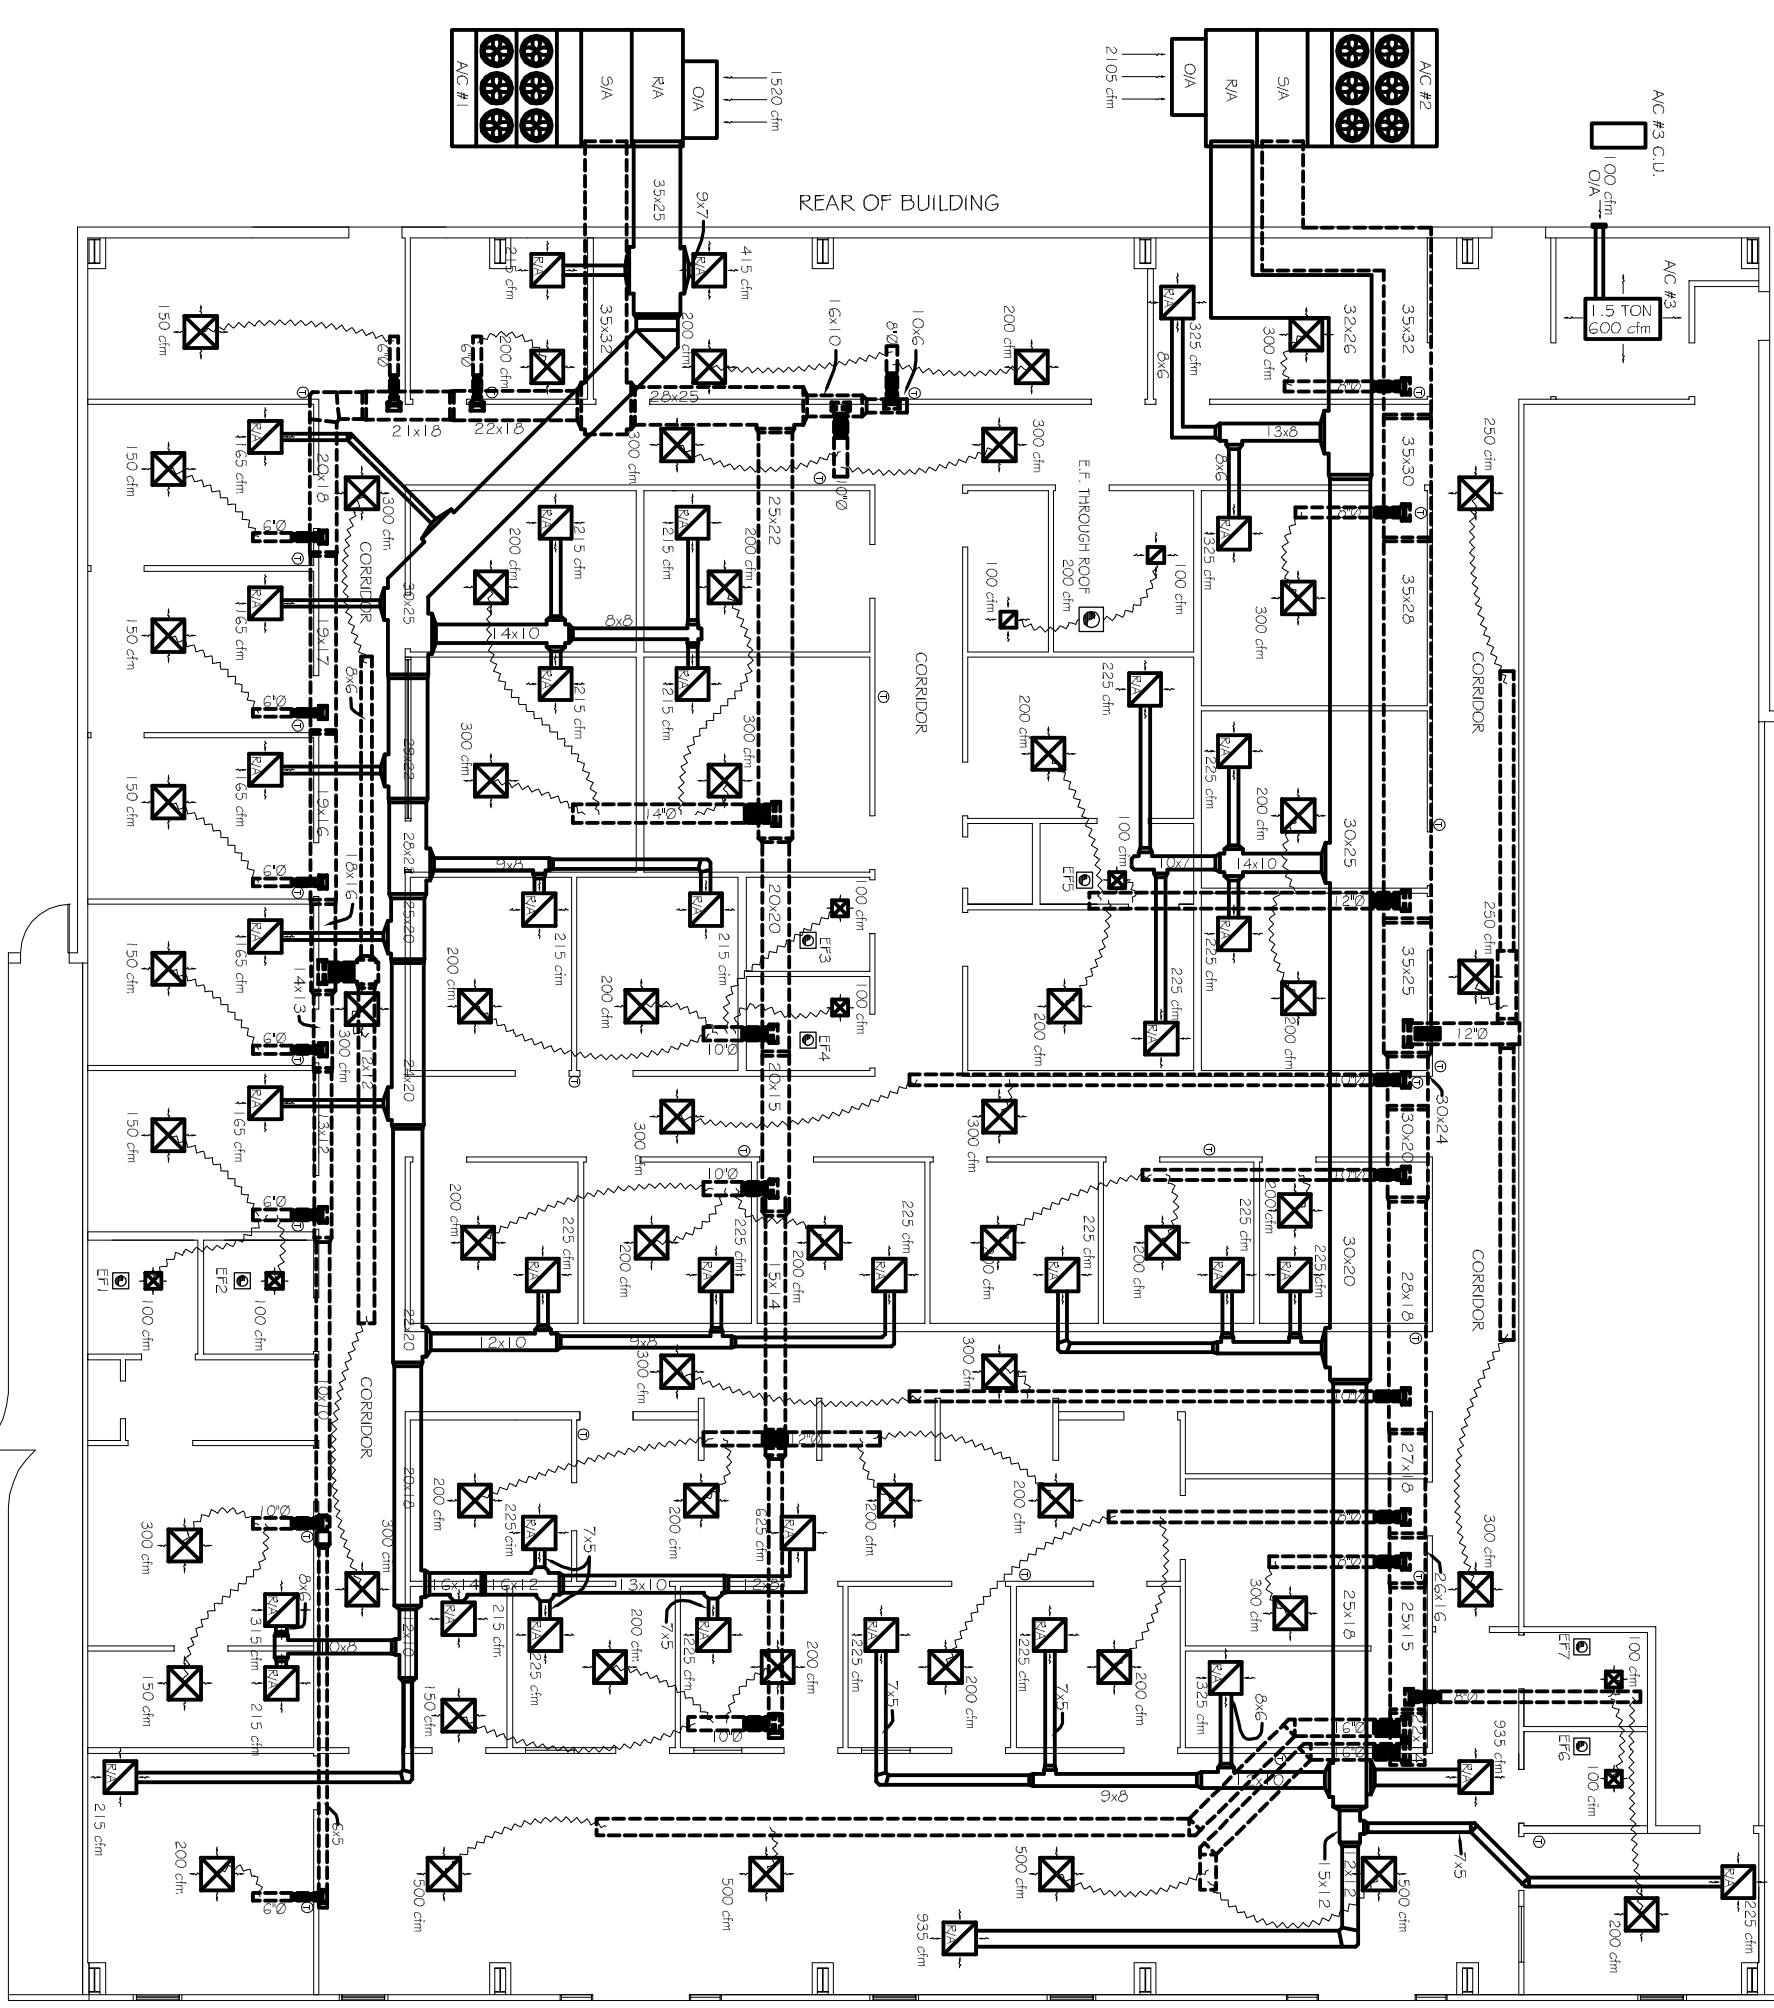

FRESH AIR REQUIREMENTS PER IMC 2003, TABLE 403.3

ROOM NUMBER	SQUARE FEET	OCCUPANTS	CFM O.A. / OCC.	TOTAL REQ. O.A. (cfm)
118	170	5	20	100
120	154	13	20	260
121	154	2	25	50
122	154	2	25	50
123	140	2	25	50
125	140	2	75cfm/W.C.	75
126	140	2	25	50
142	100	1	25	25
143	100	1	25	25
144	100	1	25	25
152	100	1	20	20
153	100	2	15	30
154	250	5	15	75
155			75cfm/W.C.	75
156			75cfm/W.C.	75
157	145	1	20	20
100	1160	70	15	1050
CORRIDOR				
			0.05 cfm/sq ft	50
AC#2 - 1.8 TON				
101	208	2	20	40
102	84		0.5 cfm/sq ft	40
103	173	5	20	100
106			75cfm/W.C.	75
107			75cfm/W.C.	75
109	140	2	25	50
110	140	1	25	25
111	140	1	20	20
112	140	1	20	20
113	140	1	20	20
116	110	1	20	20
117	345	17	20	340
130			75cfm/W.C.	75
131			75cfm/W.C.	75
132	186	2	25	50
133	140		0.15 cfm/sq ft	20
134	140	2	25	50
135	186	2	25	50
136	120	1	25	25
137	120	1	25	25
139	100	1	25	25
140	100	1	25	25
141	100	1	25	25
147	360	3	20	60
148	100		0.5 cfm/sq ft	20
149	60	1	20	20
150	100	1	20	20
151	100	1	20	20
CORRIDOR				
			0.05 cfm/sq ft	55

LEGEND


- RIGID RETURN AIR DUCT, SIZE AS SHOWN
- RIGID SUPPLY AIR DUCT, SIZE AS SHOWN
- FLEX SUPPLY AIR DUCT, MAX LENGTH 14'
- 100 cfm - 5"
- 150 cfm - 6"
- 200 cfm - 8"
- 250 cfm - 9"
- 300 cfm - 10"
- 500 cfm - 12"
- 24"x24" DIFFUSER
- RETURN AIR GRILLE, SIZE AS NEEDED
- ROUND DAMPERS WITH VLT VARIABLE VOLUME AND TEMPERATURES SIZE AS SHOWN. VERIFY SIZE WITH MANUFACTURER'S RECOMMENDATIONS
- THERMOSTAT: VERIFY LOCATION WITH OWNER
- 80 cfm EXHAUST FAN THROUGH ROOF

AC UNIT SCHEDULE

NO.	TOTAL BTU	CHW	O.A.	HEAT (KW)	ELECTRICAL (KW)	COMMENTS
1	216,000	7200	1560	40	230V/3Ø	CARRIER 5090Q20
2	216,000	7200	2105	40	230V/3Ø	CARRIER 5090Q20
3	18,000	600	100	5	230V/1Ø	MAD 10E-PHOC

MECHANICAL PLAN-SUITE B
SCALE: 1/8" = 1'-0"

EXISTING TENANT AREA NOT SHOWN

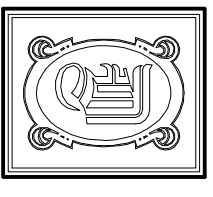

DAMMON ENGINEERING, INC.
 CHIEF ENGINEER
 ENNETT DAMMON, P.E.
 CHIEF ARCHITECT
 ROBERT WILTSE

1095 FLORIDA AVENUE
 SUITE 111, 70458
 OFFICE: 985-649-5632
 FAX: 985-641-5950
 WEBSITE: WWW.DAMMONENGINEERING.COM
 EMAIL: DAMMONENG@BELL-SOUTH.NET

ARCHITECTURE
 ENGINEERING
 STUDIES
 PLANNING
 INVESTIGATION
 EXPERT WITNESS

SOUTHEAST LOUISIANA VETERANS HEALTH CARE SYSTEM

SUITE B MECHANICAL PLAN

REV:

SCALE: AS NOTED

JOB#: 2009

DATE: 02-03-09

SHEET 9

M-1

OF 14