


↳ RETURN AIR OR EXHAUST DUCT

▭ - FLOW CONTROL DAMPER (FCV)

Ⓢ - A/C SMOKE DETECTOR

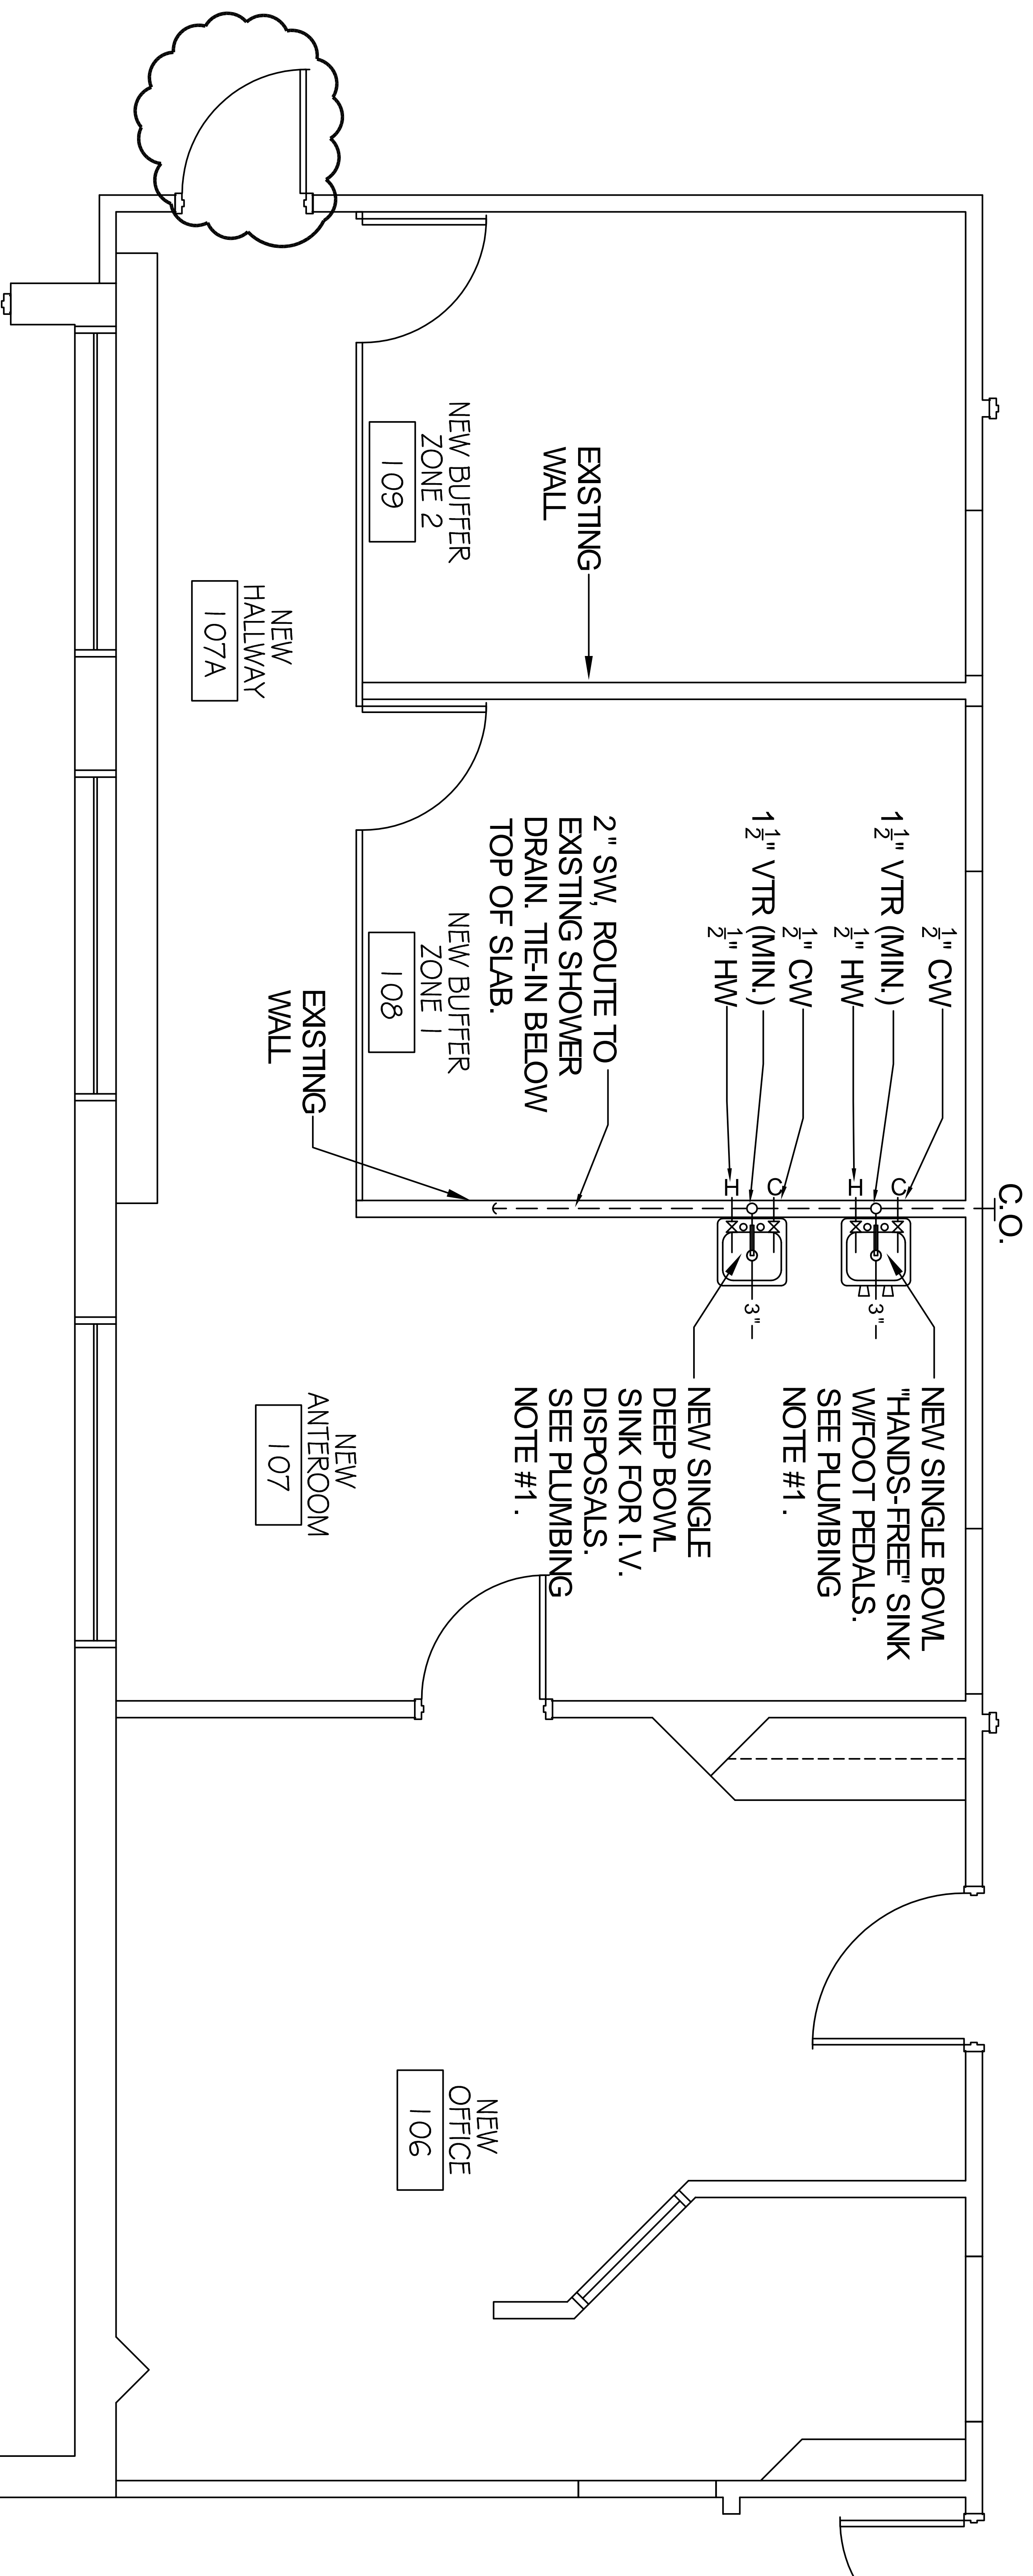

NEW PLUMBING PLAN

SCALE: 1/4" = 1'

