
 
 
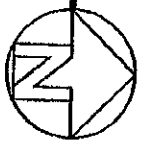


MECHANICAL LEGEND

 - SUPPLY AIR GRILLE
 - RETURN AIR GRILLE
 - THERMOSTAT

NEW MECHANICAL PLAN

SCALE: 1/4" = 1'




Supply Air To Rooms

Coil

APS
210 CFM
EXFILTRATION

CURBS PLUS INC. INSULATED
 1/2" OPC ROOF CURBS W/ FULLY
 WELDED CONSTRUCTION
 AND TREATED WOOD NAILER
 CURBS PLUS INC. 1/2" OPC
 EQUIPMENT SUPPORT W/
 FULLY WELDED CONSTRUCTION
 AND TREATED WOOD NAILER (TYP)

CURBS PLUS INC. INSULATED
 1/2" OPC ROOF CURBS W/ FULLY
 WELDED CONSTRUCTION
 AND TREATED WOOD NAILER

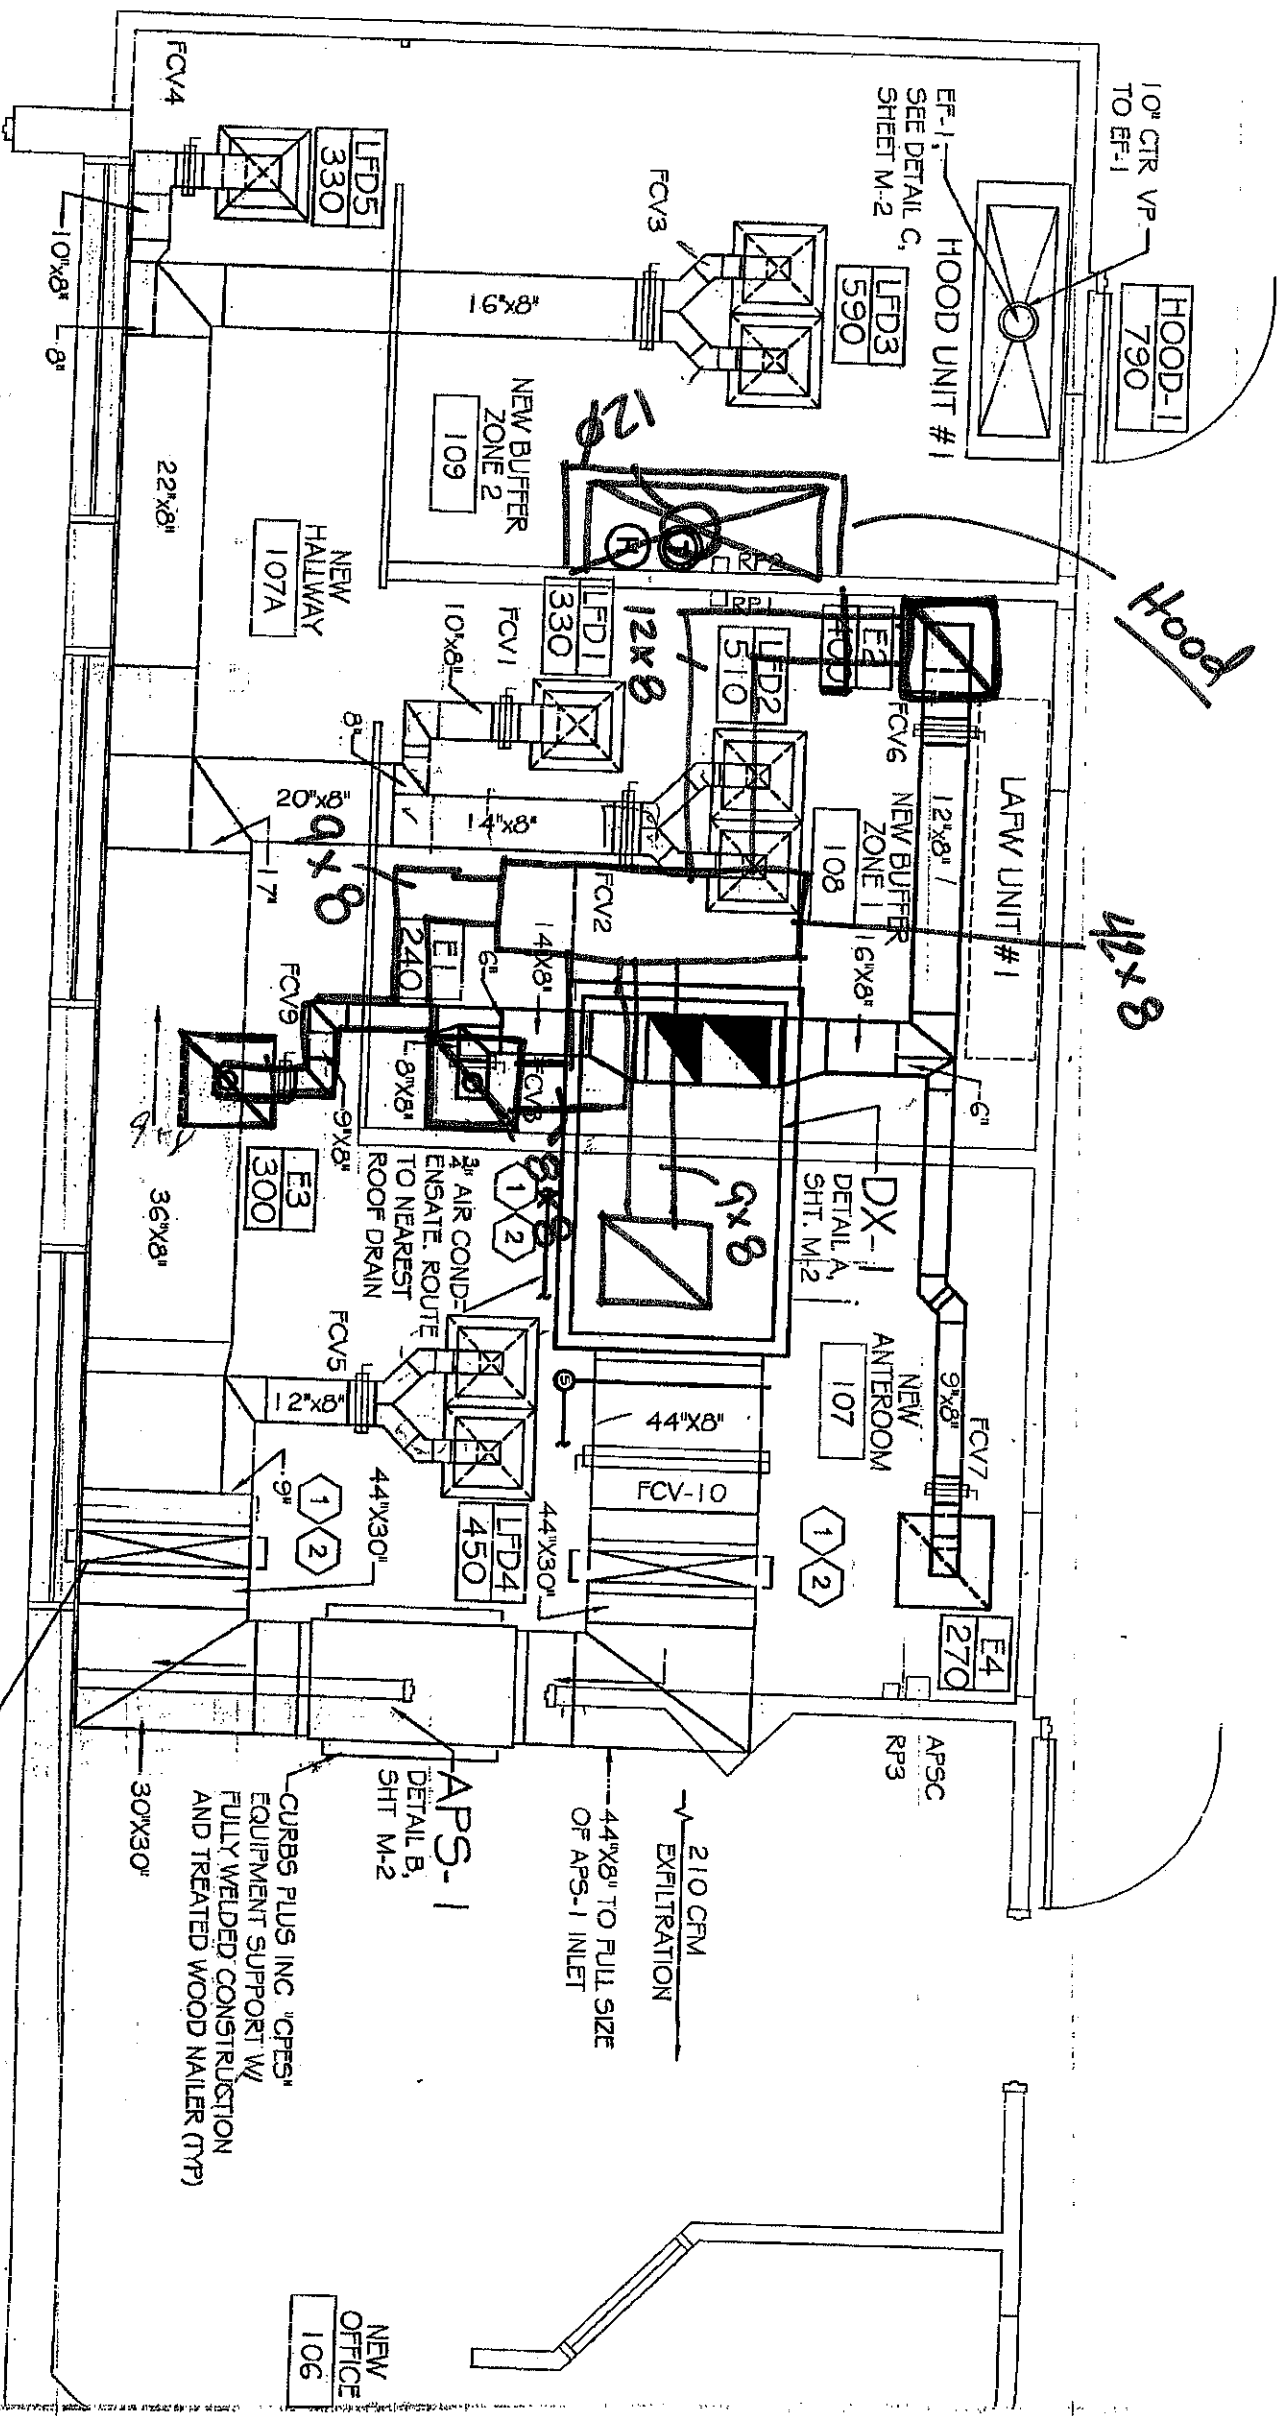

MECHANICAL LEGEND

☒ - SUPPLY AIR GRILLE

☐ - RETURN AIR GRILLE

⊕ - THERMOSTAT

NEW MECHANICAL PLAN
SCALE: 1/4"=1'

