

**OUTSIDE AIR**

**DINER**


<b>EXHAUST</b>	
KITCHEN HOOD	-5,250 CFM
TOILET EXHAUST	-150 CFM
<b>TOTAL</b>	<b>-5,400 CFM</b>
<b>SUPPLY</b>	
KITCHEN MAKE-UP	+4,200 CFM
RTU OUTSIDE	+1,824 CFM
RTU OUTSIDE	+100 CFM
<b>TOTAL</b>	<b>+6,124 CFM</b>
<b>NET POSITIVE</b>	<b>+724</b>

**RESTURANT**

<b>EXHAUST</b>	
KITCHEN HOOD	-2,646 CFM
TOILET EXHAUST	-150 CFM
<b>TOTAL</b>	<b>-2,796 CFM</b>
<b>SUPPLY</b>	
KITCHEN MAKE-UP	+2,117 CFM
RTU OUTSIDE	+720 CFM
RTU OUTSIDE	+100 CFM
RTU OUTSIDE	+1,748 CFM
<b>TOTAL</b>	<b>+4,415 CFM</b>
<b>NET POSITIVE</b>	<b>+1,619</b>

Project Number: 04012

This drawing is the property of ROZAS-WARD & a.i.a. architects, and is not to be reproduced or copied in whole or in part. It is only to be used for the project and site specifically identified herein.  
 Scales as noted herein are valid on the original drawing only.

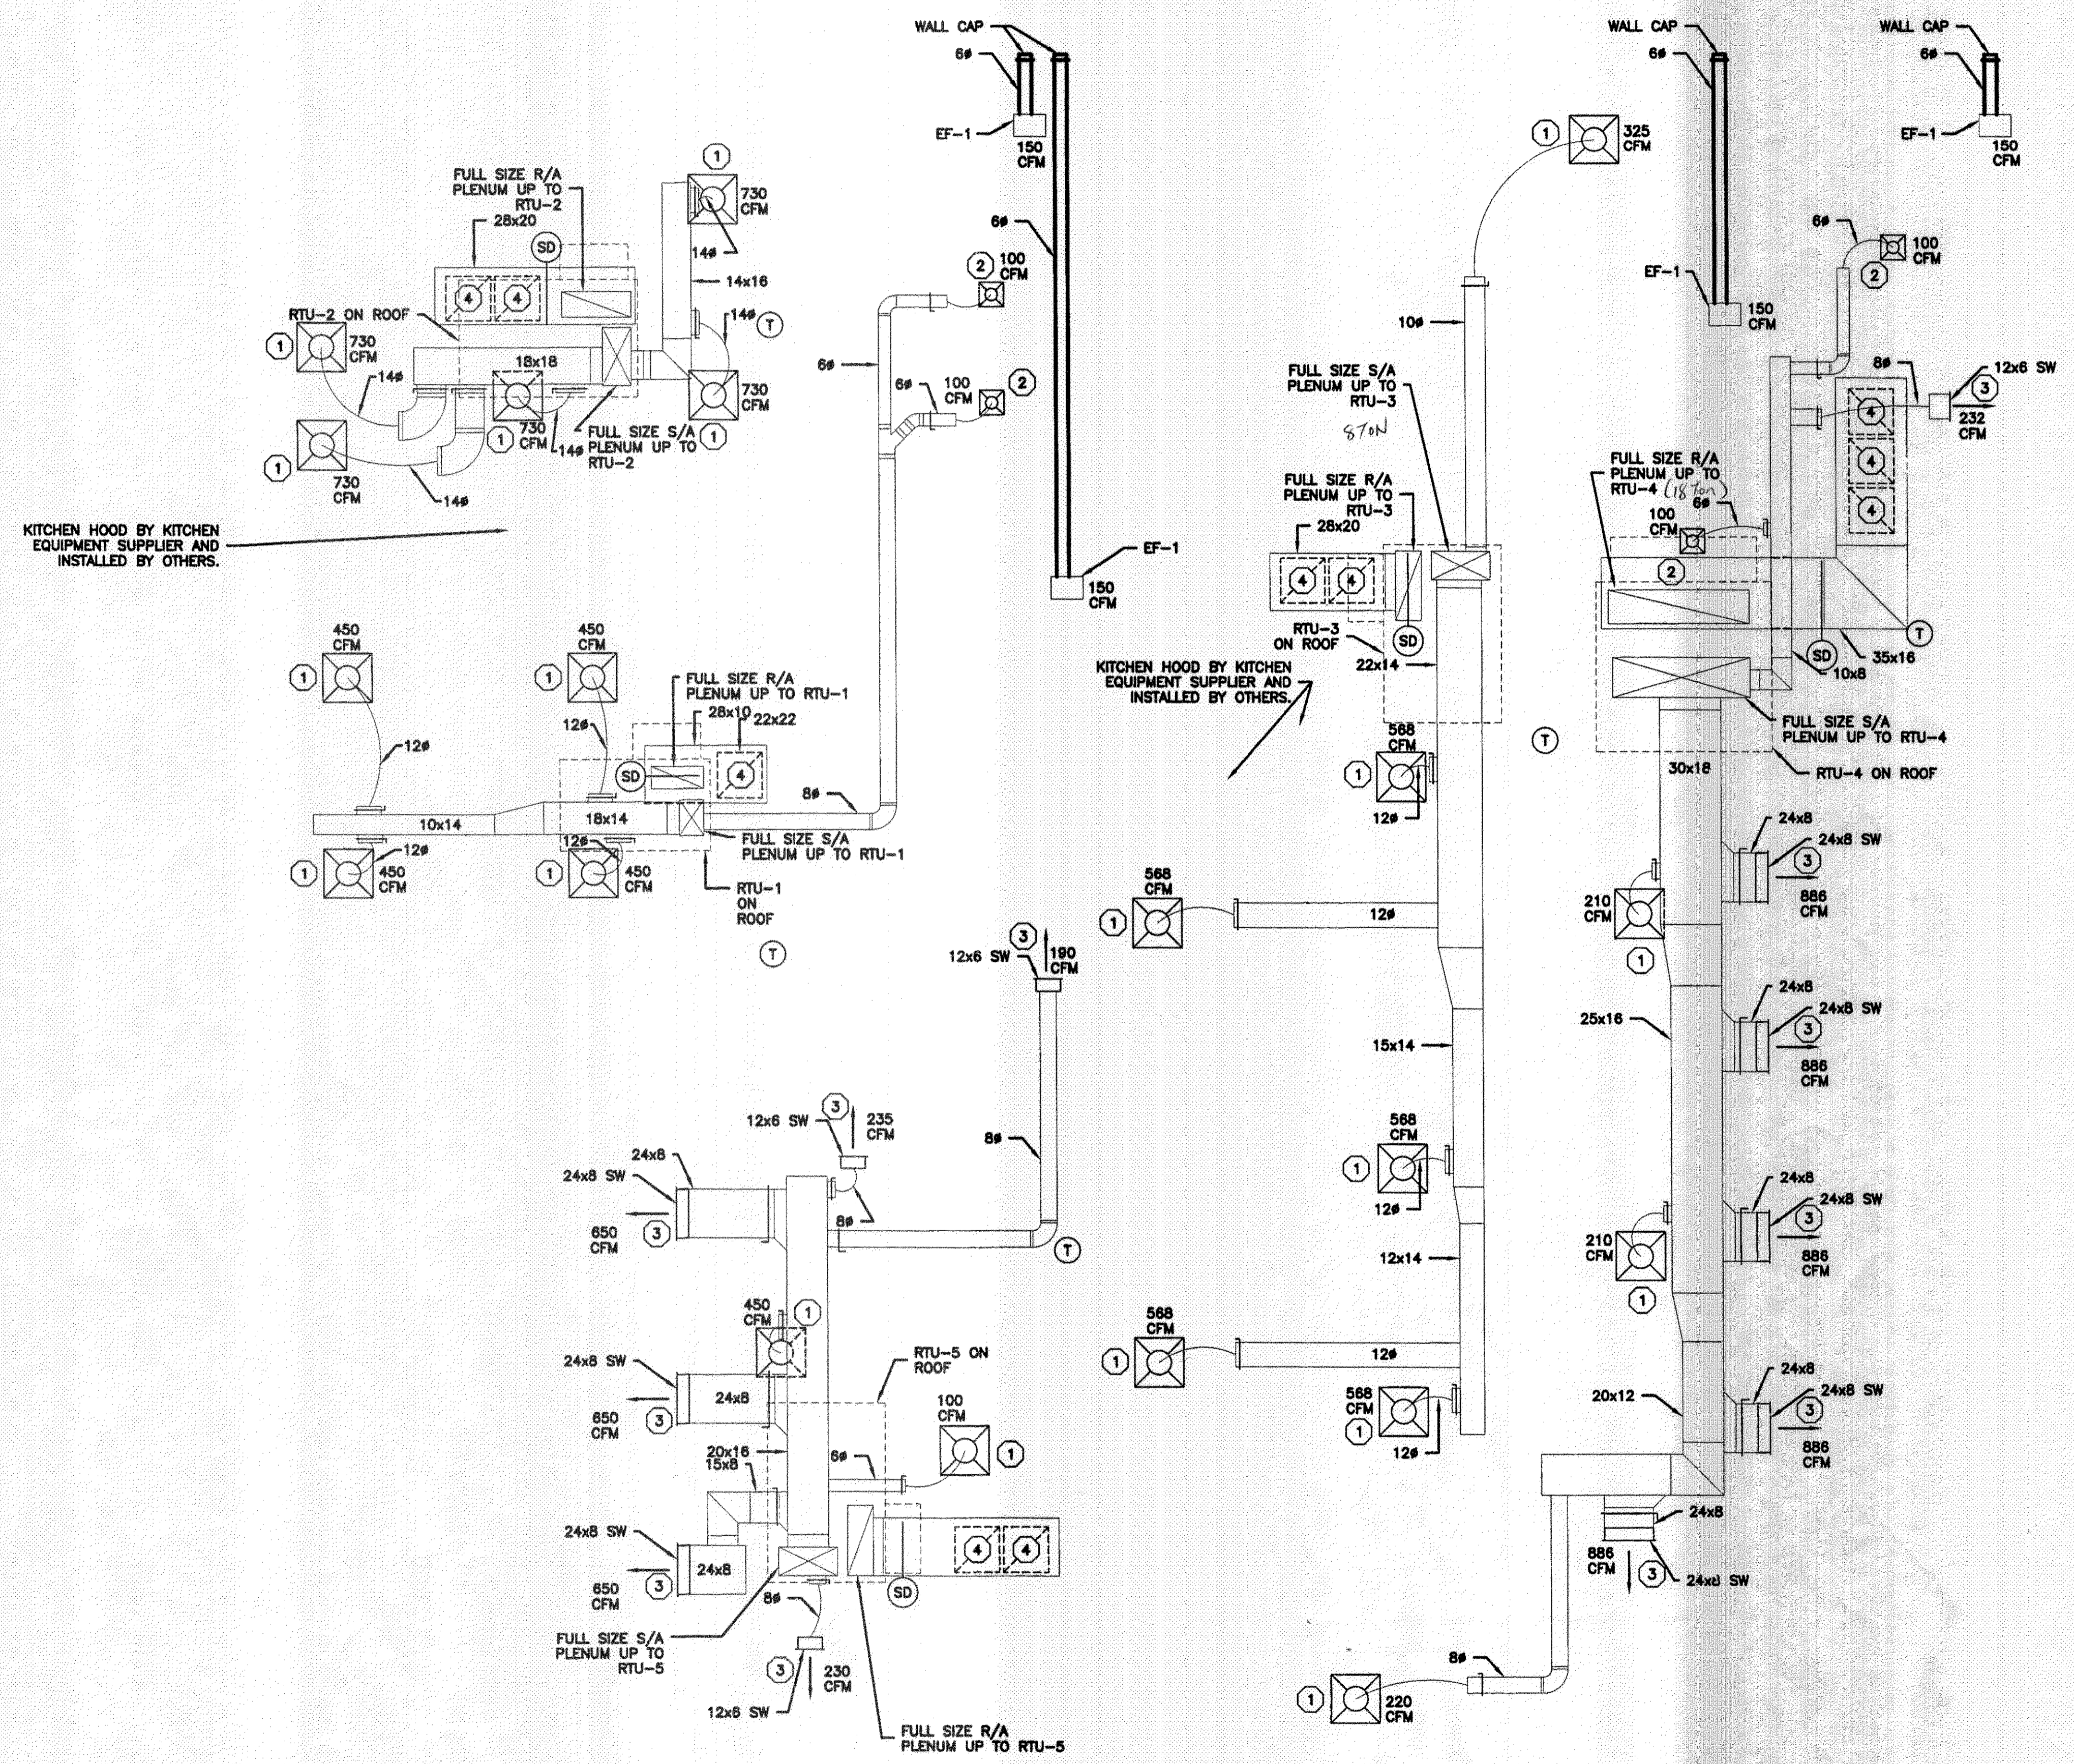

1 HVAC FLOOR PLAN  
 SCALE: 1/4" = 1'-0"

**AIRCONTROL SERVICE, INC.**  
 1354 CARROLL ST. SUITE A  
 KENNER, LA 70062-5347  
 467-6800 FAX 467-6822

**ROZAS-WARD / a.i.a. architects**  
 a professional corporation  
 1010 Common Street, Suite 2750, New Orleans, Louisiana 70112 • (504) 524-4375

**RESTAURANT AND DINER**  
**JUDGE PEREZ @ JEAN LAFITTE PKWY**  
**CHALMETTE, LA**

**M2**  
 drawing: HVAC PLAN  
 set no.