



01 DIMENSION FLOOR PLAN

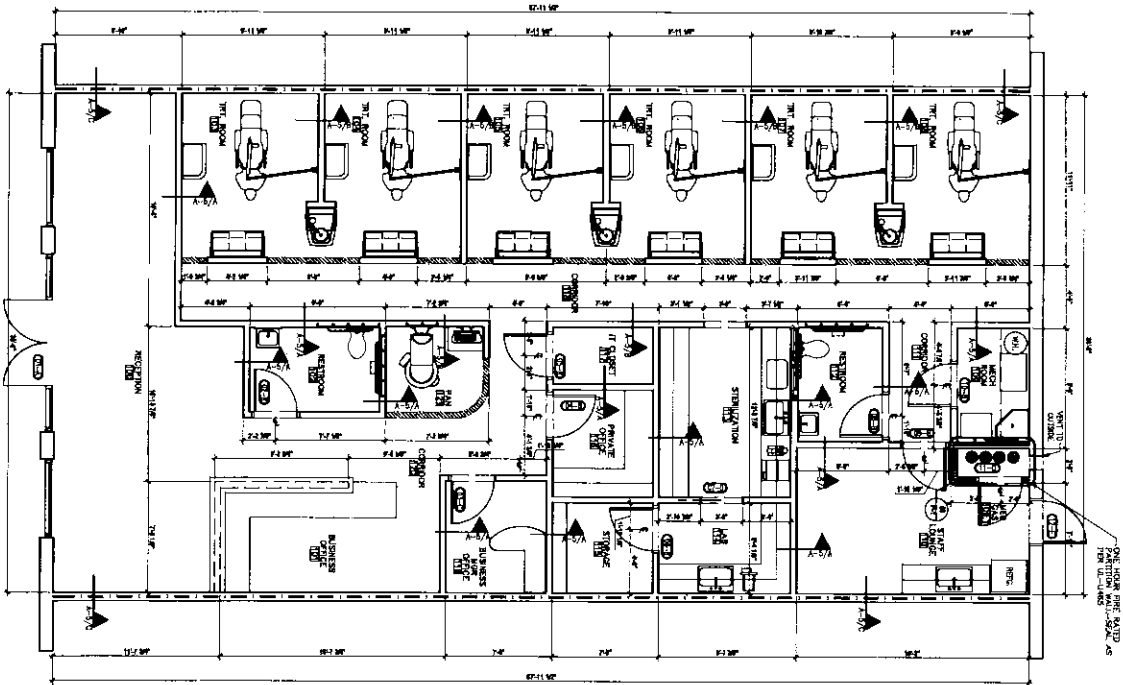

ONE HOUR FIRE RATED FROM THIS WALL AS SHOWN

02 TYPICAL WALL BACKING DETAIL

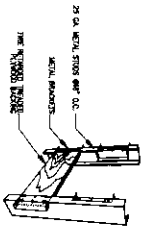

2x4 WOOD STUD @ 16" O.C.

METAL ANCHORS

1/2" GYPSUM BOARD

WALL LEGEND	
	EXISTING EXTERIOR WALL
	1-HOUR FIRE RATED DEMISING WALL
	PARTITION WALL
	NEW 1-HR FIRE RATED PARTITION WALL
	WALL BLOOMING - RE-A-1/02
	HEADER - 7'-0" A.F.F.


NOTE: EXISTING CEILING SHALL BE REFINISHED TO MATCH THE NEW CEILING. ALL NEW WALLS SHALL BE FINISHED TO MATCH THE EXISTING FINISH. ALL NEW WALLS SHALL BE FINISHED TO MATCH THE EXISTING FINISH. ALL NEW WALLS SHALL BE FINISHED TO MATCH THE EXISTING FINISH.

NOTE: SEE SHEET R-4 FOR CEILING HEIGHTS


	MINT DENTISTRY - TERRELL 250 America Way, Suite 200 TERRELL, TEXAS 75146	REVISIONS:	DENTAL CONSTRUCTION SPECIALIST 8664 N. CENTRAL EXPY, SUITE 406 DALLAS, TEXAS PHONE: 214-796-8888 FAX: 214-272-8918 www.MINTdentistry.com		
	DATE: 08/11/02 DRAWN BY: [blank] CHECKED BY: [blank] SCALE: 1/4" = 1'-0"	SHEET TITLE: DIMENSION FLOOR PLAN			

01 FINISH FLOOR PLAN

SCALE

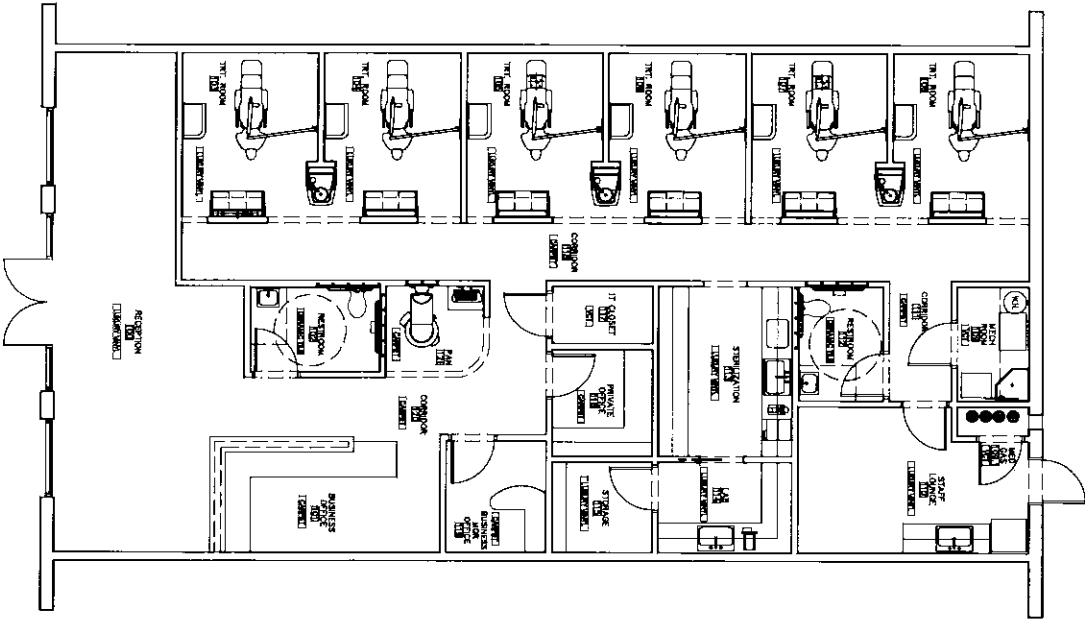

	DATE: 08/08/10 DRAWN BY: J. J. J. CHECKED BY: J. J. J. SCALE: 1/8" = 1'-0"	MINT DENTISTRY - TERRELL 800 America Way, Suite 200 TERRELL, TEXAS 75119	DENTAL CONSTRUCTION SPECIALIST 6866 N. CENTRAL EXPY, SUITE 400 DALLAS, TEXAS PHONE: 214-736-8888 FAX: 214-272-8818 www.MINTdentistry.com		
	SHEET TITLE: FINISH FLOOR PLAN	SHEET NO.: A-3			

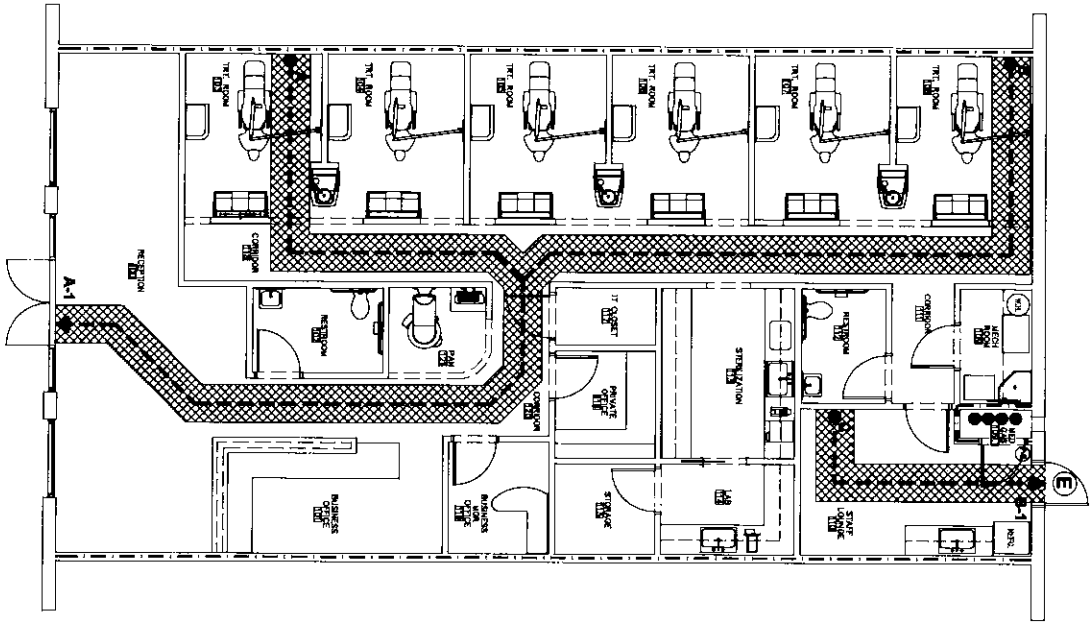

01 LIFE SAFETY PLAN





TRAVEL DISTANCE	
TRAVEL DISTANCE FROM POINT A TO A-1-B-2-C-2	TRAVEL DISTANCE FROM POINT B TO B-1-B-2-C-2
TRAVEL DISTANCE FROM POINT A TO A-1-B-2-C-2	TRAVEL DISTANCE FROM POINT B TO B-1-B-2-C-2






LIFE SAFETY LEGEND	
	ONE FROM FIRE WALL
	TRAVEL DISTANCE
	TRAVEL PLAN
	EXIT
	FIRE EXTINGUISHER

	<p>MINT DENTISTRY - TERRELL 606 America Way suite 200 TERRELL, TEXAS 75148</p>	<p>REVISIONS:</p>	<p>DENTAL CONSTRUCTION SPECIALIST 5664 N. CENTRAL EXPY., SUITE 400 DALLAS, TEXAS PHONE: 214-726-4868 FAX: 214-272-8816 www.MINTdentistry.com</p>
<p>DATE: 10/10/11 DRAWN BY: [Name] CHECKED BY: [Name] SCALE: 1/8" = 1'-0"</p>	<p>SHEET TITLE: LIFE SAFETY PLAN</p>		


PARTITION TYPES

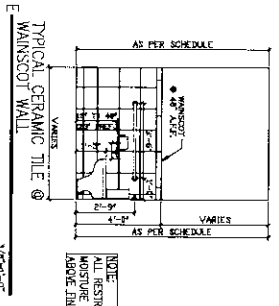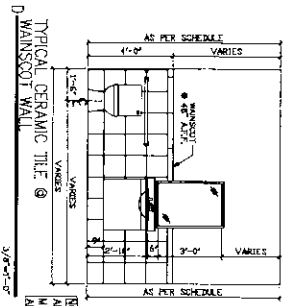


MOUNTING HEIGHTS

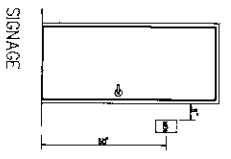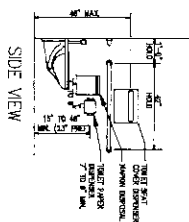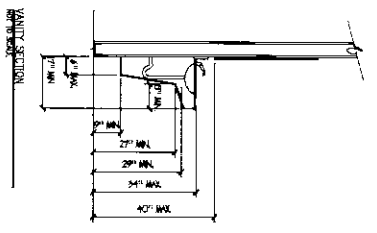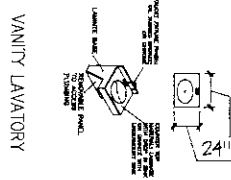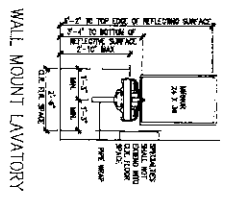


DOOR INSTALLATION GUIDELINES

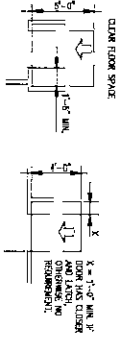

FORWARD APPROACH

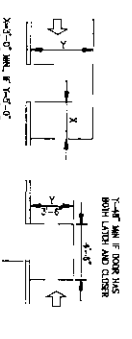

SIDE APPROACH - HINGE

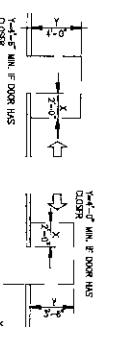


SIDE APPROACH - LATCH



	MINT DENTISTRY - TERRELL 606 America Way Suite 200 TERRELL, TEXAS 78168	DENTAL CONSTRUCTION SPECIALIST 6666 N. CENTRAL EXPY, SUITE 406 DALLAS, TEXAS PHONE: 214-776-4888 FAX: 214-772-8815 www.MINTdentistry.com
	SHEET TITLE: PARTITION WALL TYPES AND DETAILS	SHEET: 1 OF 1

01 MECHANICAL PLAN

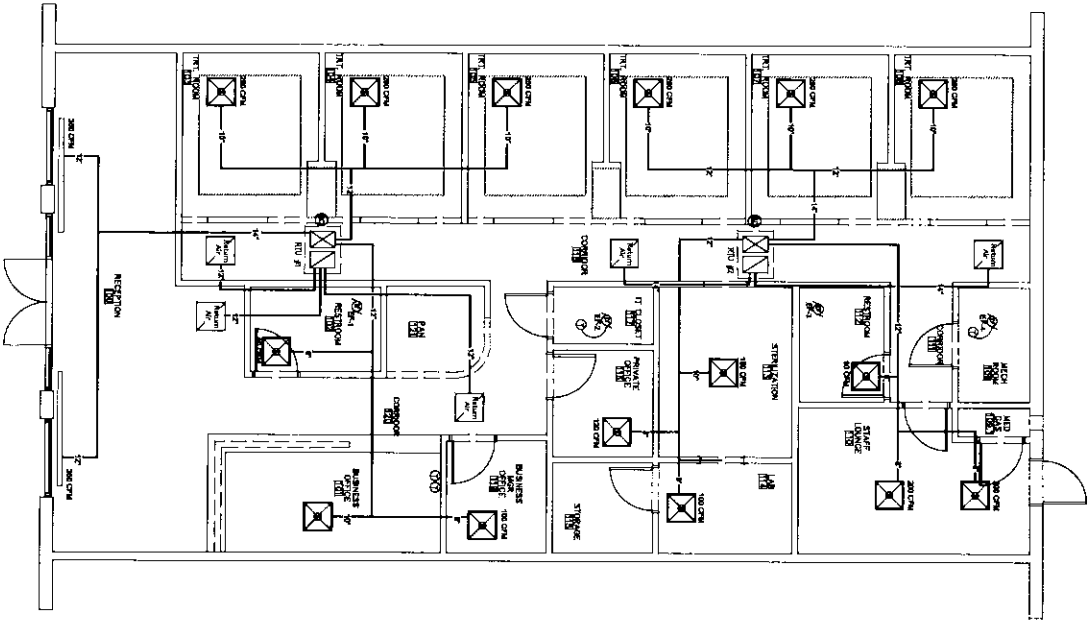


R.T.U. AND EXHAUST FANS INFORMATION

SYMBOL LEGEND


	ZONE SUPPLY AIR CIRCUIT
	ZONE RETURN AIR INTAKE
	EXHAUST FAN
	EXHAUST FAN RETURN TO OUTSIDE
	E-SW
	EXHAUST FAN TEST LIGHT

SEE ELECTRICAL PLAN FOR R.T.U. AND EXHAUST FAN SCHEDULES AND WIRING. SEE MECHANICAL PLAN FOR DUCTWORK AND EXHAUST FAN LOCATIONS. SEE MECHANICAL PLAN FOR EXHAUST FAN TEST LIGHT LOCATIONS. SEE MECHANICAL PLAN FOR EXHAUST FAN RETURN TO OUTSIDE LOCATIONS. SEE MECHANICAL PLAN FOR EXHAUST FAN E-SW LOCATIONS. SEE MECHANICAL PLAN FOR EXHAUST FAN TEST LIGHT LOCATIONS.


	MINT DENTISTRY - TERRELL 606 America Way suite 200 TERRELL, TEXAS 75169	DENTAL CONSTRUCTION SPECIALIST 6864 N. CENTRAL EXPY., SUITE 406 DALLAS, TEXAS PHONE: 214-736-4886 FAX: 214-272-8816 www.MINTdentistry.com		M. E. N. P. ENGINEERS - REGISTRATION F-12249 144 NORTH SPRING CREEK DRIVE RICHARDSON, TEXAS EMAIL: KOHSHI1@AOL.COM
	SHEET TITLE: MECHANICAL PLAN	SHEET NO.: 01	DATE: 01/11/01	DRAWN BY: J. COOPER

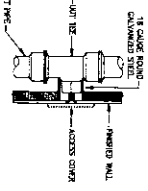


04 WALL CLEAN-OUT DETAIL
N.T.S.

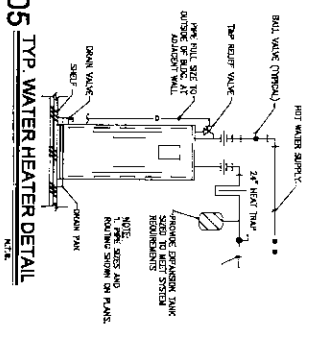


05 TYP WATER HEATER DETAIL
N.T.S.

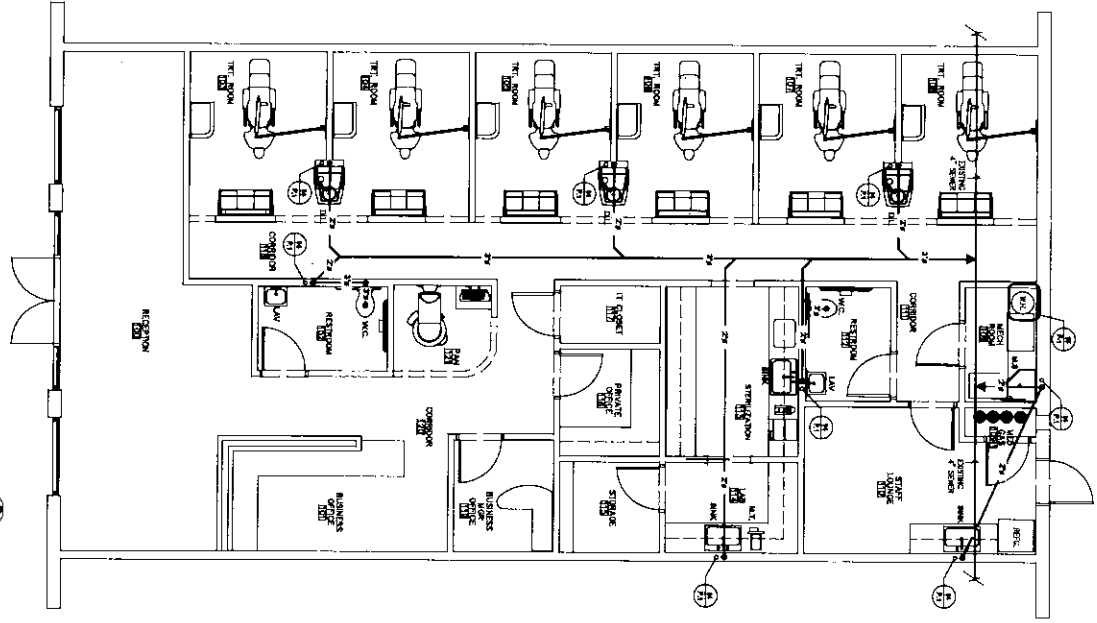

01 PLUMBING PIPING PLAN
N.T.S.

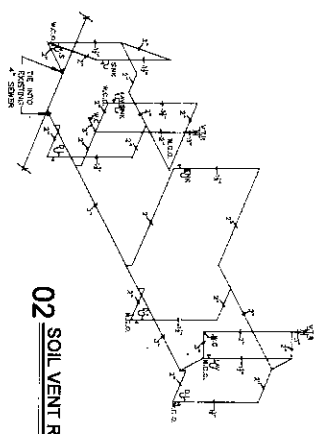

02 SOIL VENT RISER
N.T.S.

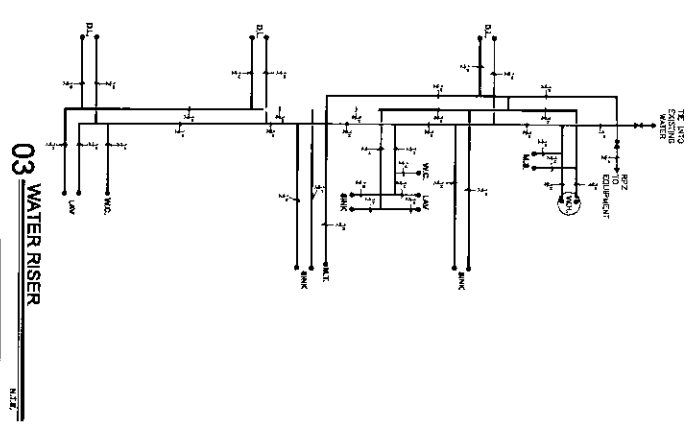

03 WATER RISER
N.T.S.

PLUMBING PIPING LEGEND	
—	HOT WATER
—	COLD WATER
—	SEWAGE/STACK
—	VENT

PLUMBING PIPING LEGEND	
—	SOIL VENT
—	VENT
—	DRY DRAIN
—	WET DRAIN
—	WATER HEATER
—	WATER HEATER

P.1

MINI dentistry

MINI DENTISTRY - TERRELL
806 America Way suite 200
TERRELL, TEXAS 75169



REVISIONS:

SHEET TITLE: **PLUMBING PLAN**

DENTAL CONSTRUCTION SPECIALIST
5884 N. CENTRAL EXPY., SUITE 406
DALLAS, TEXAS
PHONE: 214-726-4888
FAX: 214-722-8816
www.MINIDentistry.com



M. E. N. P. ENGINEERS
REGISTRATION F-12248
124 NORTH SPRING CREEK DRIVE
RICHLANDS, TEXAS
EMAIL: KCHSHITI@AOL.COM

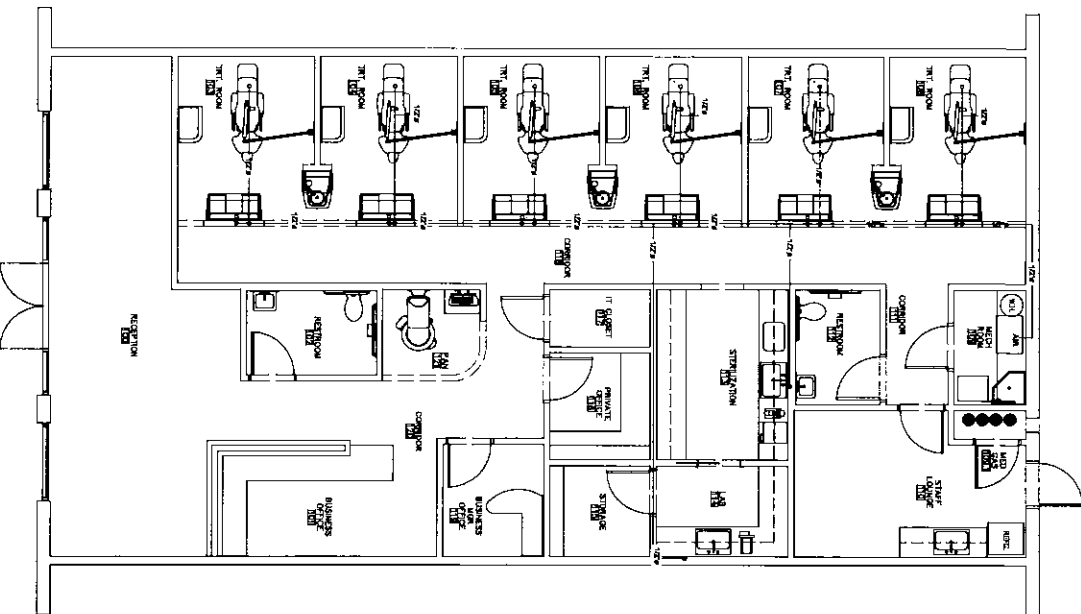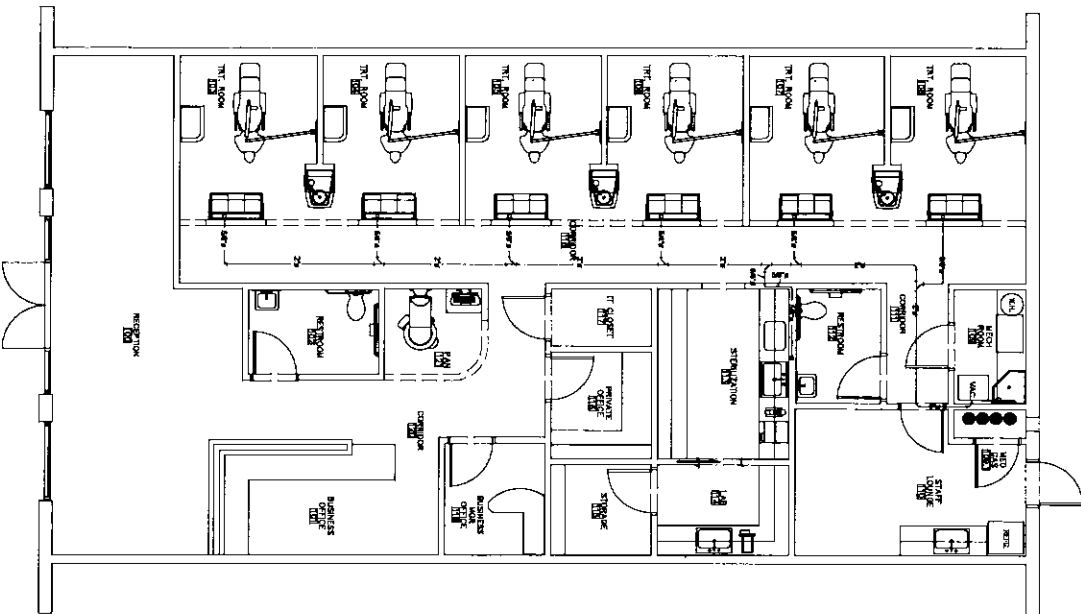

PLUMBING PIPING LEGEND

NOTE: ALL VACUUM PIPING INSTALLATION SHALL COMPLY WITH THE 2010 IBC IN TEXAS.

VACUUM PIPING: VACUUM, AIR LINE, HYDROBULB AS SHOWN, COPPER (TYPE-L)

P.1.1

DATE: 08/08/10
 DRAWN: J. B. BROWN
 CHECKED: J. B. BROWN
 SCALE: 1/8" = 1'-0"

MINT dentistry

REVISIONS:



SHEET TITLE: AIR & VACUUM PIPING PLAN

DENTAL CONSTRUCTION SPECIALIST
 1666 N. CENTRAL EXPY., SUITE 400
 DALLAS, TEXAS
 PHONE: 214-736-6998
 FAX: 214-272-8816
 www.MINTdentistry.com



M. E. N. P. ENGINEERS
 REGISTRATION F-12249
 124 NORTH SPRING CREEK DRIVE
 RICHARDSON, TEXAS
 EMAIL: KCHISHTI@AOL.COM


Mint Terrell LIGHTING

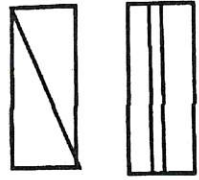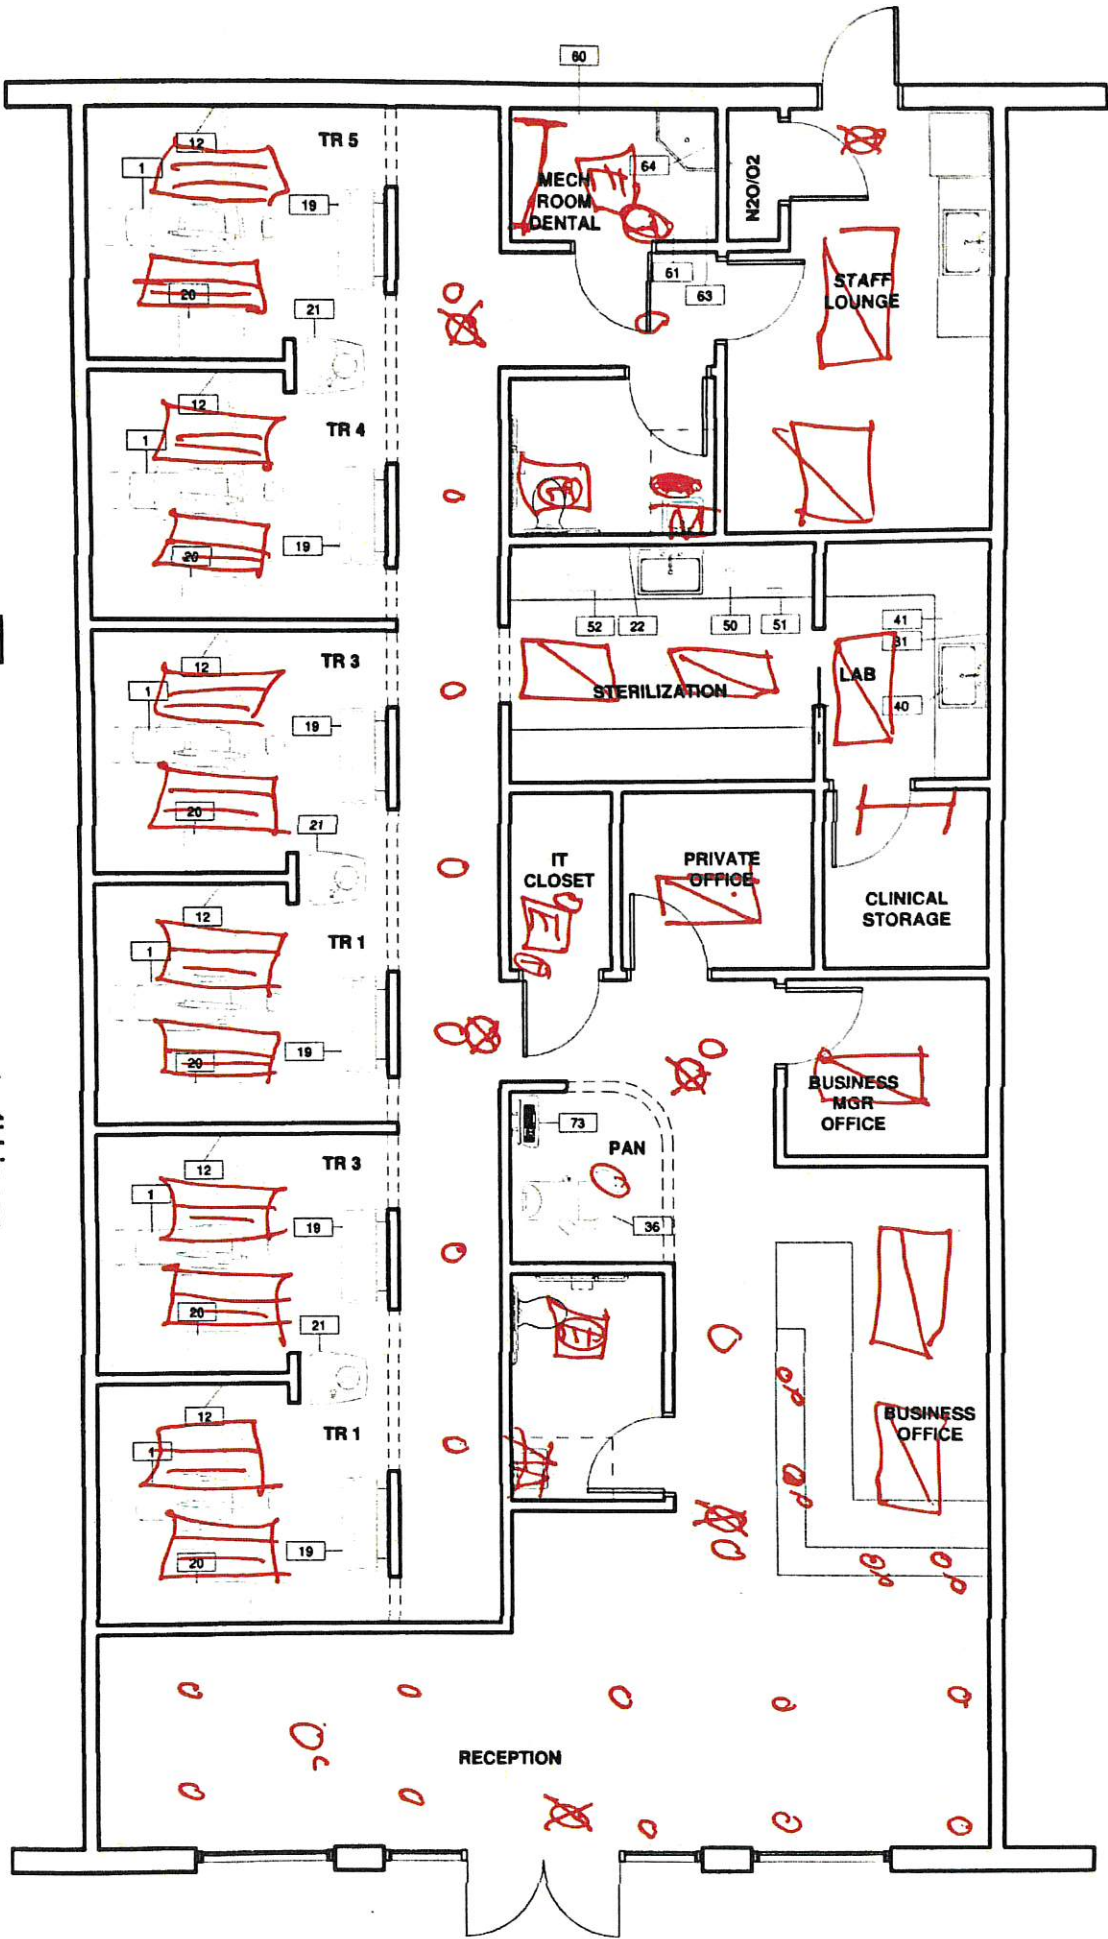

2x4 3 Bulb Ovation
2x4 3 Bulb Linear Fluorescent



 Exhaust
Thermostat
Pendant



4' Linear Fluorescent



Vanity Lights




Illuminated EXIT Light




6" Can Light

Emergency Fixtures as Required

Channel

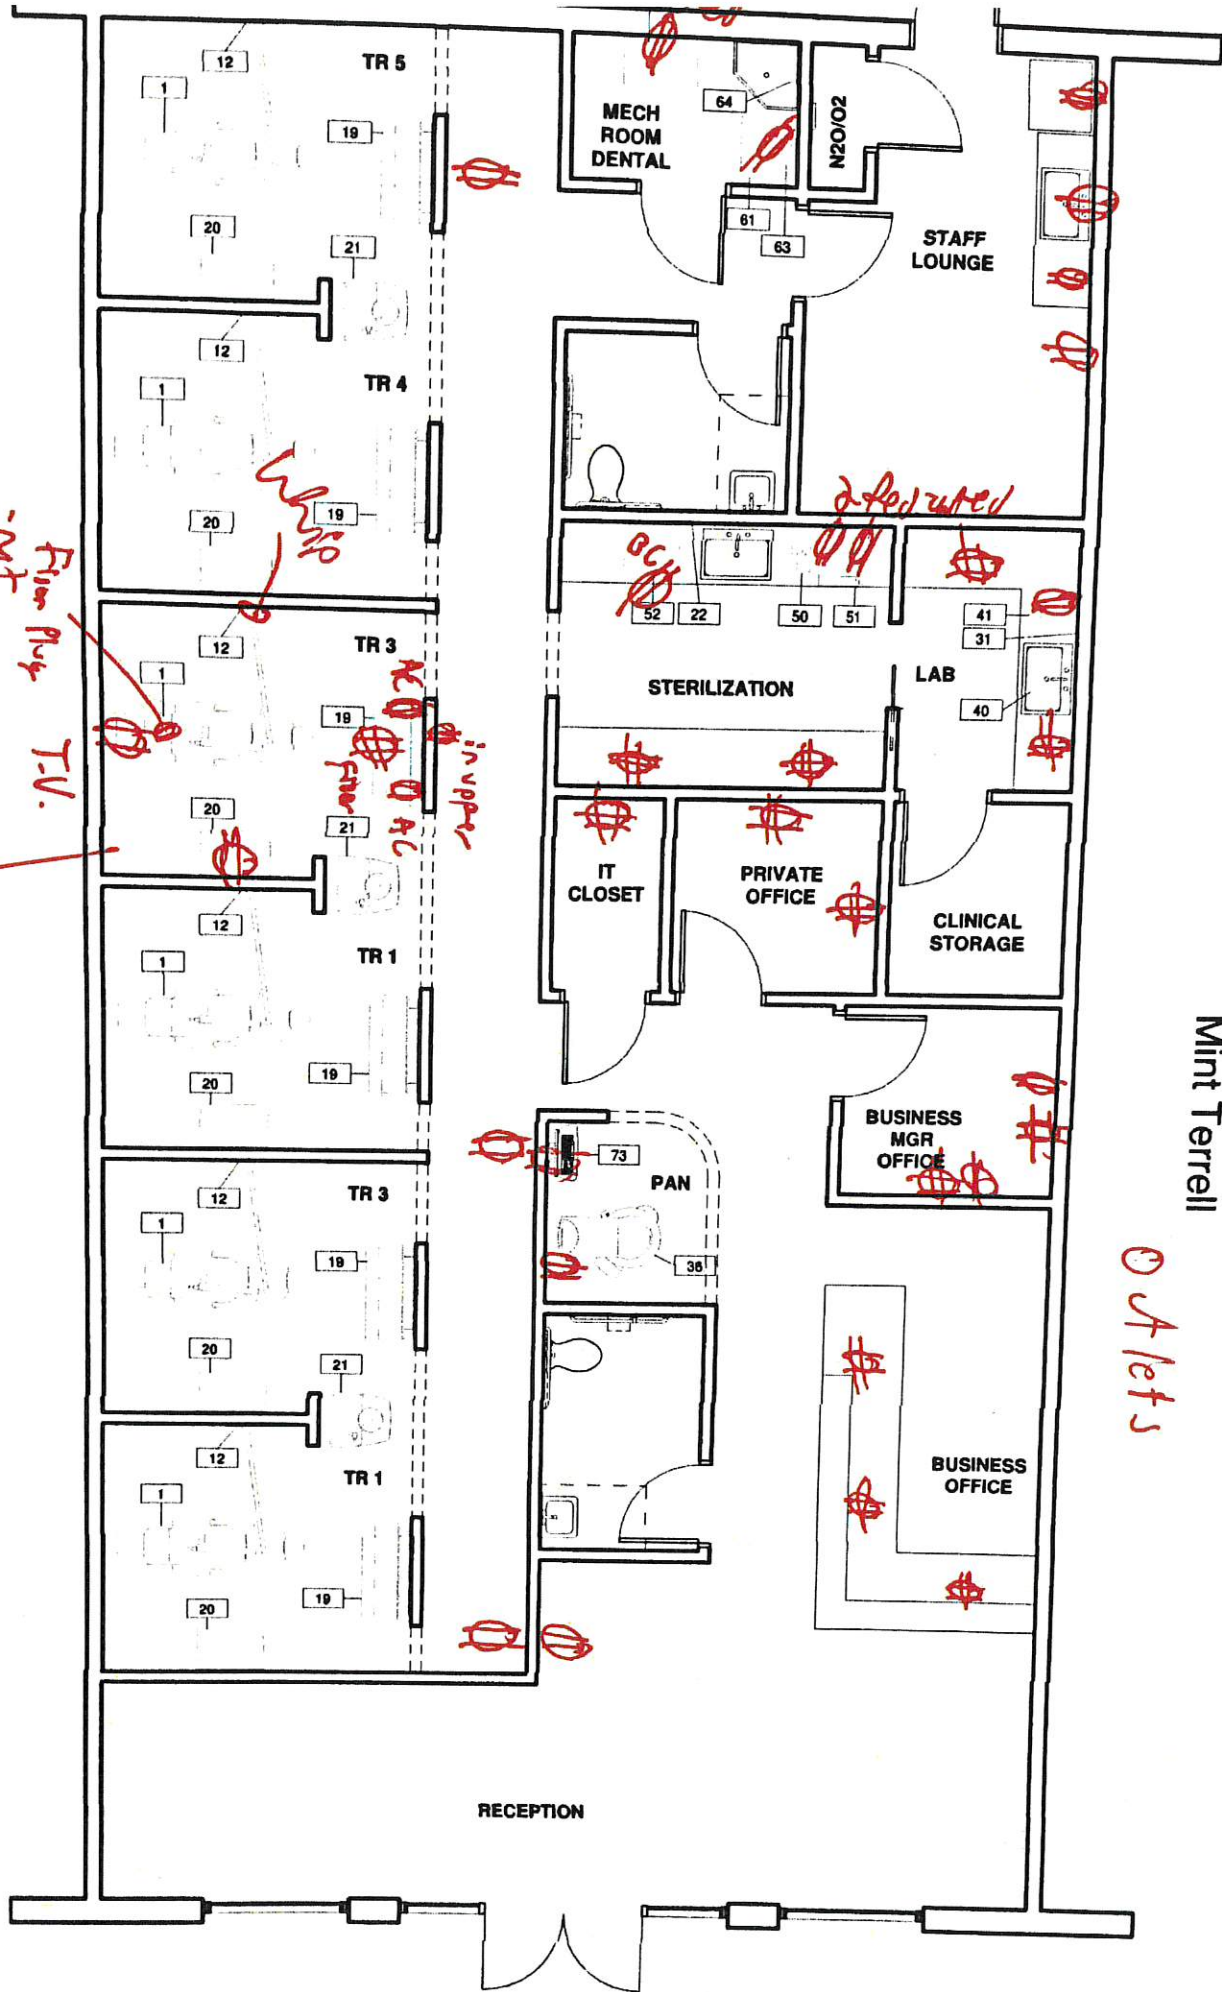

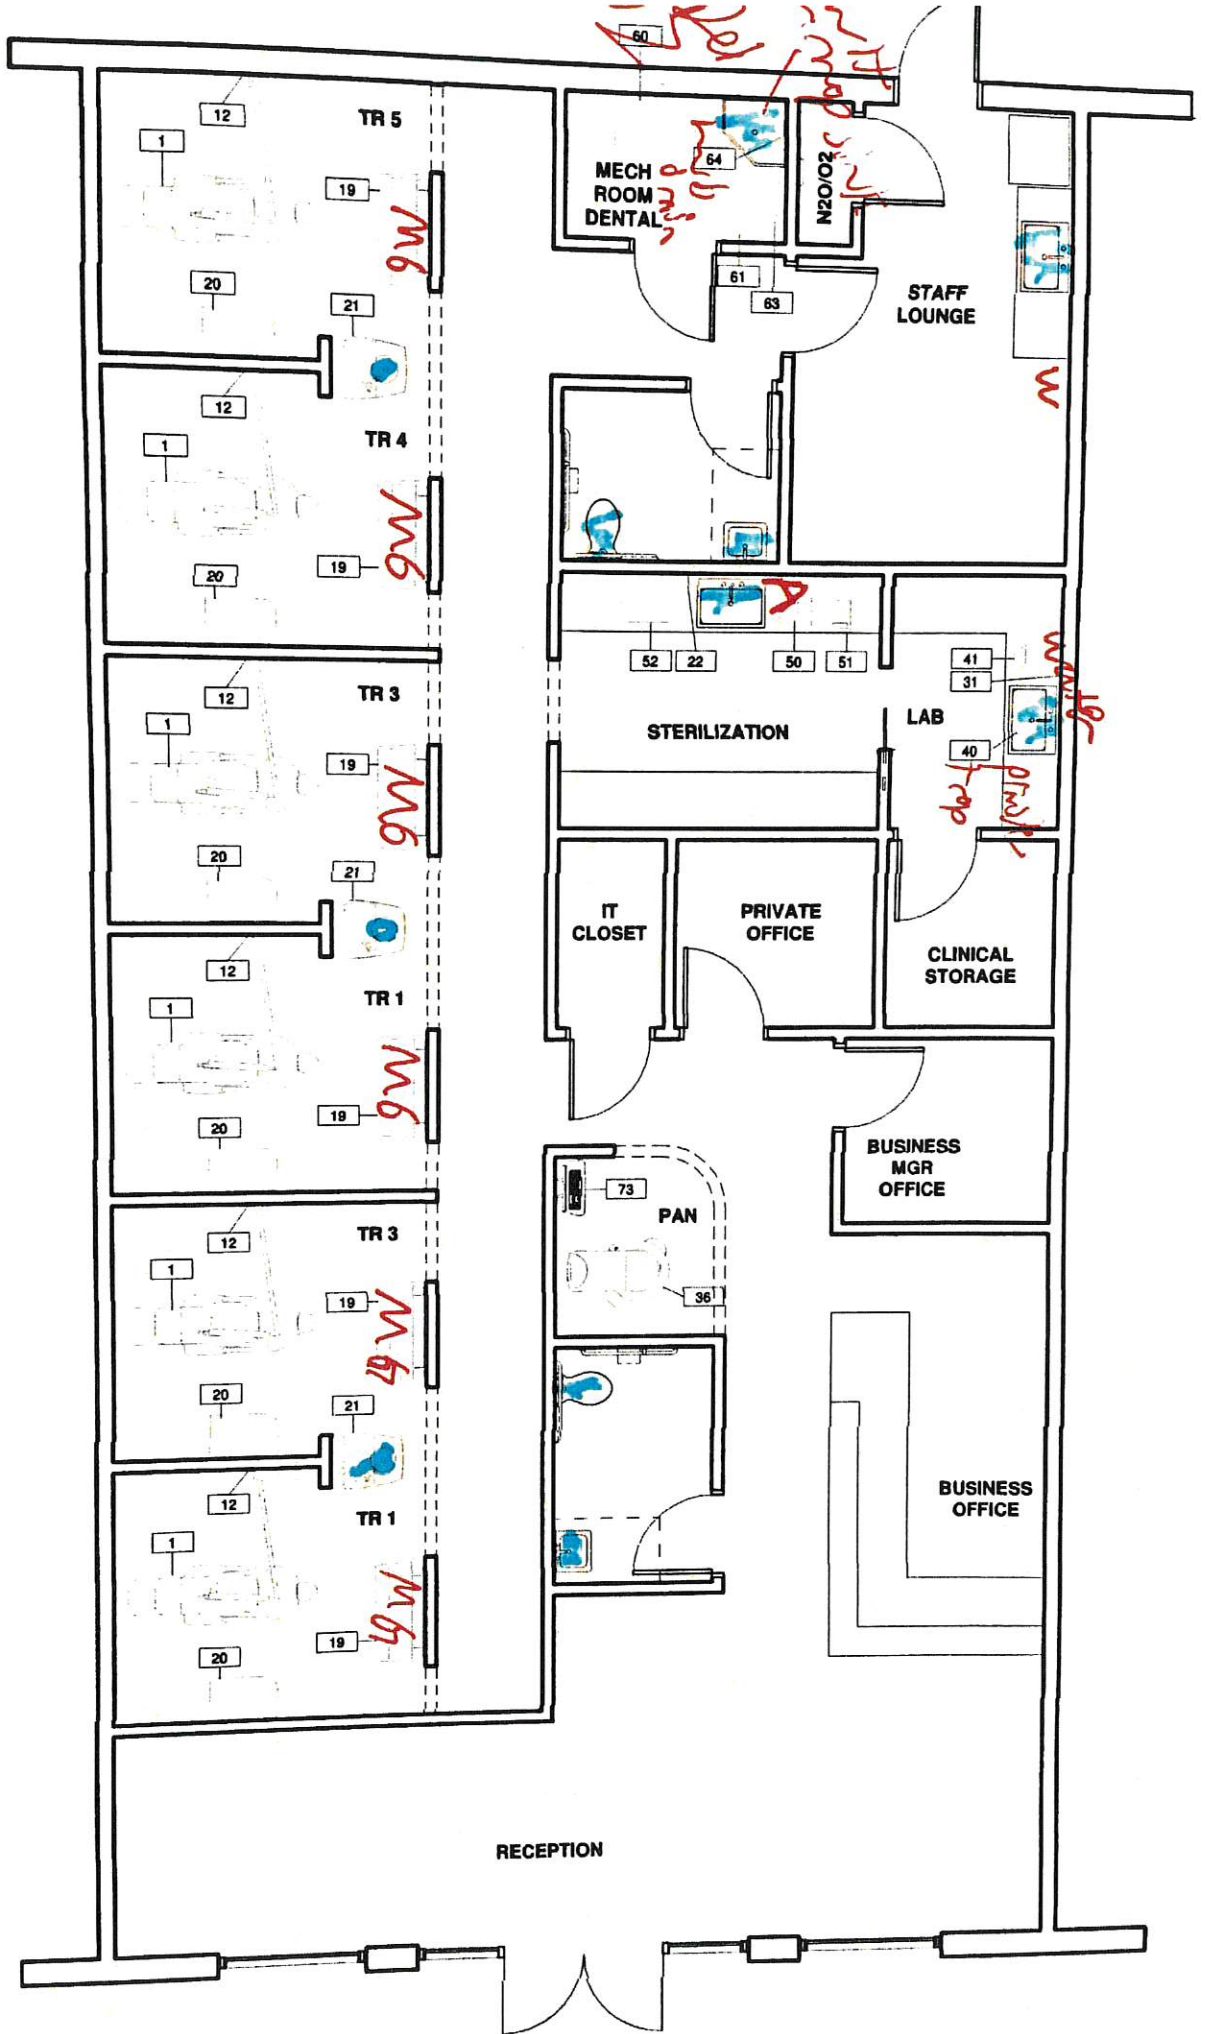

MG = NO2, O2, Vacuum and Compressed air

A = Air

V = Vacuum

W = water line

PLUMBING



GABRIEL BUILDING SUPPLY

AMITE

900 West Oak St.

Amite, LA 70422

PHONE: (985) 748-3525

Receipt REQUIRED for Return or Exchange
Returns Subject to 20% Service Charge

SOLD TO:

K B KAUFMANN & CO INC
3173 TERRACE AVE EAST
SLIDELL
(985) 849-7381
LA 70458

CUSTOMER NO: 482

TERMS: NET 10TH

DATE / TIME: 7/28/21 7:30

CLERK / TERM: BLA

SALESPERSON: BRENDA ANDRESS

TAX CODE: A

CITY OF AMITE

SHIP TO:

JOB NO: 000
DUE DATE: 8/10/21

INVOICE: 70244 / 2

QUANTITY	UM	ITEM	DESCRIPTION	UNITS	LOCATION	PRICE	PER	EXTENSION
2	EA	16116	2" x .099 Bright Screw Coil Nail	2	06N02	52.99	EA	105.98
			** AMOUNT CHARGED TO STORE ACCOUNT **	117.05				
			TAXABLE					105.98
			NON-TAXABLE					0.00
			SUB-TOTAL					105.98
			TAX AMOUNT					11.07
			TOTAL AMOUNT					117.05

X.M. [Signature]

Received By

(GEORGE MCCLENDON)

^ b

482000 70244