



THE ABOVE DRAWINGS AND SPECIFICATIONS AND ALL CORRECTIONS AND REVISIONS THEREON SHALL REMAIN THE PROPERTY OF THE ARCHITECT, AND NO PART THEREOF SHALL BE REPRODUCED, COPIED, REPRODUCED, OR USED IN CONNECTION WITH ANY WORK ON THIS PROJECT WITHOUT THE WRITTEN CONSENT OF THE ARCHITECT. THESE DRAWINGS OR SPECIFICATIONS SHALL CONSTITUTE THE ENTIRE CONTRACT BETWEEN THE ARCHITECT AND THE CONTRACTOR. ANY CHANGES TO THESE DRAWINGS OR SPECIFICATIONS SHALL BE MADE BY THE ARCHITECT AND SHALL BE SUBMITTED TO THE OFFICE FOR APPROVAL AND RECORDING WITH THE PROJECTING ENGINEER. CONTRACTORS SHALL VERIFY AND BE RESPONSIBLE FOR ALL DIMENSIONS AND CONDITIONS OF ALL WORK AND CONDITIONS. ANY VARIATIONS FROM THE DIMENSIONS AND CONDITIONS SHOWN ON THESE DRAWINGS SHALL BE NOTIFIED OF ANY CHANGES TO THESE DRAWINGS. SHOP DETAILS MUST BE SUBMITTED TO THE OFFICE FOR APPROVAL AND RECORDING WITH THE PROJECTING ENGINEER.

OCHSNER
 NORTH CAMPUS
 INTERNAL
 MEDICINE
 RELOCATION
 OCHSNER MEDICAL CENTER
 1401 Jefferson Highway
 Jefferson, LA 70121


Copyright © 2010
 Eskew+Dumez+Ripple /
 Rozas-Ward, Joint Venture
 Date: 16 MAY 2011

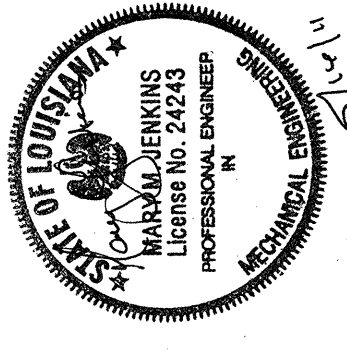


PLUMBING RISER DIAGRAMS
EDR No. 09023
RWA No. 09024
drawn: SMS
checked: MMU
approved: MMU
sheet:

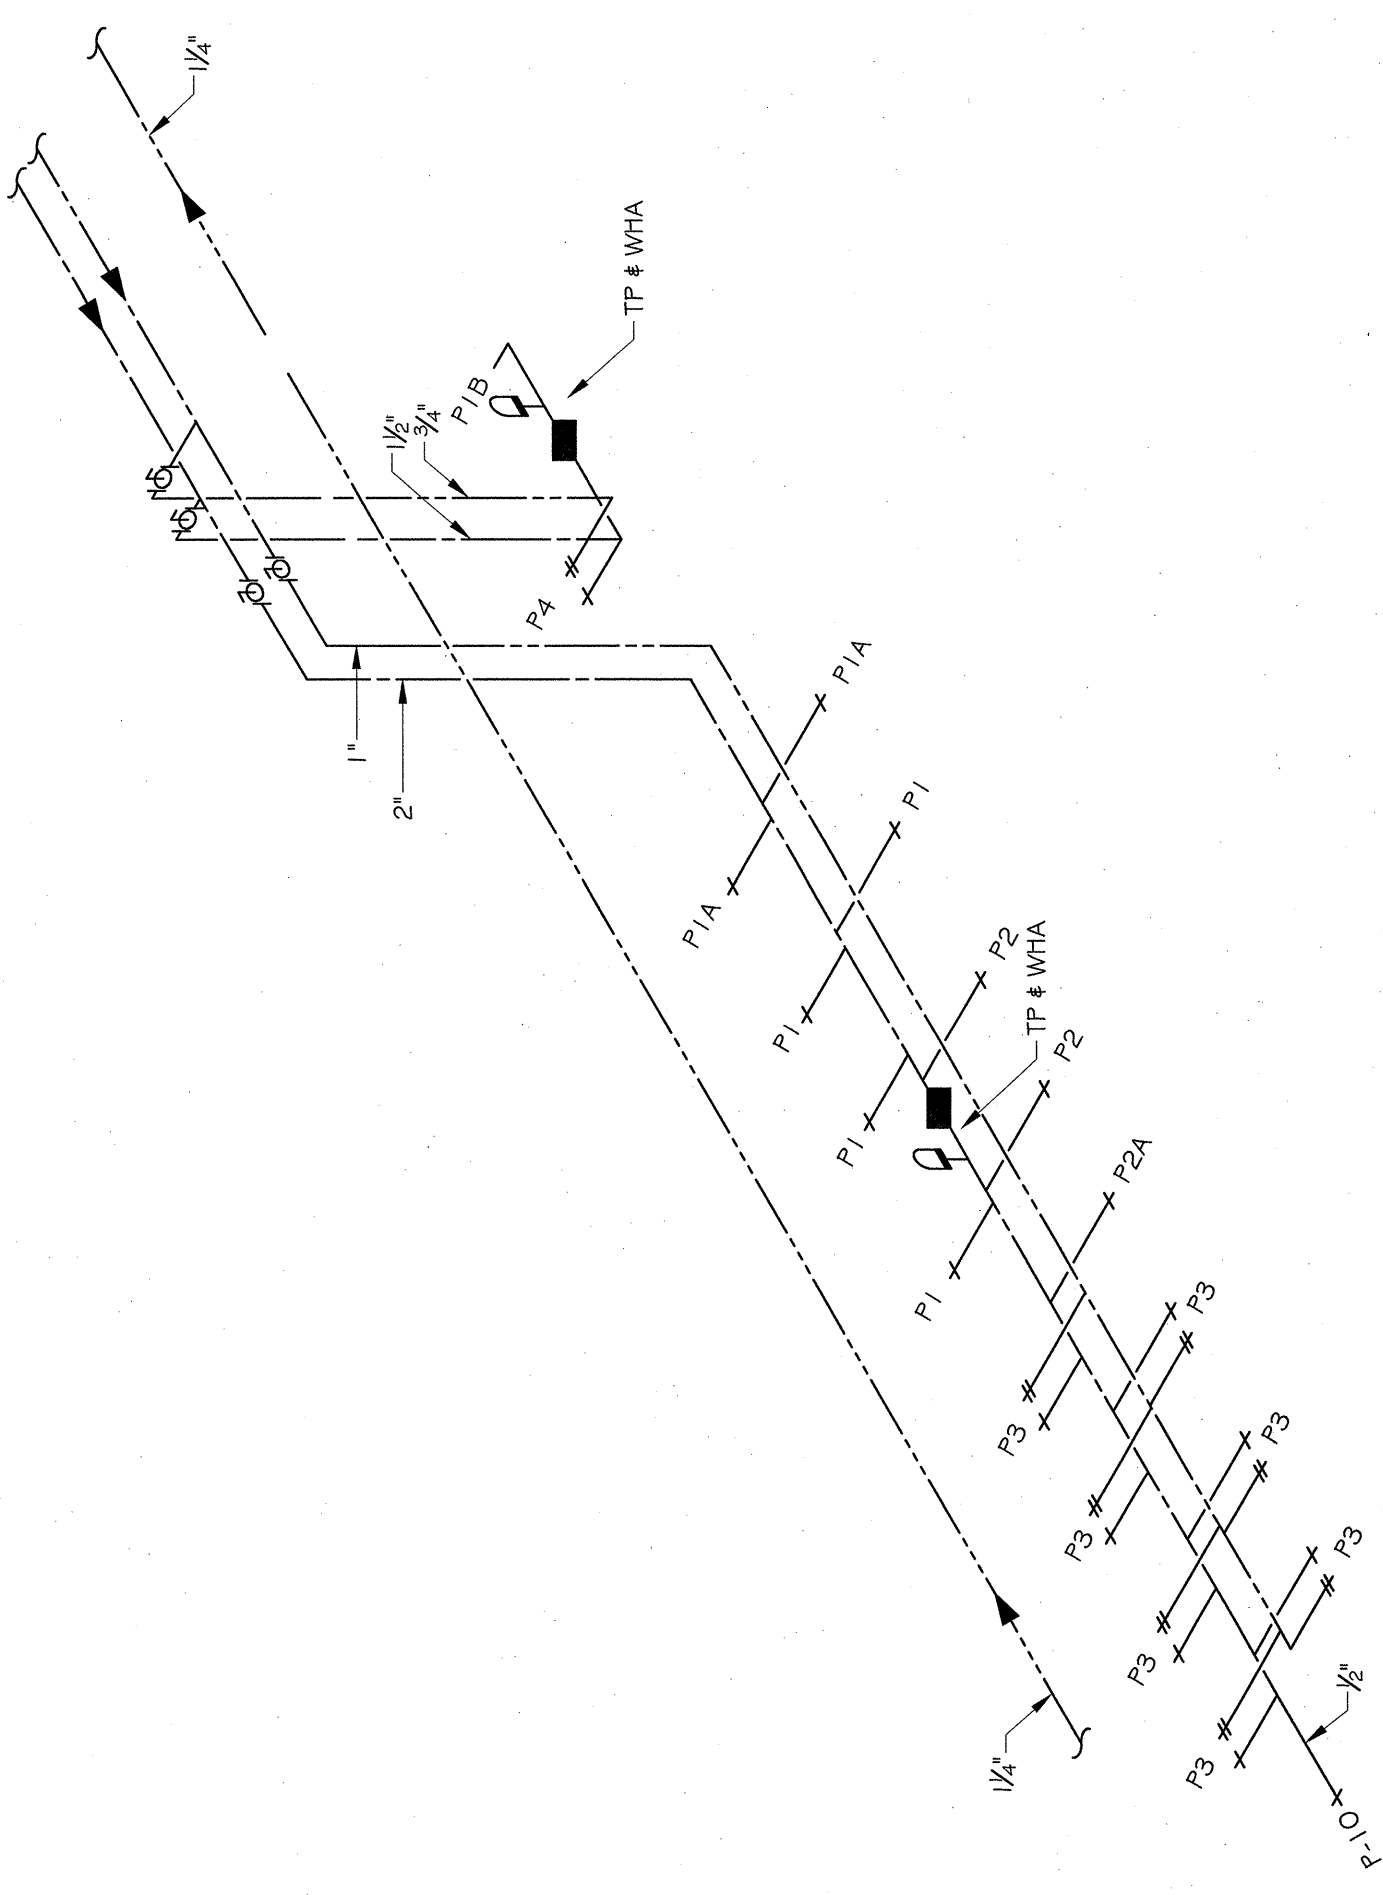


2 PLUMBING RISER DIAGRAM -
 PRESSURE PIPING - ROOMS 1Y116 & 118
 P7.0 NO SCALE

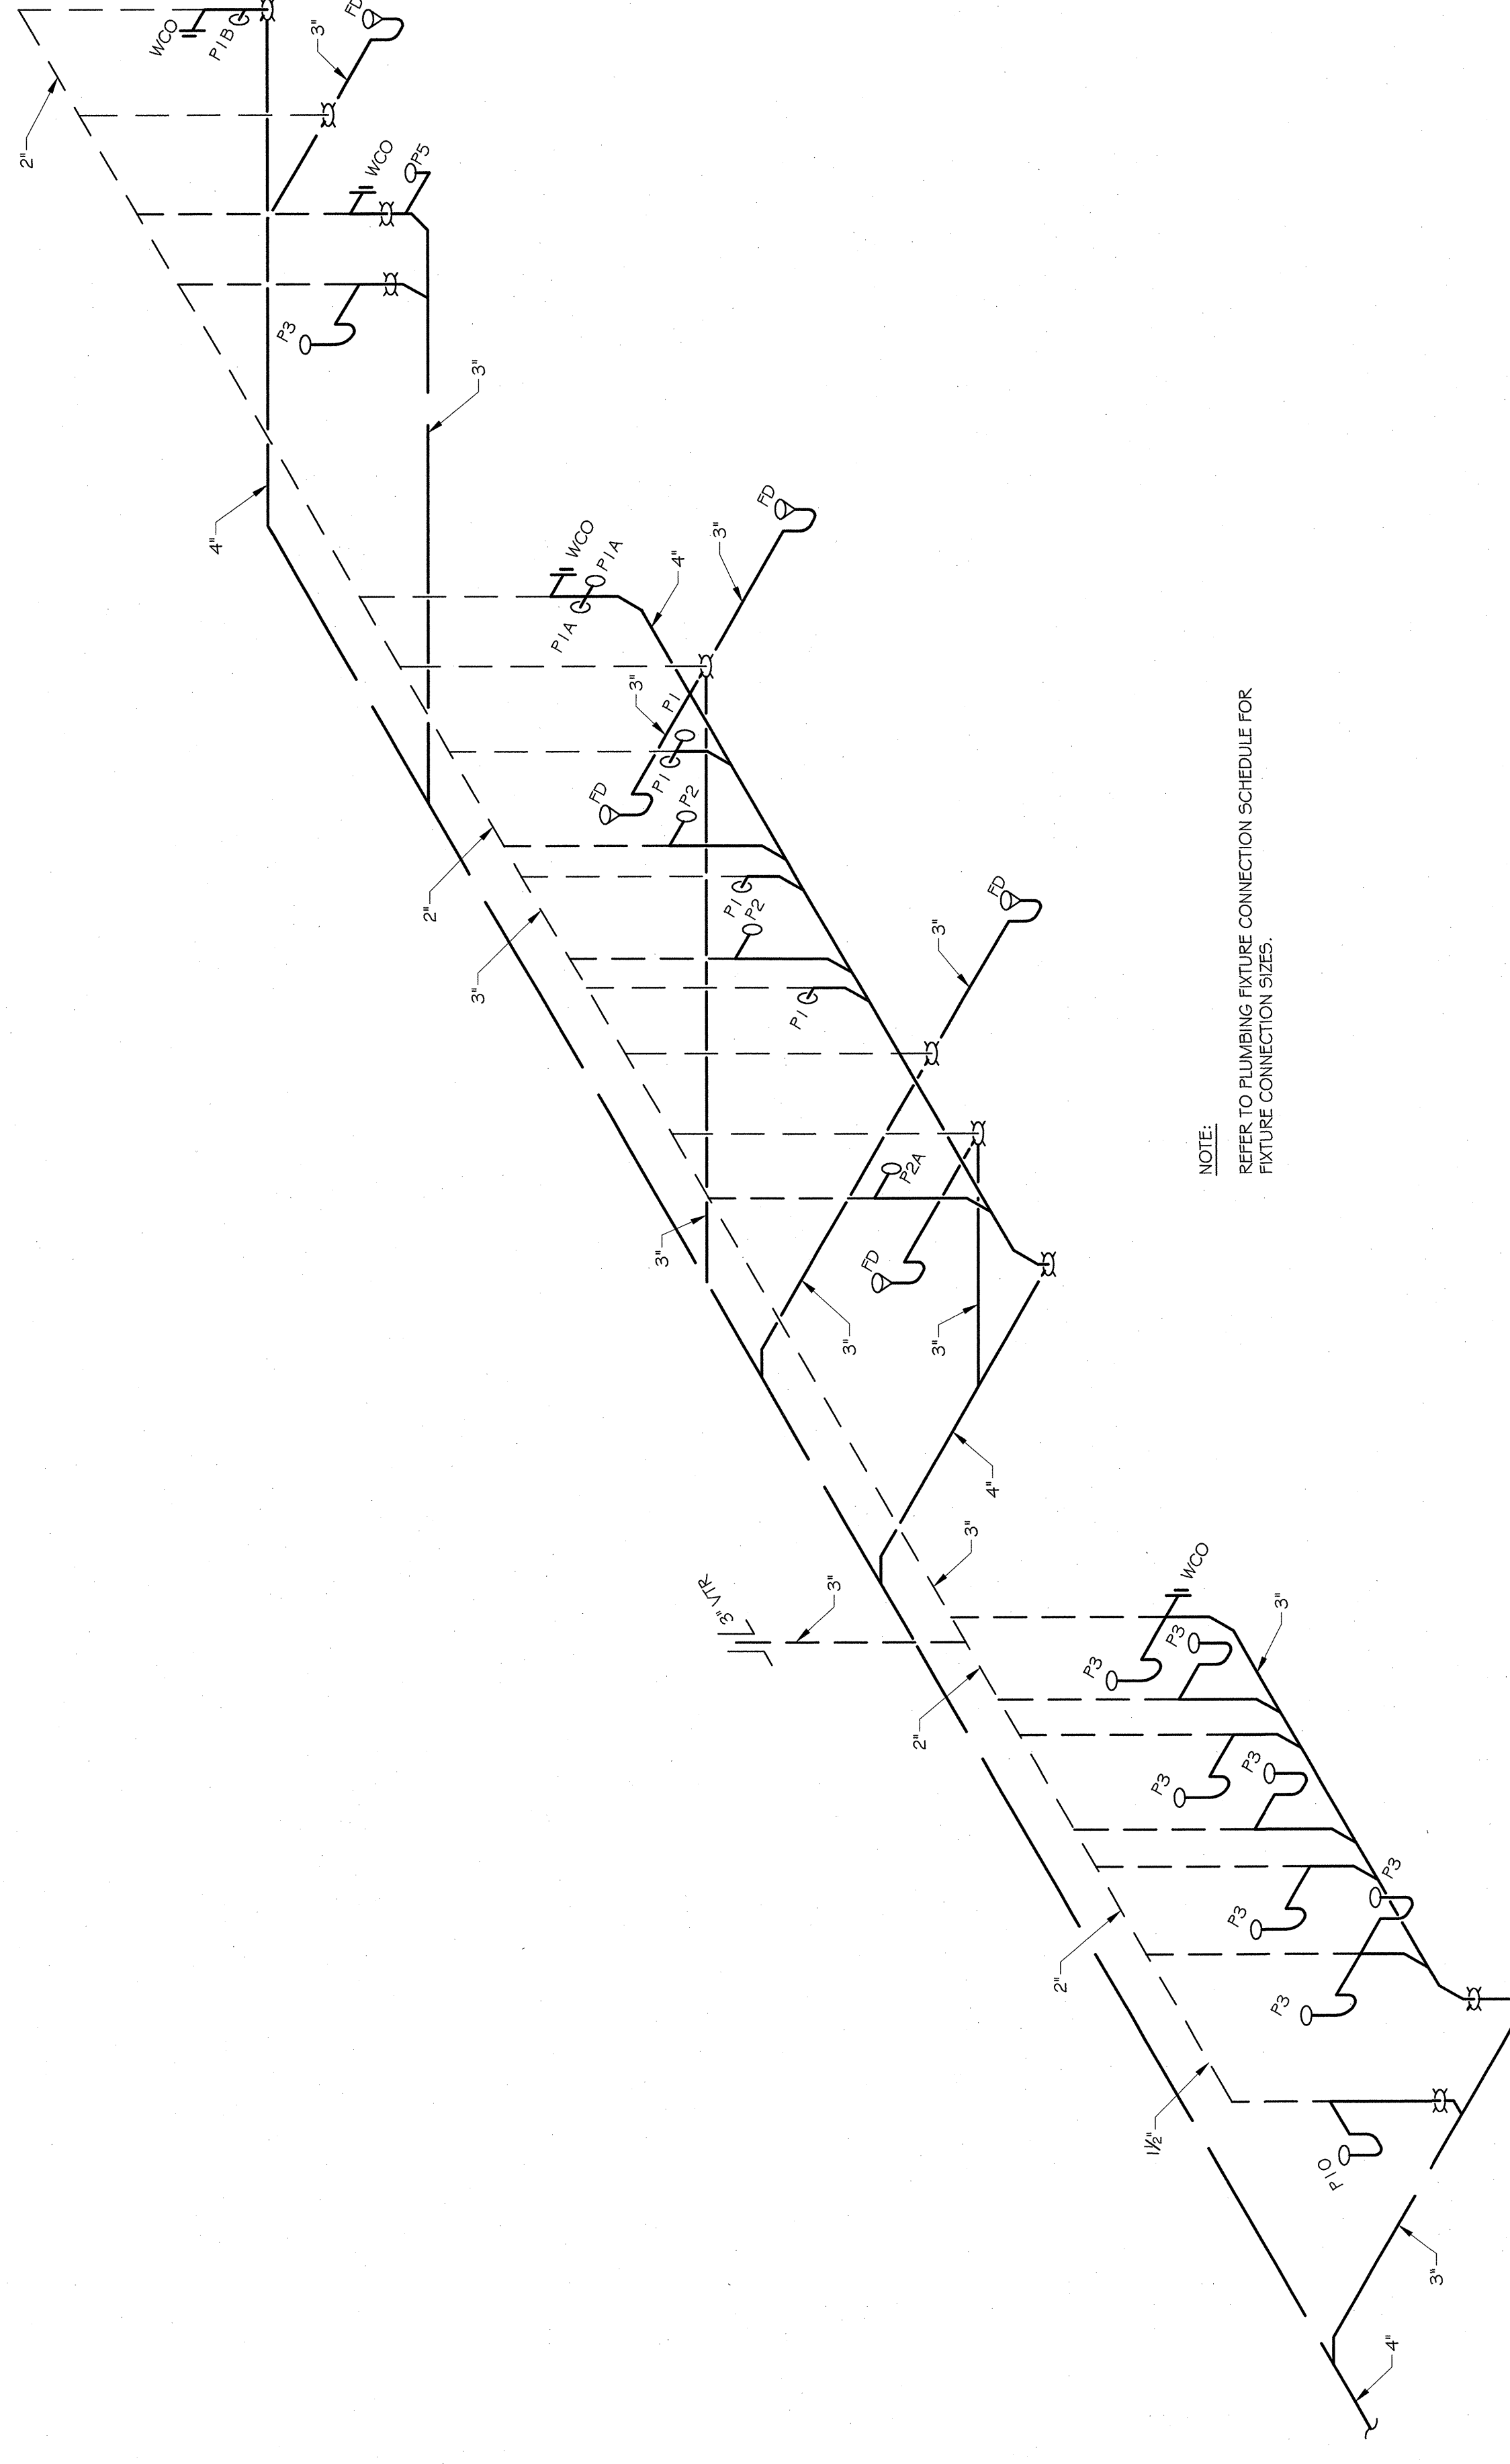

4 PLUMBING RISER DIAGRAM -
 GRAVITY PIPING - ROOMS 1Y125 & 127
 P7.0 NO SCALE

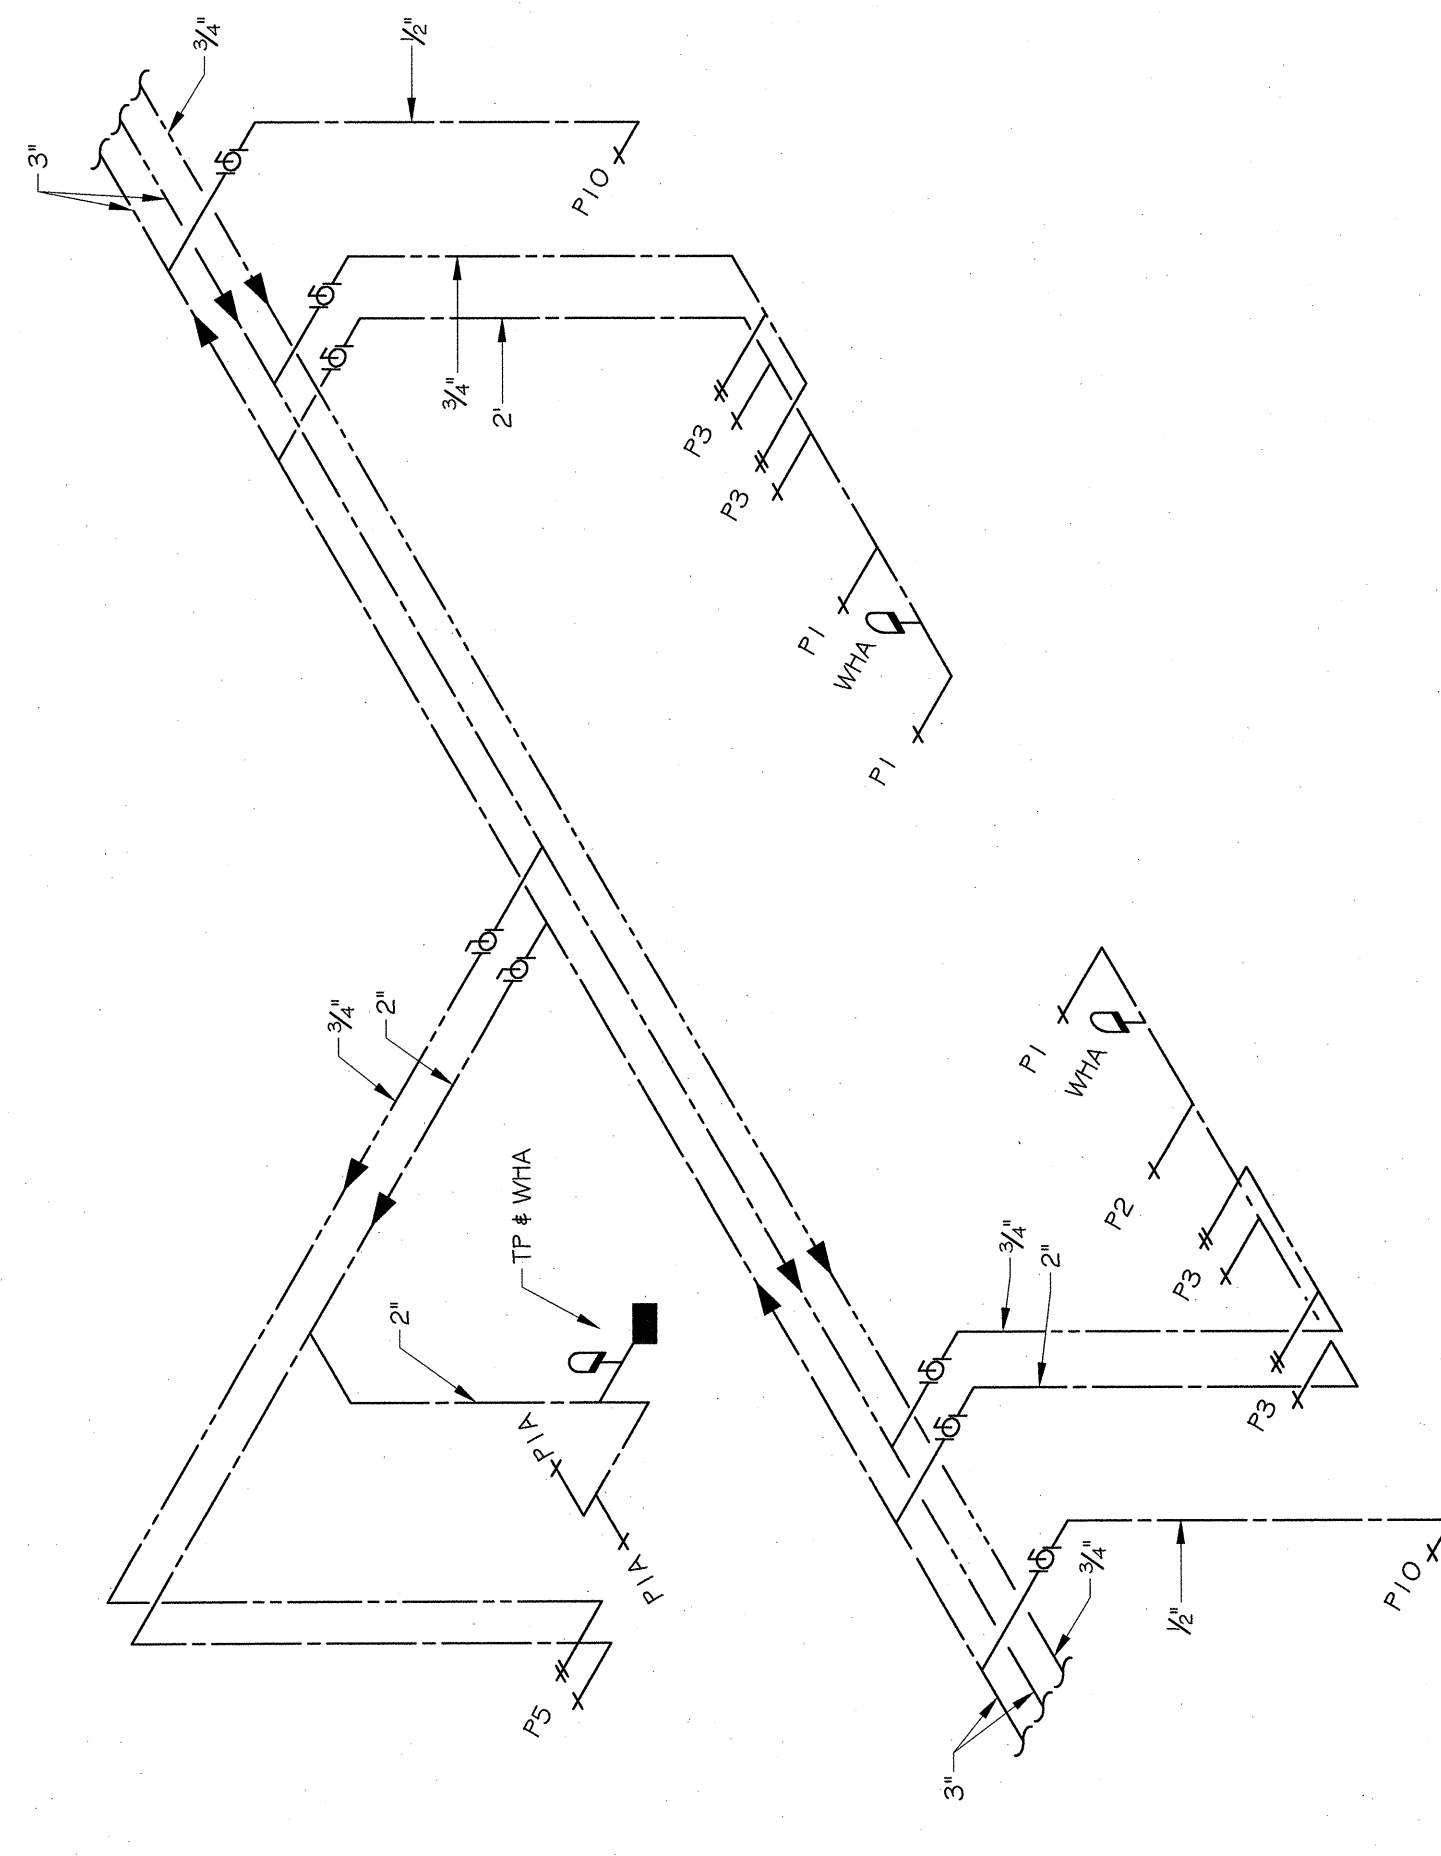

3 PLUMBING RISER DIAGRAM -
 PRESSURE PIPING - ROOMS 1Y125 & 127
 P7.0 NO SCALE

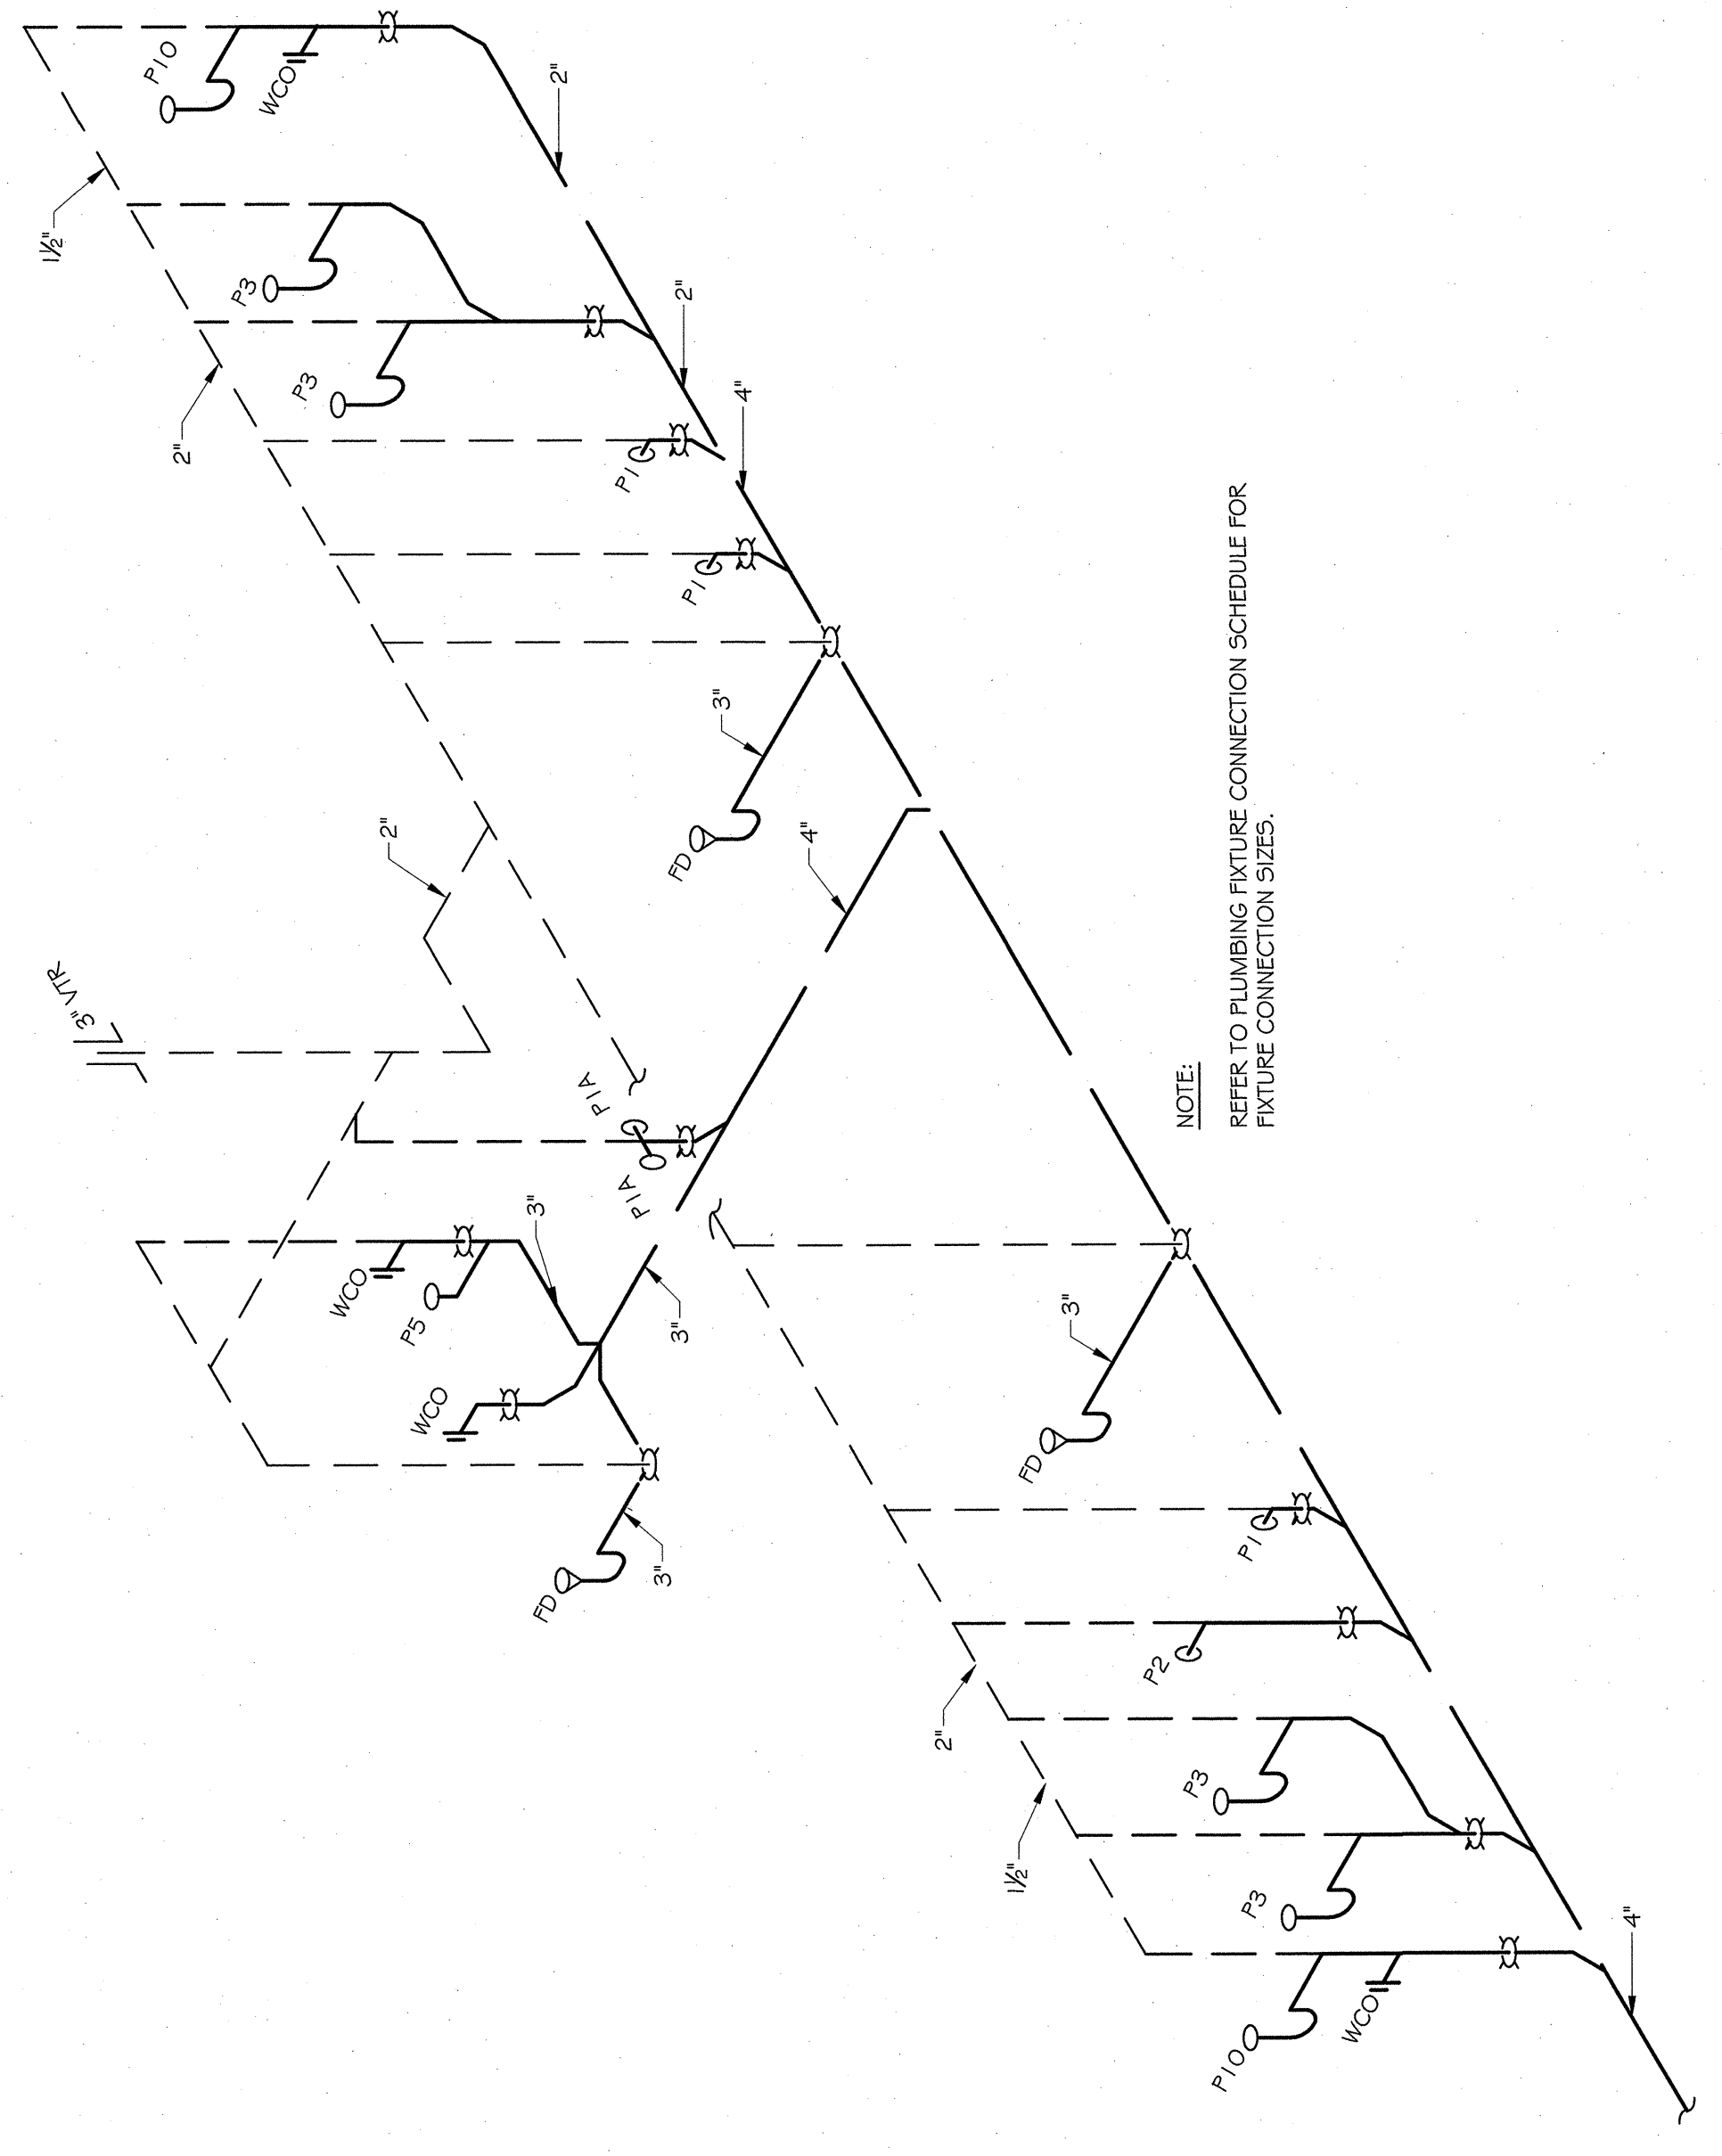

3 PLUMBING RISER DIAGRAM -
 GRAVITY PIPING - ROOMS 1Y125 & 127
 P7.0 NO SCALE