

649 ← 8500

26



1'1 3/4  
3'1" 5

Symt	
	Plan Detail Designation: Detail No. 1 On Sheet A-1
	Height From Finished Floor: Used in Plan And Section
	Elevation Designation: Elevation No. 1 On Sheet A-1
	Sprinkler Head At Specified Height
	Revision Number 1
	Section Detail Designation: Section No. 1 On Sheet A-1
	2' X 2' Supply Air Grille
	2' X 2' Return Air Grille
	2' X 4' Fluorescent, 4-1 amp Light Fixtures (U.N.O.)
	4' Fluorescent Strip
	Recessed Can Fixture
	Wall Mounted Light Fixture
	Exit Light - Wall Mounted
	Exit Light - Ceiling Mounted
	Door Designation: Door 1 (See Schedule Hardware (See Schedule and Specs)
	4' Wall Mounted Fluorescent
	Fire Extinguisher
	2' X 2' Exhaust Air Grille
	2' X 2' Fluorescent 2-1 amp Fixture
	Exhaust Air Grille: See Mechanical Plan For Size

- Key Notes:**
- Owner furnished and installed Paper Towel Dispenser. Contractor to provide Blanking At This Location.
  - Toilet Paper Dispenser-Bradley #7502 (Or Equal)
  - Robe Hook Mounted At 6'-0" A.F.L.-Bradley #9124 (Or Equal)
  - Channel Framed Mirror 24" X 36"-Bradley #701 (Or Equal)
  - Grab Bar 16"-Bradley #812001 (Or Equal) (L.O. Bar @ 36" A.F.L.)
  - Grab Bar 14"-Bradley #812001 (Or Equal) (L.O. Bar @ 36" A.F.L.)
  - Pass Through Specimen Cabinet - Bradley #9813 (Or Equal)
  - 1" Horizontal Louver Blinds-Hunter Douglas, with top lock (Or Equal)
  - Fire Extinguisher & Cabinet (See Specifications)
  - 5 - 1/4" Thick X 1/2" Deep Wood Shelves, Painted All Sides & Edges On Heavy Duty KV Standards & Brackets Brackets Secured To Studs @ 16" O.C. Lengths On Shelving As Indicated On Plan
  - Countertop-2 Layers 3/4" Plywood with Plastic Laminate
  - Backsplash-1 Layer 3/4" Plywood with Plastic Laminate
  - Curtain Track-Track Imperial Easton Co. Model H.C. 298, With Carriers & Curtain (Or Equal)

Wall Types Legend:	
	Non-Rated Partition: See Partition Types on Sheet A-0.0 For Detailed Partition Construction Information
	Sound Partition: See Partition Types on Sheet A-0.0 For Detailed Partition Construction Information
	1-Hour Rated Partition: See Partition Types on Sheet A-0.0 For Detailed Partition Construction Information
	Existing Smoke Partition
	Existing 1-Hour Rated Partition
	Existing 2-Hour Rated Partition
	Existing Non-Rated Partition
	Existing Partition To Be Demolished
	Wall Type Denotation Symbol - See Sheet A-0.0

NOTE: ALL EMPLOYED CORNERS ON CONNECTIONS TO HAVE 3/4" RADIUS.

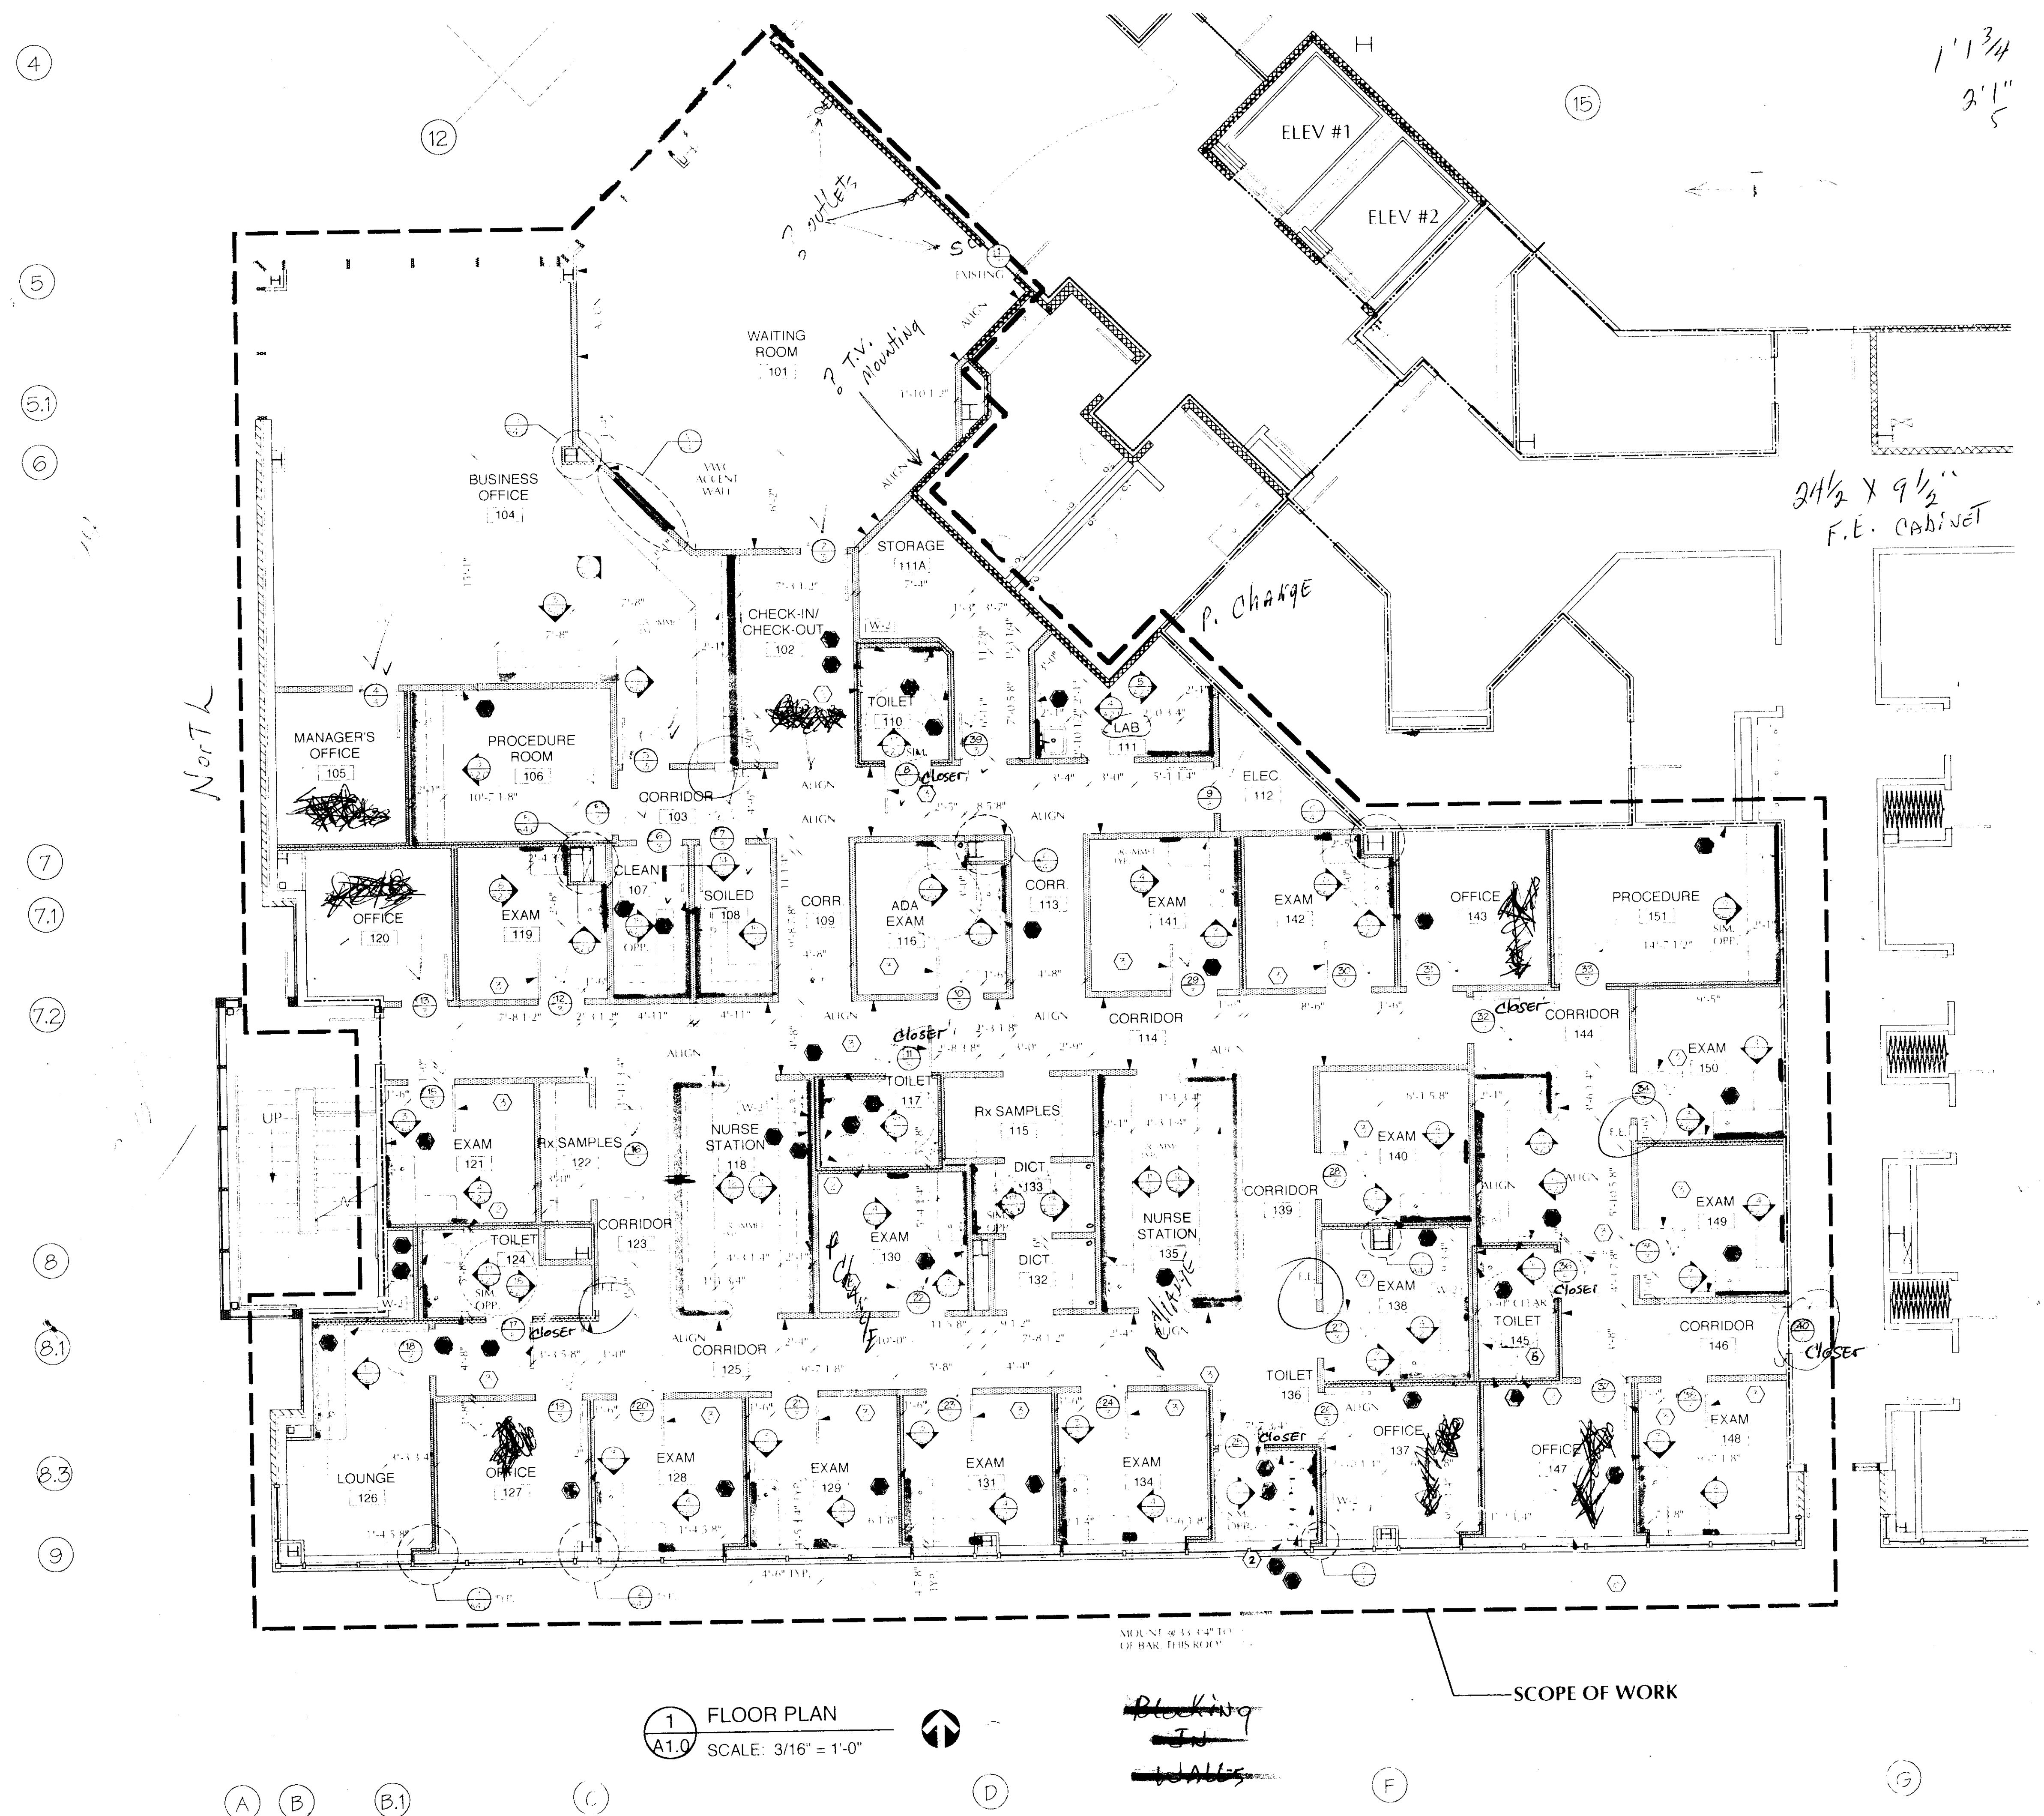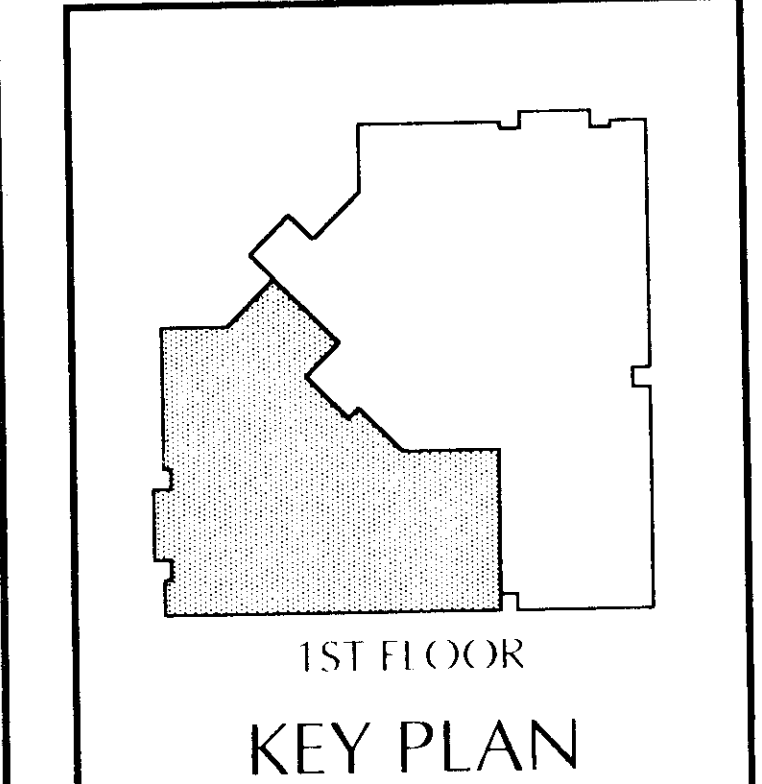

1 FLOOR PLAN  
A1.0 SCALE: 3/16" = 1'-0"

Blanking  
In  
Tables

SCOPE OF WORK



107 THIBODEAU LASSALLE  
SUITE 400  
NEW ORLEANS, LA 70110  
504-596-4110  
pcampo@campo.com

Tenant Improvements for  
**IMG**  
S.M.H. Founders Medical Bldg.

**ISSUE DATES**

DATE	BY	REVISION
12/19/99	TJ	50 Review
10/21/99	Car	90% Review
10/26/99	Car	Board

**REVISIONS**

DATE	BY	DESCRIPTION

**PROGRESS PRINT**

**PARTIAL RELEASE**

**FULL RELEASE**

JOB NUMBER:  
97-40-50  
DRAWN BY:  
BIDE  
CHECKED BY:  
IWZ

Floor Plan  
**A1.0**  
OF SHEET