

**Symbol Legend:**


	Plan Detail Designation: Detail No. 1 On Sheet A*1
	Height From Finished Floor: Used in Plan and Section
	Elevation Designation: Elevation No. 1 On Sheet A*1
	Sprinkler Head At Specified Height
	Revision Number 1
	Section Detail Designation: Section No. 1 On Sheet A*1
	2' X 2' Supply Air Grille
	2' X 2' Return Air Grille
	2' X 4' Fluorescent, 4 Lamp Light Fixtures (U.S.C.)
	4' Fluorescent Strip
	Recessed Can Fixture
	Wall Mounted Light Fixture
	Exit Light - Wall Mounted
	Exit Light - Ceiling Mounted
	Door Designation: Door 101 (See Schedule Hardware - See Schedule and Specs)
	4' Wall Mounted Fluorescent
	Fire Extinguisher
	2' X 2' Exhaust Air Grille
	2' X 2' Fluorescent, 2 Lamp Light Fixture
	Exhaust Air Grille: See Mechanical Plan For Size

**Wall Types Legend:**

	Wall: 5 1/2" Mt. Studs At 16" O.C. With One Layer 5/8" Gyp. Bd. To 6" Above Ceiling, Both Sides (U.S.C.)
	Exterior Masonry Wall (See Details)
	Smoke Partition: One Layer 5/8" Type X Gyp. Bd. Each Side Of Stud - Extend Studs X 1 Layer Of Gyp. Bd. Cont. To Struct. Deck. Seal all joints to prevent passage of smoke (NFPA 101-6.3)
	One Hour Rated Wall: One Layer 5/8" Type X Gyp. Bd. Each Side Of Stud Extend To Struct. Deck.
	Two Hour Rated Wall: Two Layers 5/8" Type X Gyp. Bd. Each Side Of Stud Extend To Struct. Deck.
	Interior Sound Partition
	Wall Type Definition Symbol - See Sheet A*0.1

NOTE: Refer to Sheet A\*0.1 For Detailed Partition Types

NOTE: See A\*1.1 Site Plan for All Site Information

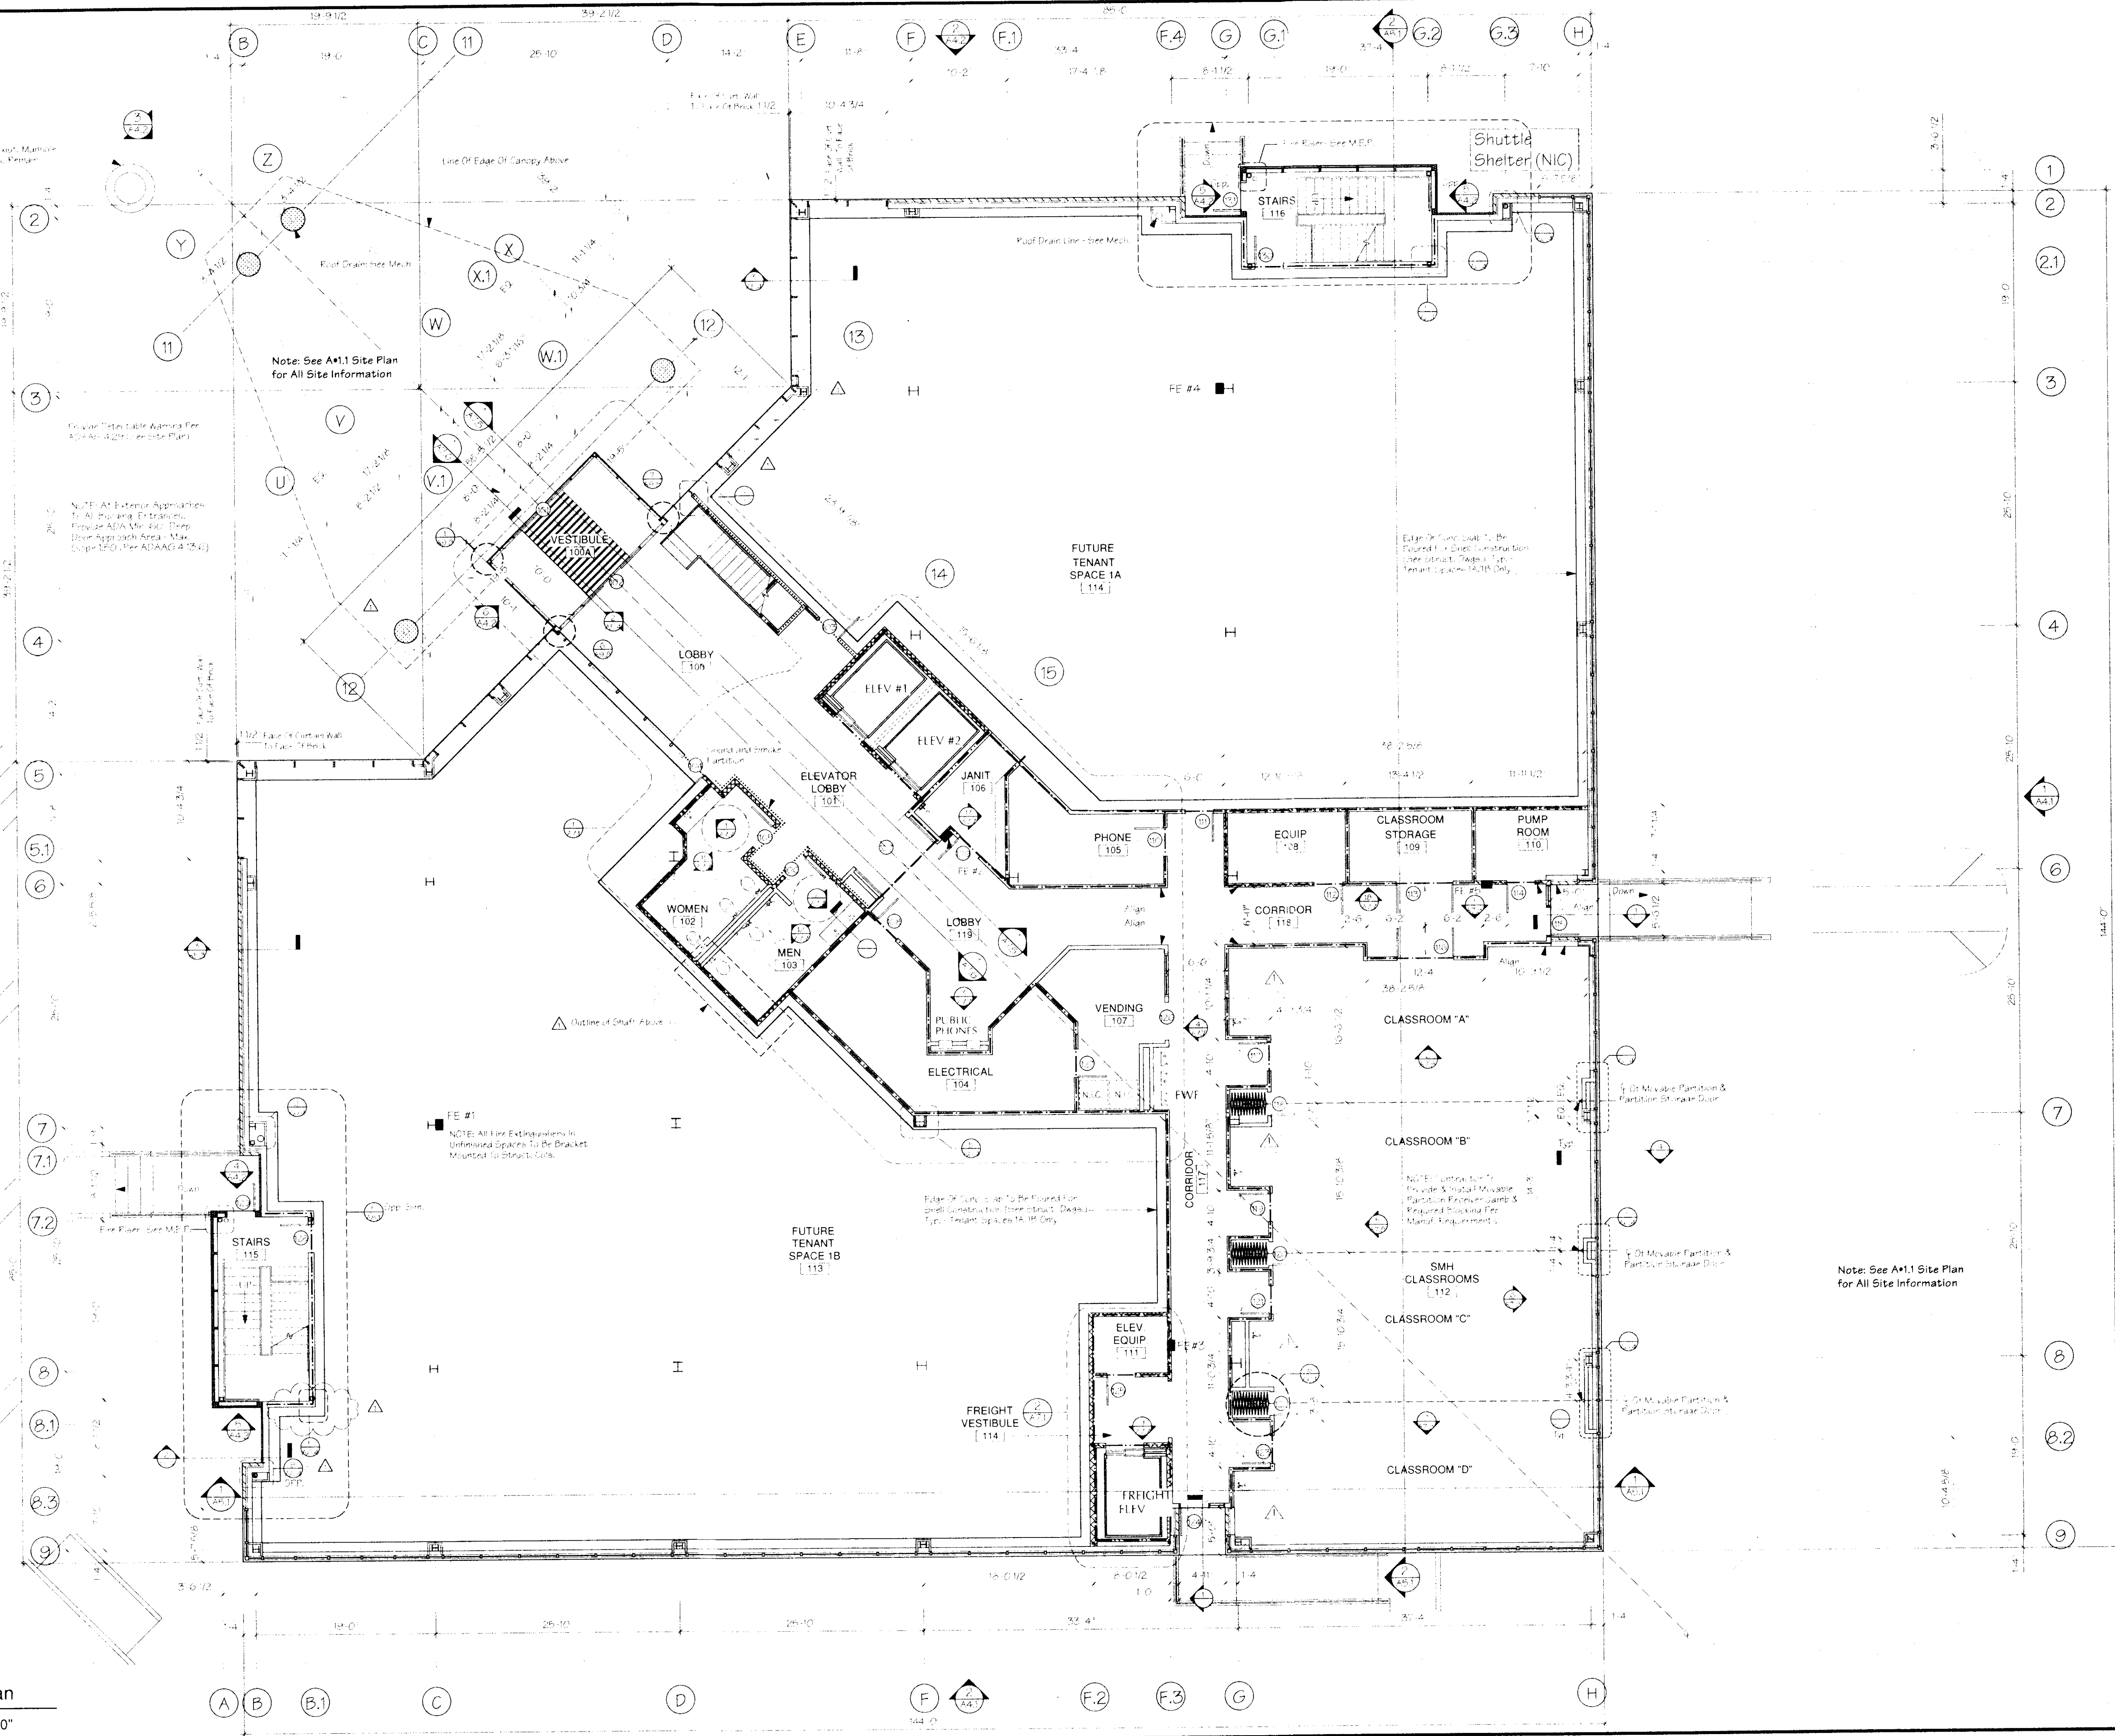

Sidell Memorial Hospital  
**Medical Office Building 3-Shell**  
 Sidell, Louisiana  
**JOHN T. CAMPO & ASSOCIATES, INC.**  
 ARCHITECTS PLANNERS  
 THE LYKES CENTER, SUITE 201900 Poydras Street  
 NEW ORLEANS, LA 70112 (504) 568-9912

**ISSUE DATES**

DATE	ISSUED TO	USE RESTRICTION
12-98	Owner	Review
3-11-99	Owner	DD Review
4-6-99	Owner	75% Review
6-12-99	Owner	95% Review
6-23-99	Owner	Bidding

**REVISIONS**

DATE	BY	DESCRIPTION
7-15-98	FMB	Clarification of Shaft Outline
7-15-98	FMB	Add Sinks in Casem

**PROGRESS PRINT**  
 NOT FOR CONSTRUCTION

**PARTIAL RELEASE**  
 ONLY TO EXTENT NOTED HEREON. PARTS OF THIS DRAWING ARE RELEASED BY THE ARCHITECT FOR CONSTRUCTION.

**FULL RELEASE**  
 THIS DRAWING IS FULLY RELEASED BY THE ARCHITECT FOR CONSTRUCTION OF THIS PROJECT ONLY.

DATE: 6/23/98  
 ALL RIGHTS RESERVED NOT TO BE COPIED OR REPRODUCED WITHOUT EXPRESS WRITTEN CONSENT OF JOHN T. CAMPO & ASSOCIATES, INC.

COPYRIGHT © JOHN T. CAMPO & ASSOCIATES, INC., 1998

JOB NUMBER  
 9740

DRAWN BY  
 JWZ

CHECKED BY  
 RSS

1ST FLOOR PLAN  
**A\*2.1**  
 OF SHEETS

**1** First Floor Plan  
 A2.1  
 SCALE: 1/8" = 1'-0"