



1 FIRST FLOOR PLAN - POWER & SPECIAL SYSTEMS  
 E-B SCALE: 1/8"=1'-0"

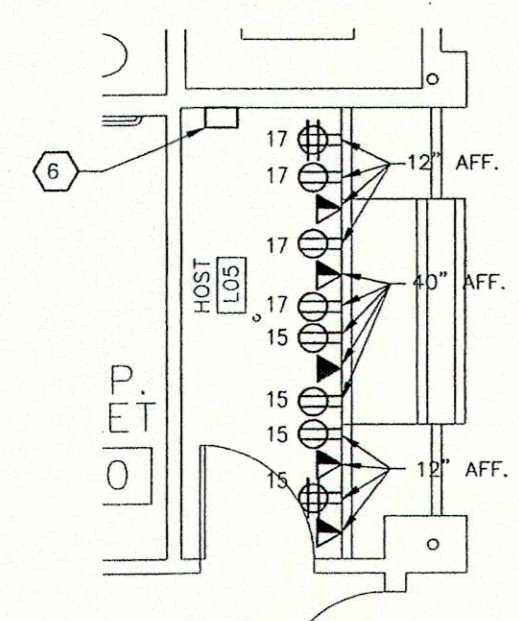

2 FRONT DESK PARTIAL PLAN  
 E-B SCALE: 1/4"=1'-0"

- KEYNOTES**
- 1 DOOR TO RELEASE UPON POWER OUTAGE.
  - 2 INTERCOM RECEIVER AT FRONT DESK
  - 3 REFRIGERATOR
  - 4 MOUNT ABOVE BACKSPASH.
  - 5 WASHER
  - 6 DRYER
  - 7 MICROWAVE.
  - 8 J-BOX FOR HEATER. PROVIDE MOTOR-RATED SWITCH.
  - 9 CONNECT TO NEAREST 120V. CIRCUIT, TO POWER DAMPERS.
- GENERAL NOTES:**
- 1. REFER TO DWG. E-9 FOR TYPICAL GUEST UNIT ENLARGED PLANS.
  - 2. VERIFY LOCATIONS OF ALL EQUIPMENT PRIOR TO ROUGH-INS.

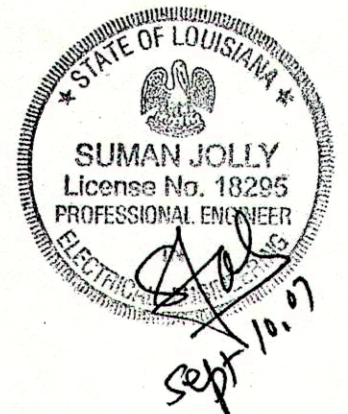

L&H ACAD SERVICES, LLC  
 (504) 884-2902  
 GRETNÁ, LOUISIANA

78 ROOMS SLEEP-INN SUITES  
 LOTS 4 AND 5 - ST. MARY PARISH  
 BERWICK, LOUISIANA



OWNER:  
 MR. BUI NGUYEN

TITLE  
 FIRST FLOOR  
 PLAN  
 POWER

DATE  
 6/16/08

SHEET NUMBER  
 E-6

20