


THIRD FLOOR LIGHTING PLAN  
SCALE: 1/8"=1'-0"

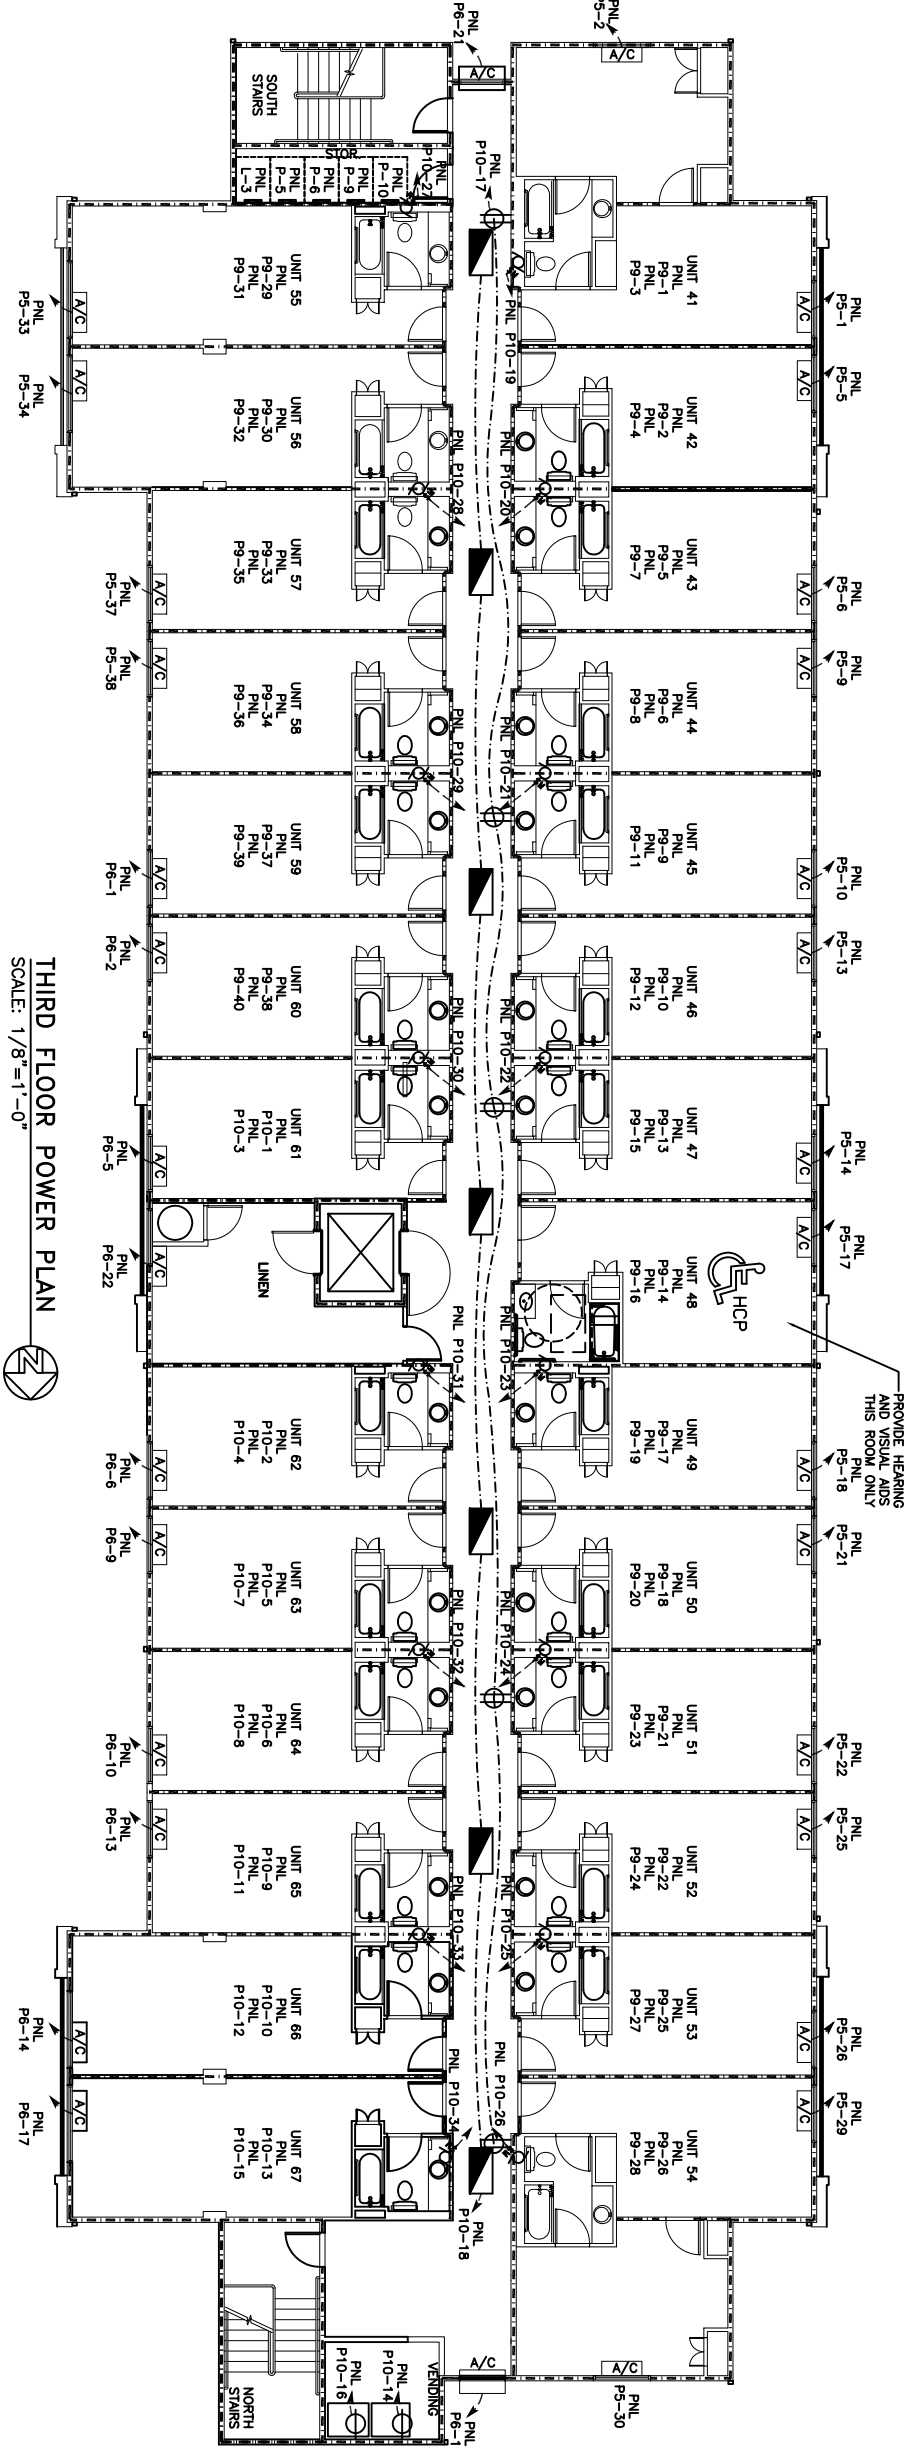

THIRD FLOOR POWER PLAN  
SCALE: 1/8"=1'-0"

--- DENOTES 1 HR. FIREWALL - SEE UL U333 OR U556, SH1. A-2

3RD FLR. ELECTRICAL PLAN  
DR. EDUARDO HERNANDEZ  
CEDAR LAKE ROAD  
BILOXI, MISSISSIPPI

LA QUINTA INN & SUITES  
**DAMMON ENGINEERING. INC.**  
1095 FLORIDA AVENUE 985-649-5832 SLIDELL, LA. 70458  
DAMMONENGINEERING.COM

SCALE: AS NOTED  
FILE:  
JOB NO. 1694  
DATE: 11-01-05

SHEET  
E-4  
OF