


2ND, 3RD, & 4TH FLOOR POWER PLANS
SCALE: 1/8" = 1'-0"

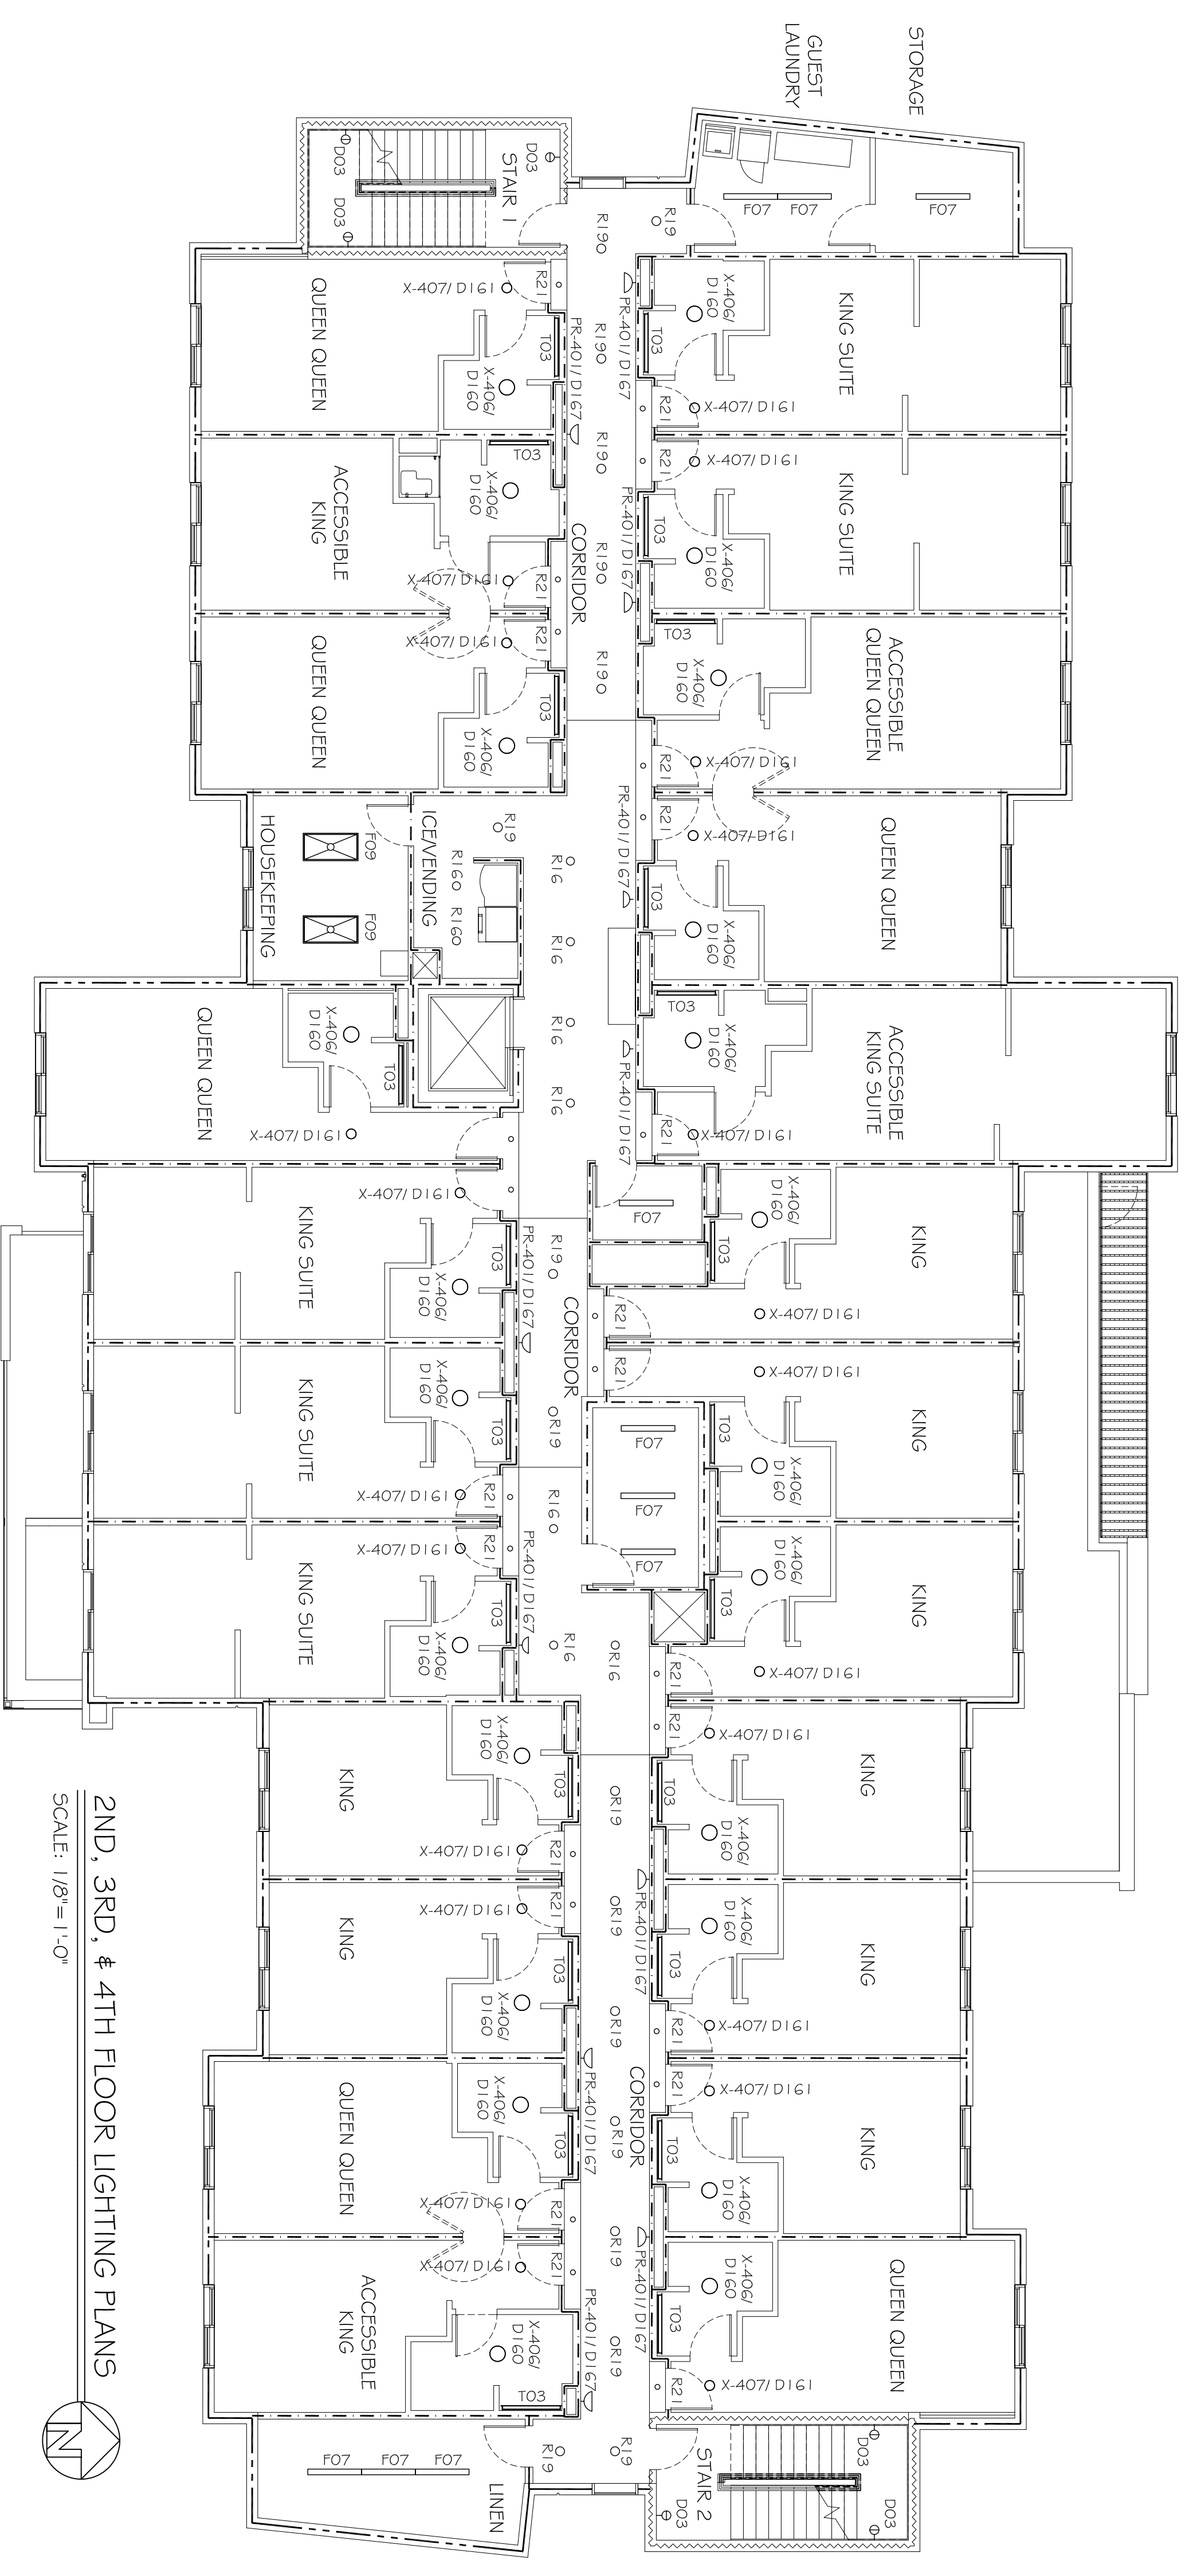

2ND, 3RD, & 4TH FLOOR LIGHTING PLANS
SCALE: 1/8" = 1'-0"

- LEGEND**
- 1 HOUR RATED INTERIOR WALL
SEE U# U333 - THIS SHEET
 - 1 HOUR RATED EXTERIOR WALL
SEE U# U356 - THIS SHEET
 - 2 HOUR RATED EXTERIOR WALL
SEE U# U301 - THIS SHEET
 - FE 0
- FIRE EXTINGUISHER
- NOTE:**
PRE-FABRICATED ROOF, FLOOR, WALLS,
BEAMS AND COLUMNS PROVIDED BY OTHERS.

PRELIMINARY (NOT FOR CONSTRUCTION)

2ND, 3RD, & 4TH FLOOR ELECTRICAL PLANS
SHEET No: 00 OF 00
E2

REVISIONS		DATE
#	DESCRIPTION	

FAIRFIELD INNS & SUITES			
01 PREEPS CENTRE DRIVE VICKSBURG, MISSISSIPPI 39180			
JOB No:	2181	DATE:	08-01-2013
DRAWN BY:	JTL	CHECKED BY:	CKD

DAMMON
ENGINEERING, INC.
Architects & Engineers

CHIEF ENGINEER: EMMETT DAMMON, P.E.
554 OLD SPANISH TRAIL
SLIDELL, LA 70458

dammonengineering.com
dammoneng@bellsouth.net
PHONE: 985-649-5832
FAX: 985-641-5990

The above drawings and specifications, designs and arrangements represented hereby are and shall remain the property of Dammon Engineering, and no part thereof shall be copied, reproduced or used in connection with any work or project other than the specific project for which they have been prepared and developed without written consent of Dammon Engineering. Your contact with these drawings or specifications shall constitute conclusive evidence of acceptance of these restrictions.