
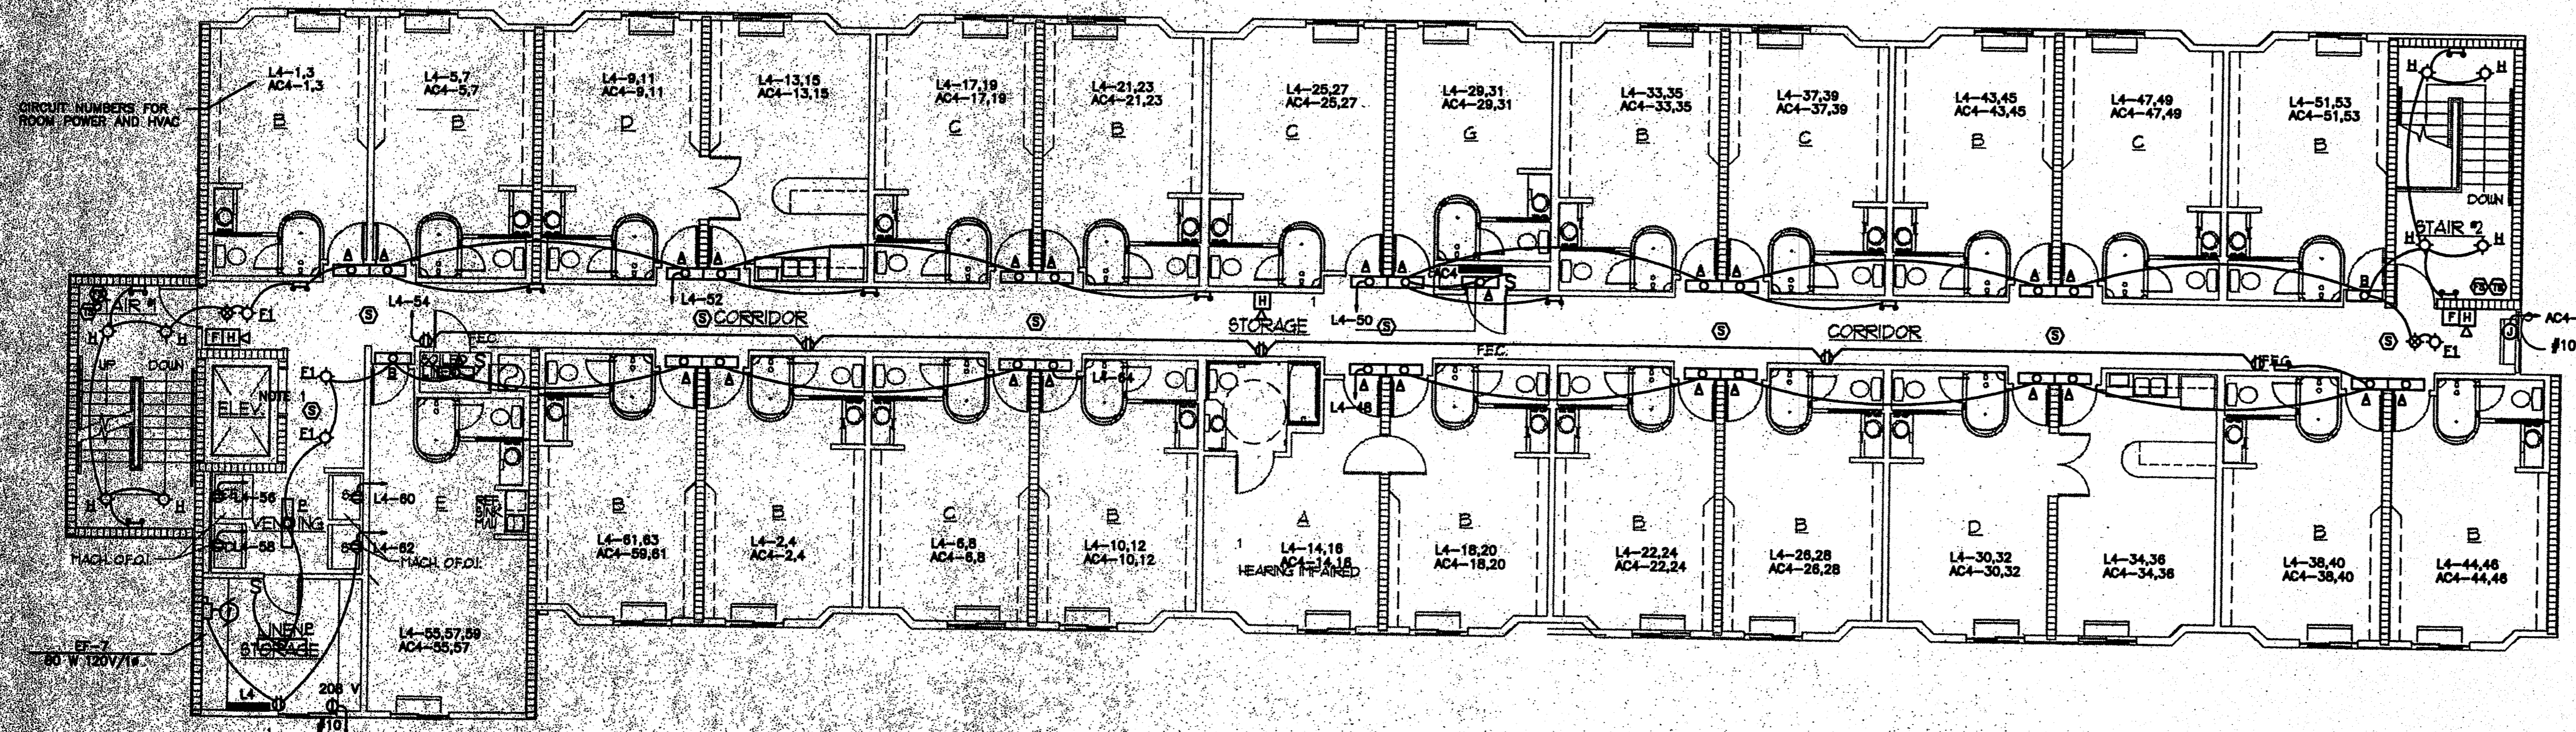


ROOF PLAN ELECTRICAL
1/8" = 1'-0" SCALE

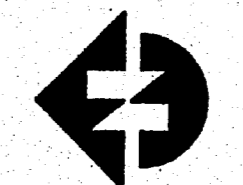

FOURTH FLOOR ELECTRICAL PLAN
1/8" = 1'-0"

SCALE:
22 ROOMS
2 SUITES
TOTAL: 24 ROOMS

LLW, Inc.
803 SOUTH MT. MORIAH, STE. 100B
MEMPHIS, TENNESSEE 38117-5343
901-683-7175/FAX 901-683-2385
LEONARD MESSINA, ARCHITECT

▲ revisions:
OWNER REVIEW 5-27-97
CHG TO PRECAST 8-8-97
FINAL REVIEW 8-28-97
▲ 10-14-97

▲ seal:

Sleep Inn
Jackson, Mississippi

▲ title:
4TH FLOOR AND
ROOF ELECTRICAL
PLANS
▲ date: 8-22-97
▲ job: 1697
▲ file: 1697-A23
▲ scale: 1/8" = 1'-0"

sheet
23
of 10