



NOTES:
 ALL RAINLEADER PIPING ABOVE GRADE SHALL BE NO-HUB CAST IRON. NO EXCEPTIONS.
 PROVIDE CLEANOUTS AT THE BASE OF ALL STACKS AS REQUIRED BY INSPECTOR.

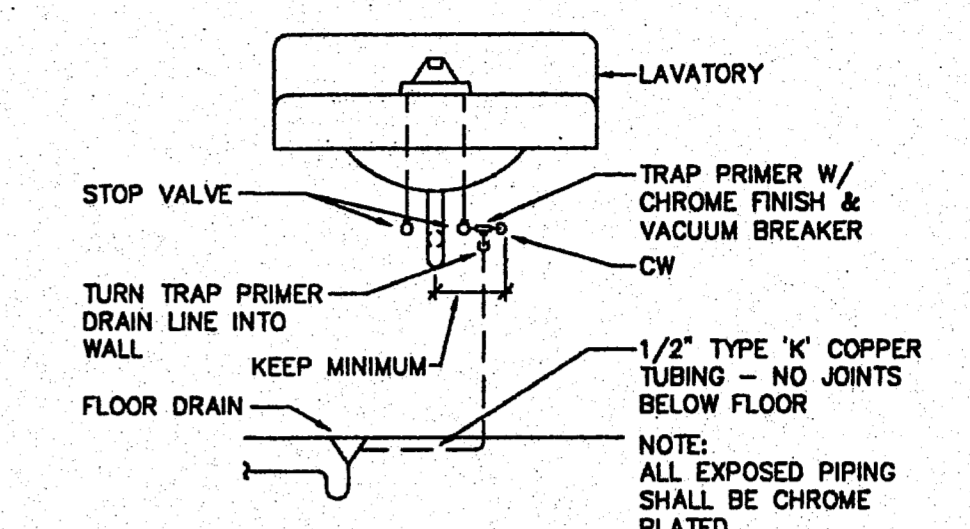


TRAP PRIMER DETAIL
 NOT TO SCALE

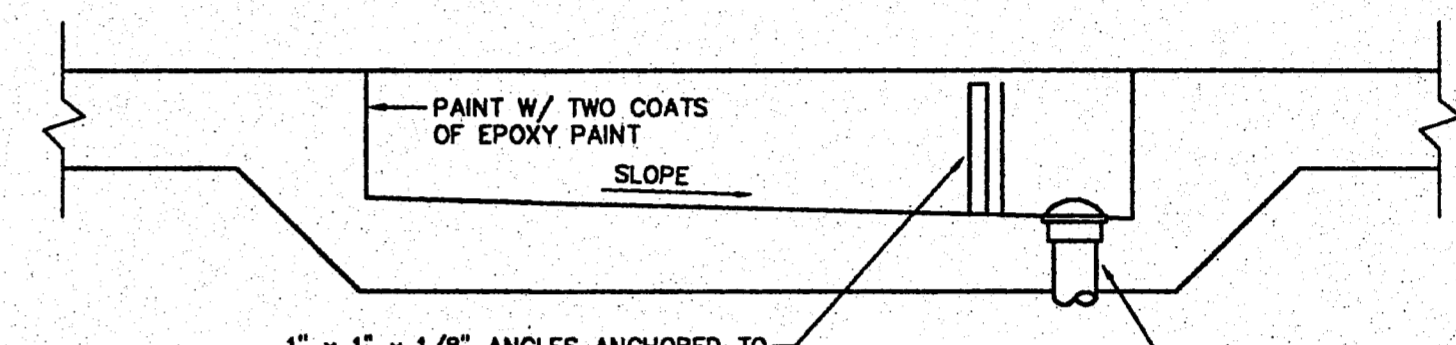

WASHER TRENCH DETAIL
 NOT TO SCALE

NOTE:
 SEE SHEET P1.5 FOR ENLARGED PLANS & RISER DIAGRAMS OF TYPICAL GUEST UNITS

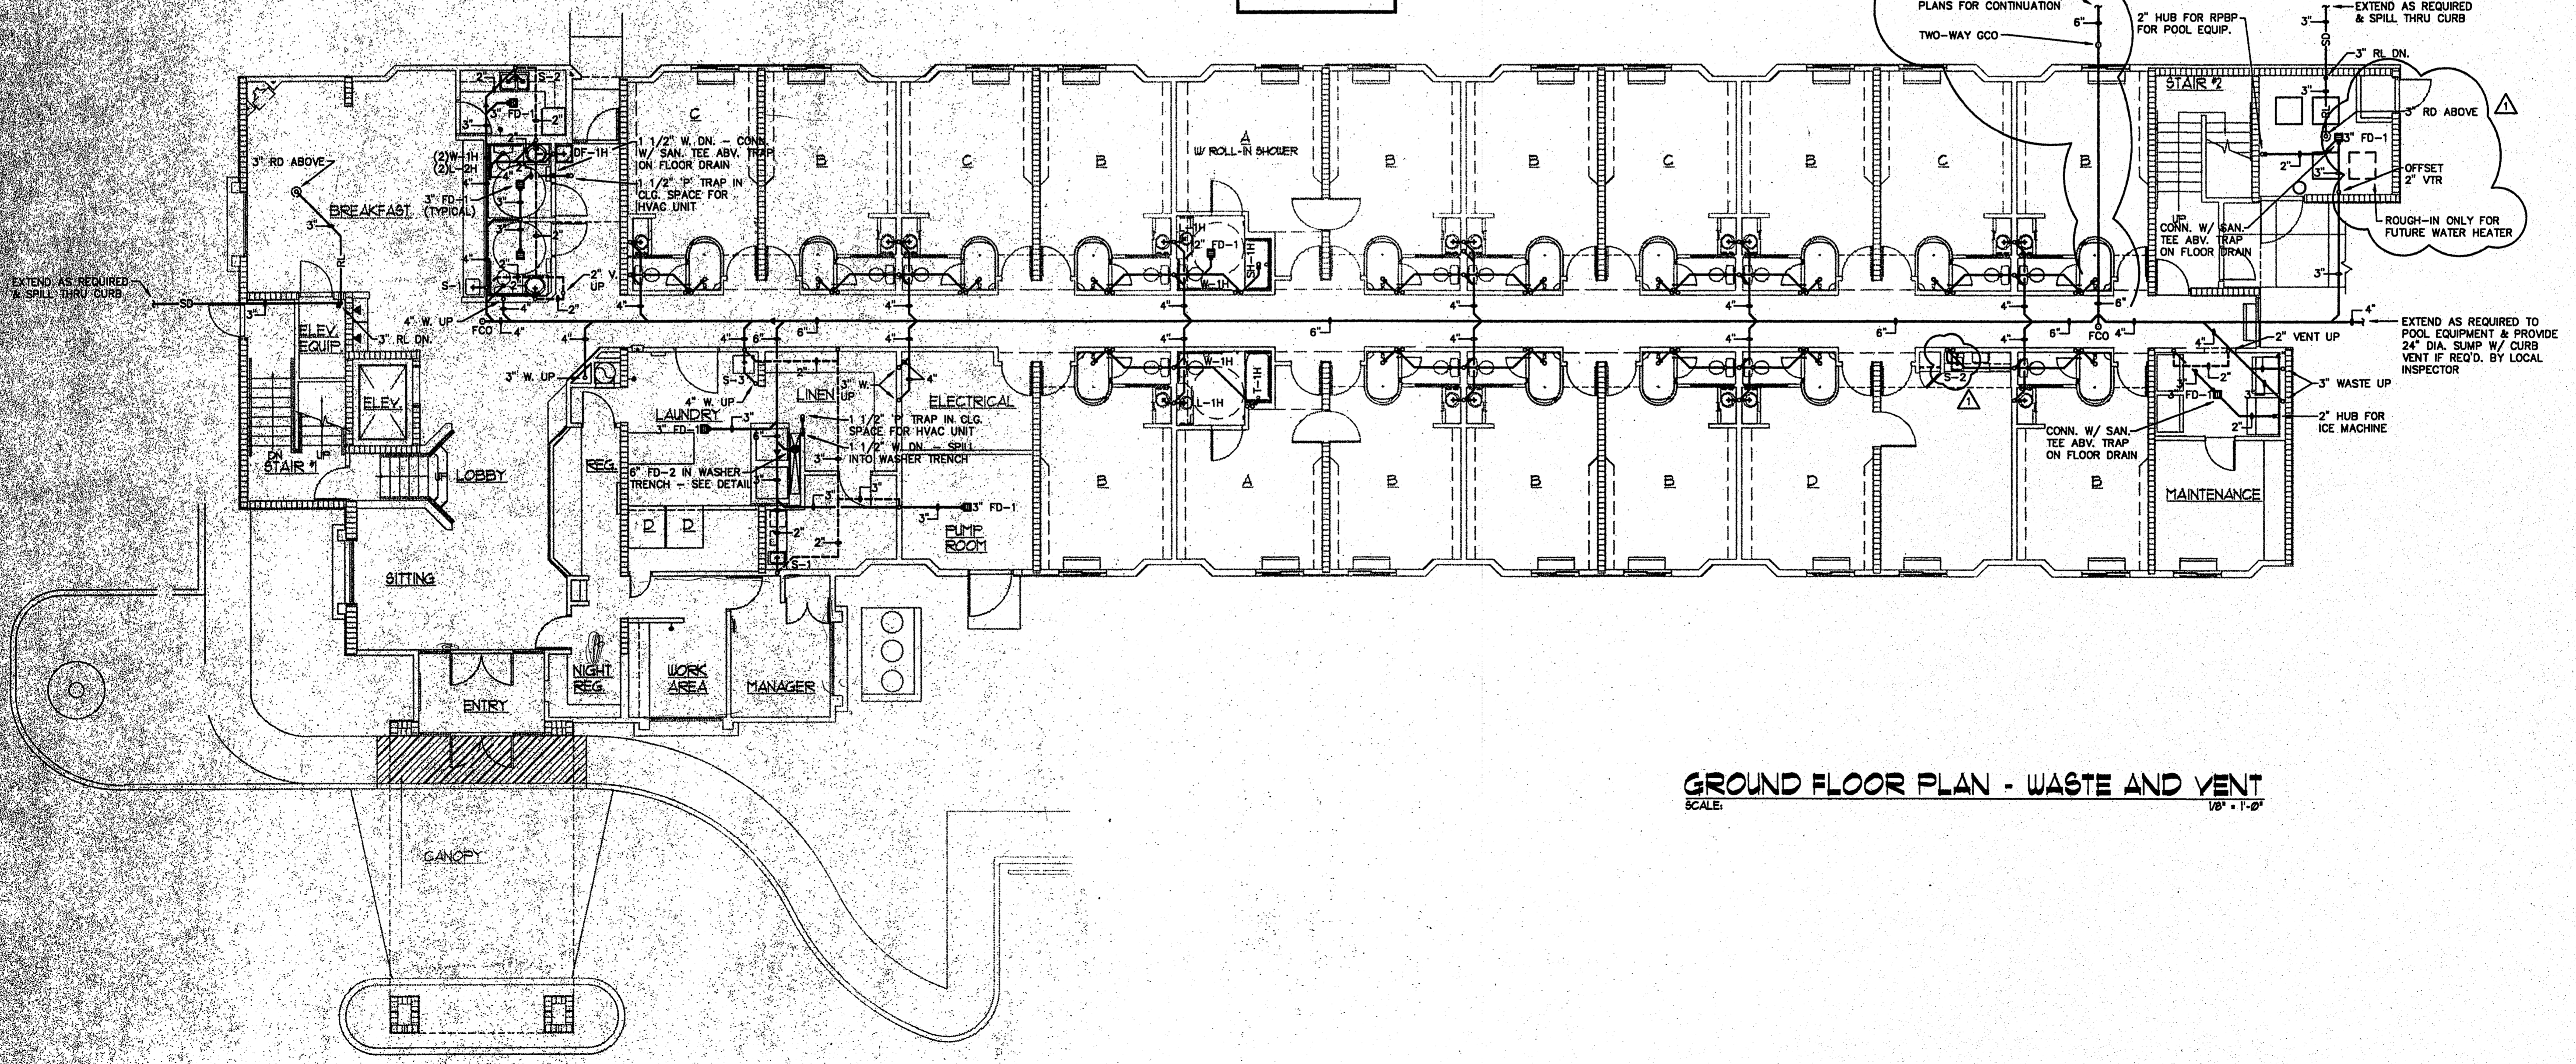

GROUND FLOOR PLAN - WASTE AND VENT
 SCALE: 1/8" = 1'-0"

revisions:

REVIEW	10-24-97

seal:

title:
GROUND FLOOR PLAN - WASTE & VENT

date: 10-14-97
 job: 1697
 file: 1697-P11
 scale: 1/8" = 1'-0"