


COMBUSTION AIR CALCULATIONS FOR WATER HEATERS
 FIVE WATER HEATERS @ 199,000 BTUH EACH
 5 X 199,000 = 995,000 BTUH
 995,000 ÷ 4000 = 248.75 sq. ft.
 248.75 ÷ 144 = 1.73 sq. ft. EACH
 20x14 COMBUSTION AIR DUCT HIGH
 36x24 LOW LOUVER IN DOOR

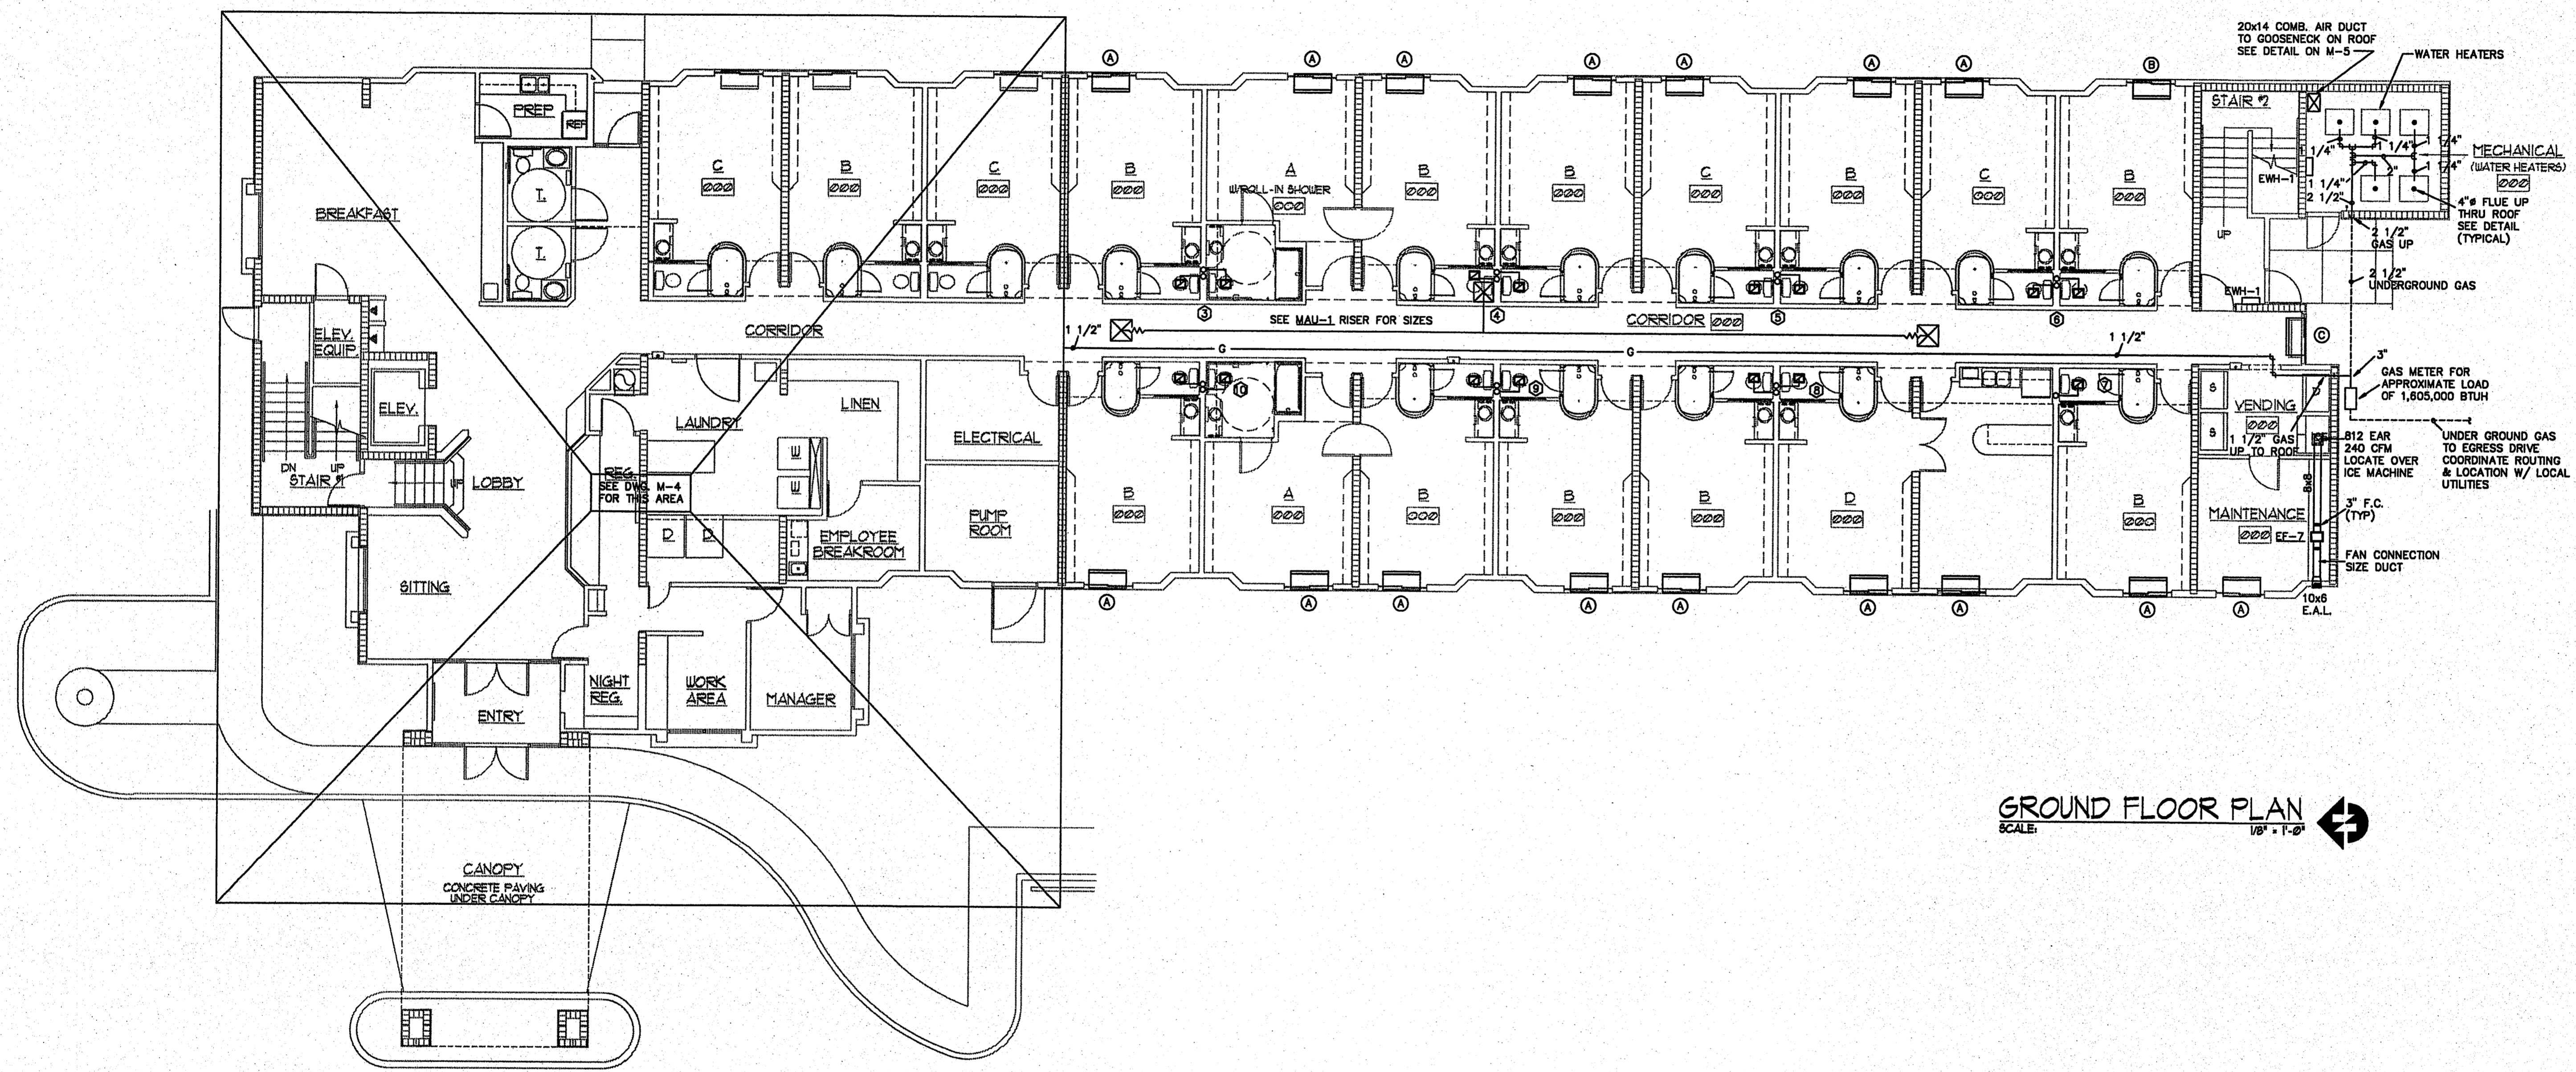

GROUND FLOOR PLAN
 SCALE: 1/8" = 1'-0"

▲ revisions:
 OWNER REVISION 8-21-91
 OWNER REVISION 1-3-91
 CHG TO PRECAST 8-9-91

▲ seal:

Sleep Inn
 Jackson, Mississippi

▲ title:
 GROUND FLOOR PLAN

CONSULTANT
GE
Gala Engineering Inc.
 7975 STAGE HILLS BLVD.
 SUITE 5
 MEMPHIS, TN. 38133
 TEL. (901) 384-8400
 FAX (901) 373-2255

▲ date: 8-22-91
 ▲ job: 1691
 ▲ file: 1691-A21
 ▲ scale: 1/8" = 1'-0"

sheet
M-1