


ROOF PLAN

SCALE: 1/8" = 1'-0"

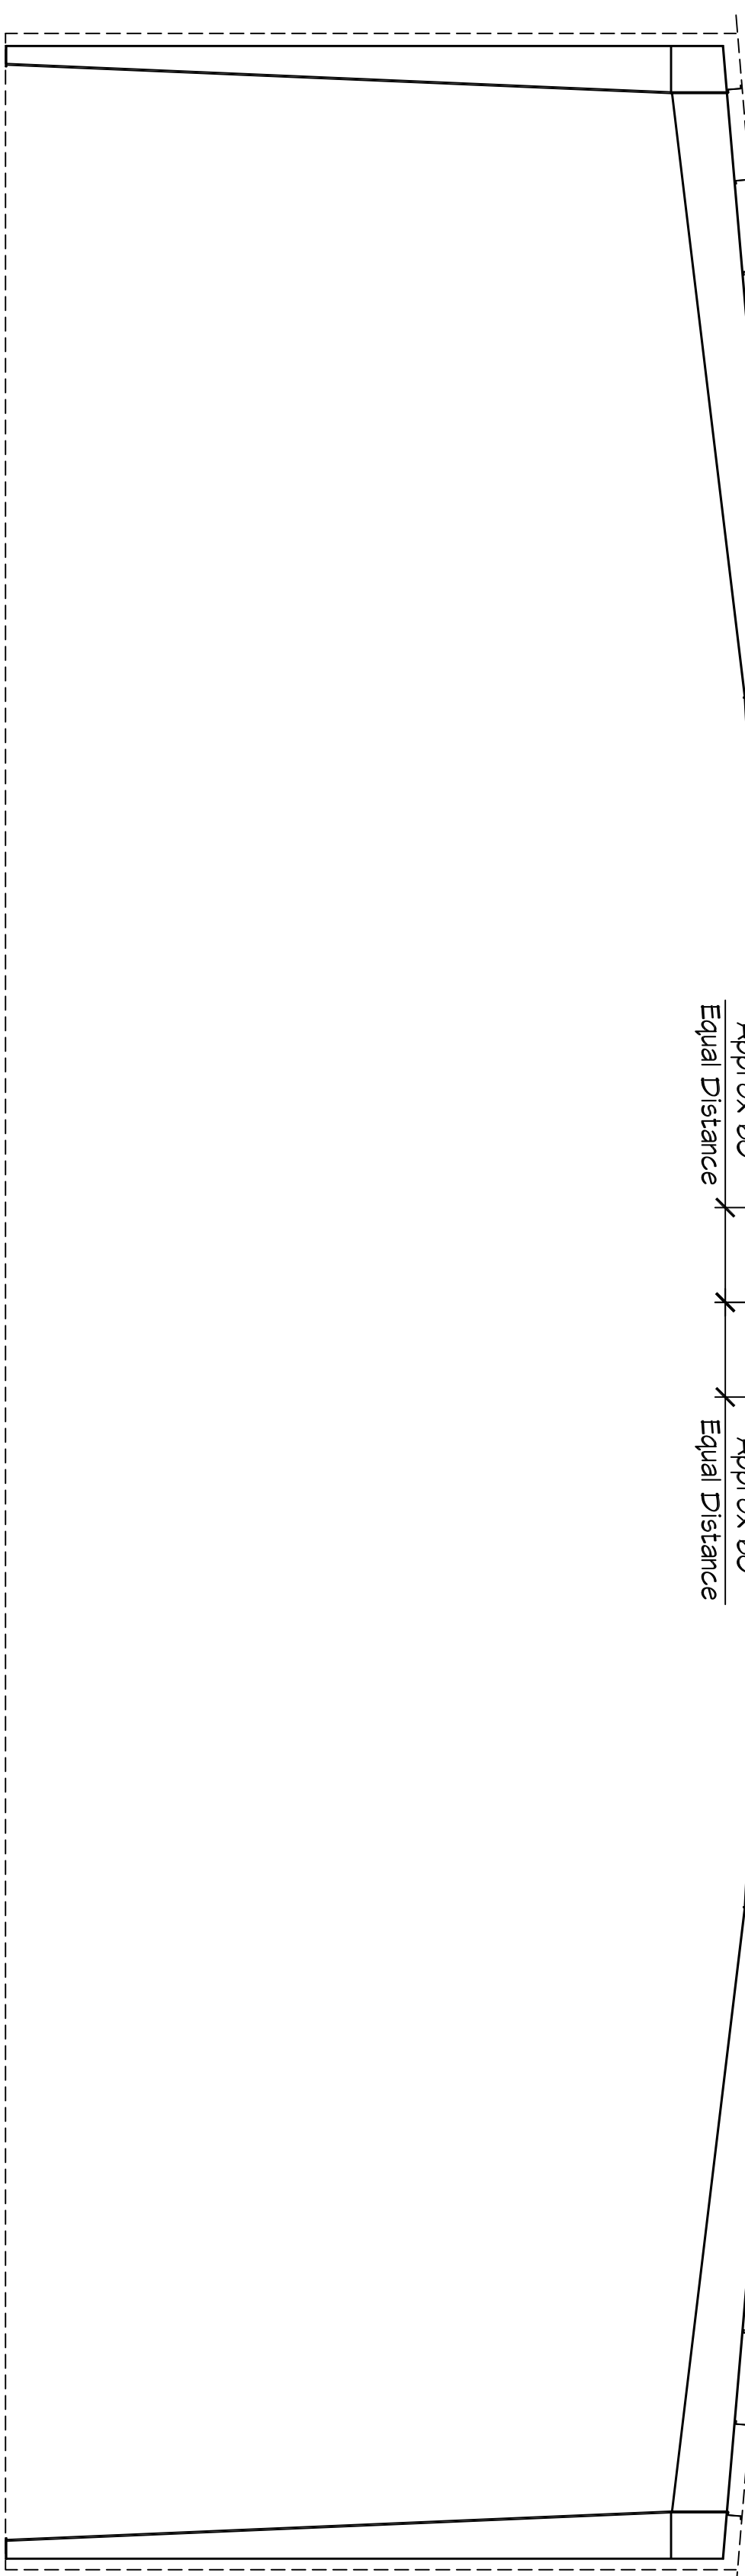

SECTION


SCALE: 1/8" = 1'-0"

TYPICAL COLUMN ROOM INSIDE WAREHOUSE

DETAILS

SCALE: 1" = 1'-0"

TYPICAL 3" PIPE SUPPORT

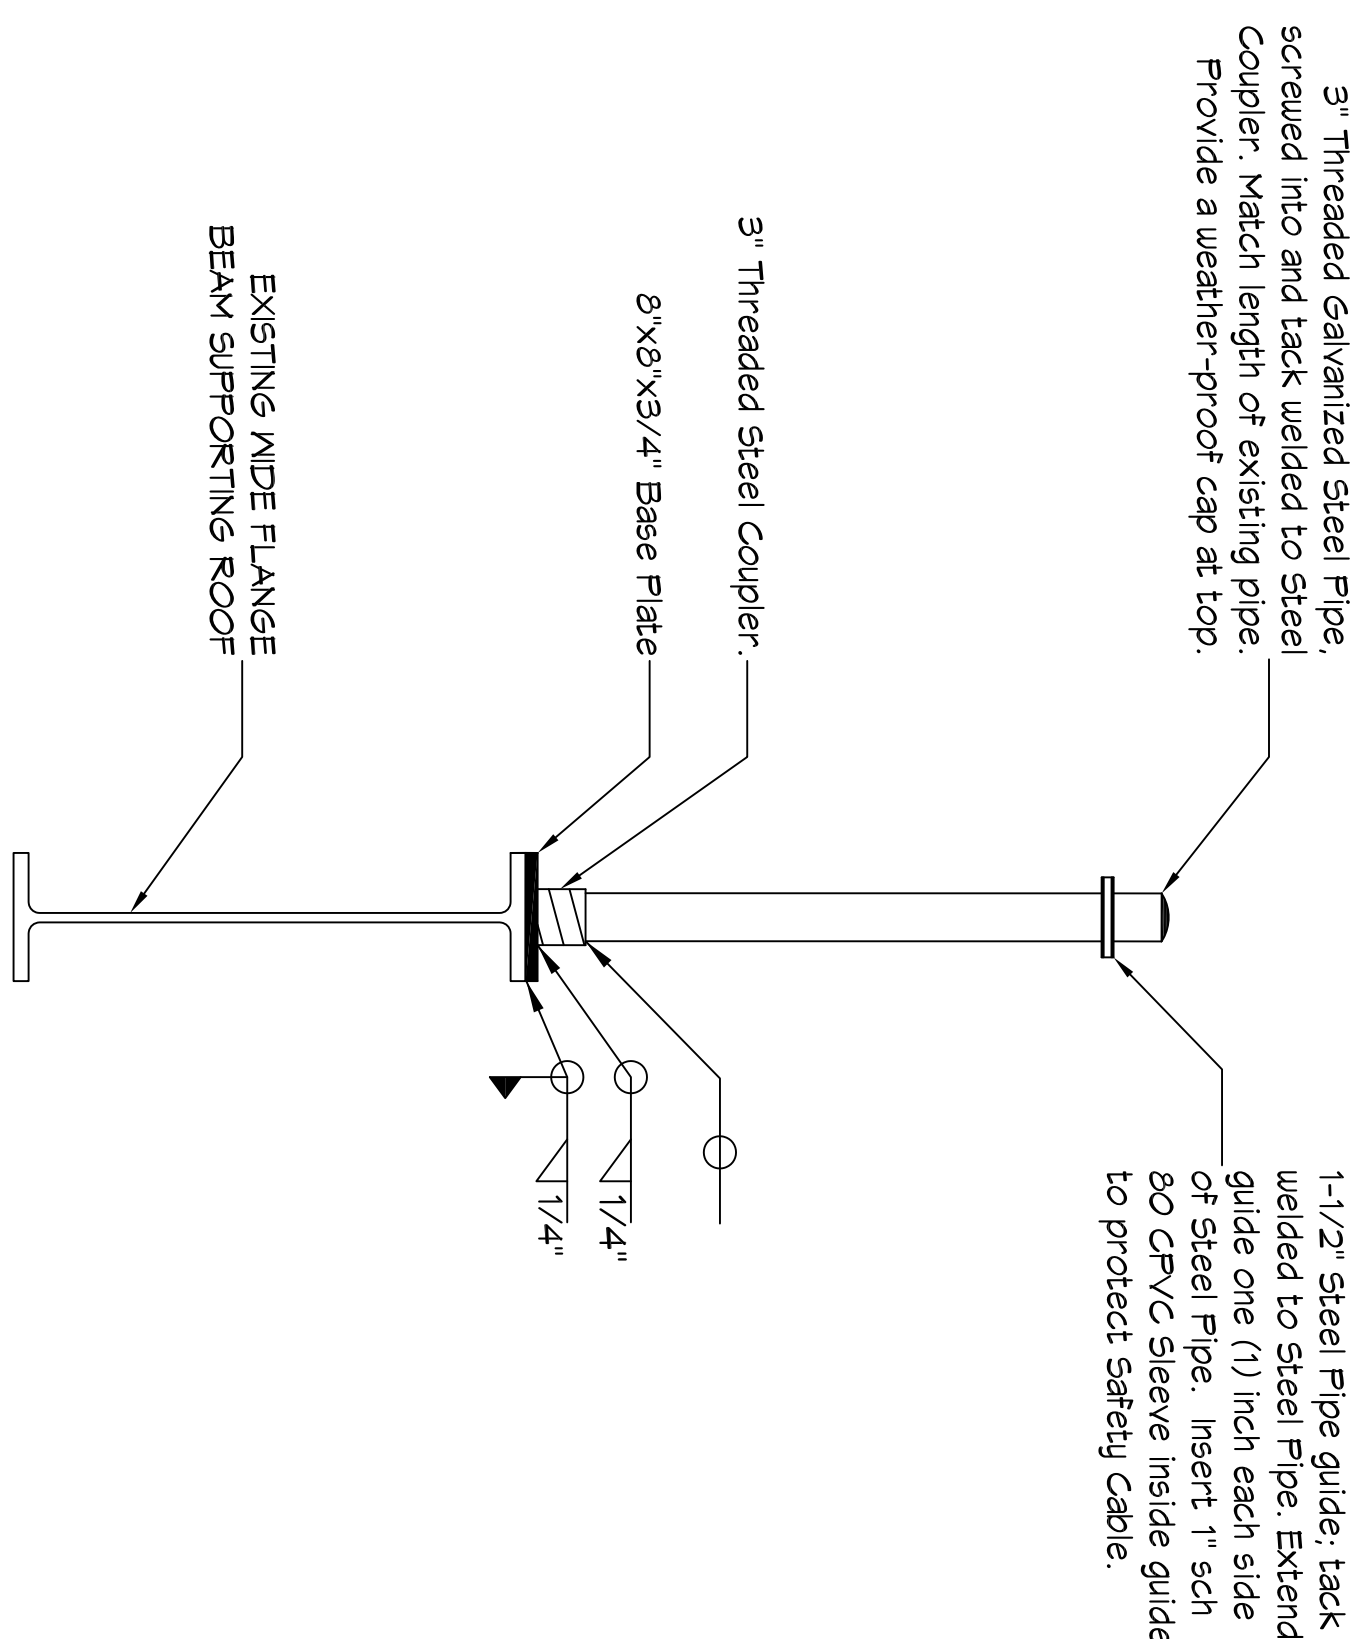

TEXTRON MARINE AND LAND
 FALL PROTECTION SYSTEMS
 19401 CHEF MENTUER HWY
 NEW ORLEANS, LA 70124
 JOB No: [####] DATE: 1/27/2017
 DRAWN BY: DPD CHECKED BY: BA

The above drawings and specifications, design and drawings are registered hereby and shall remain the property of Dammon Engineering, and no part thereof shall be copied, reproduced, or used in connection with any work or project other than the specific project for which they have been prepared and distributed without written consent of Dammon Engineering. Please contact with these drawings for specifications, shall constitute the entire contract of Dammon Engineering.

REVISIONS		
#	DESCRIPTION	DATE

DAMMON ENGINEERING, INC.
 LOUISIANA & MISSISSIPPI
 Chief Engineer: Brian Mistich, PE
 554 Old Spanish Trail
 Slidell, LA 70458
 www.dammonengineering.com
 info@dammonengineering.com
 PH: 985.649.5832 F: 985.641.5950

DRAWING NUMBER:
S101
 SHEET No: 1 of 8